

28700411



Republic of the Philippines  
**Department of Public Works and Highways**  
REGIONAL OFFICE NO. VIII  
Government Center, Baras, Palo, Leyte

C.Y. 2025 PROJECT  
PLAN FOR  
**REPAIR/MAINTENANCE/IMPROVEMENT OF  
DPWH BUILDING**  
TECHNICAL WORKING GROUP (TWG) BUILDING

DEPARTMENT OF PUBLIC WORKS AND HIGHWAYS, REGIONAL OFFICE VIII,  
BARAS, PALO, LEYTE

11°10'22.8"N 125°00'35.4"E  
11.173008, 125.009830

SUBMITTED:

  
LUCAS N. BACSAL  
CHIEF, MAINTENANCE DIVISION  
DATE: 

RECOMMENDED:

  
MA. MARGARITA C. JUNIA, D.M.  
ASSISTANT REGIONAL DIRECTOR  
DATE: 

APPROVED:

  
EDGAR B. TABACON, CESO IV  
REGIONAL DIRECTOR  
DATE: 



Republic of the Philippines  
**Department of Public Works and Highways**  
REGIONAL OFFICE NO. VIII  
Government Center, Baras, Palo, Leyte

C.Y. 2025 PROJECT  
PLAN FOR  
**REPAIR/MAINTENANCE/IMPROVEMENT OF  
DPWH BUILDING**  
TECHNICAL WORKING GROUP (TWG) BUILDING

DEPARTMENT OF PUBLIC WORKS AND HIGHWAYS, REGIONAL OFFICE VIII,  
BARAS, PALO, LEYTE


11°10'22.8"N 125°00'35.4"E  
11.173008, 125.009830

**SPECIFICATION REFERENCE:**

DPWH STANDARD SPECIFICATIONS VOLUME III 1995, BUILDINGS, PORTS & HARBORS,  
FLOOD CONTROL & DRAINAGE STRUCTURES & WATER SUPPLY SYSTEM.


DPWH STANDARD SPECIFICATIONS 2013 VOLUME II, HIGHWAYS, BRIDGES AND AIRPORTS.

|                                                                                                                                                                                                                                    |                                                                                                                                                          |                    |                                                                                                                                      |                                                                                                                                                    |                                                                                                                                                                 |                                                                                                                                                    |            |           |
|------------------------------------------------------------------------------------------------------------------------------------------------------------------------------------------------------------------------------------|----------------------------------------------------------------------------------------------------------------------------------------------------------|--------------------|--------------------------------------------------------------------------------------------------------------------------------------|----------------------------------------------------------------------------------------------------------------------------------------------------|-----------------------------------------------------------------------------------------------------------------------------------------------------------------|----------------------------------------------------------------------------------------------------------------------------------------------------|------------|-----------|
| <br>Republic of the Philippines<br>DEPARTMENT OF PUBLIC WORKS AND HIGHWAYS<br>REGIONAL OFFICE NO. VIII<br>GOVERNMENT CENTER, BARAS, PALO, LEYTE | PROJECT TITLE:                                                                                                                                           | SHEET CONTENTS:    | PREPARED:                                                                                                                            | SUBMITTED:                                                                                                                                         | RECOMMENDED FOR APPROVAL:                                                                                                                                       | APPROVED:                                                                                                                                          | SET NO.    | SHEET NO. |
|                                                                                                                                                                                                                                    | REPAIR/MAINTENANCE/IMPROVEMENT OF<br>DPWH BUILDING,<br>TECHNICAL WORKING GROUP (TWG) BUILDING<br>LOCATION: DPWH REGIONAL OFFICE VIII, BARAS, PALO, LEYTE | GENERAL COVER PAGE | <br>NOEL B. BALINA<br>ARCHITECT - II<br>DATE: # | <br>LUCAS N. BACSAL<br>CHIEF, MAINTENANCE DIVISION<br>DATE: # | <br>MA. MARGARITA C. JUNIA, D.M.<br>ASSISTANT REGIONAL DIRECTOR<br>DATE: # | <br>EDGAR B. TABACON, CESO IV<br>REGIONAL DIRECTOR<br>DATE: # | GCP<br>1 3 | 1<br>34   |

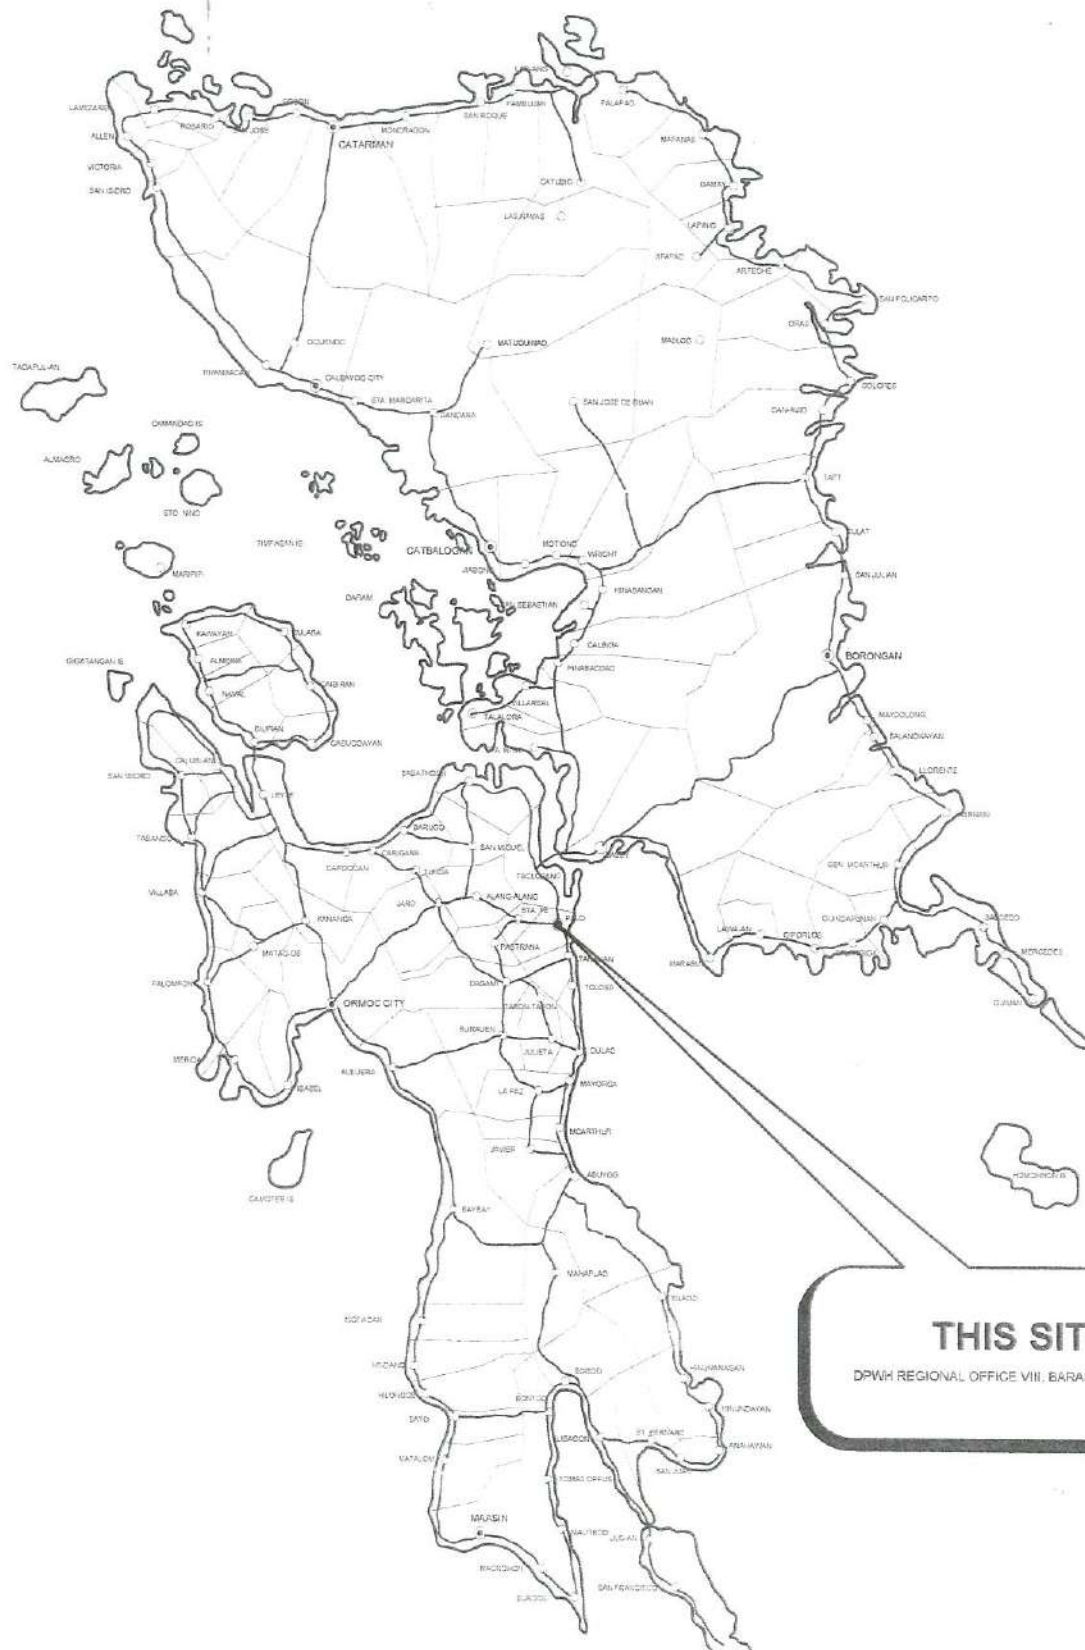

**THIS SITE**  
DPWH REGIONAL OFFICE VIII, BARAS, PALAW

**THIS SITE**  
DPWH REGIONAL OFFICE VIII, BARAS, PALAW, LEYTE

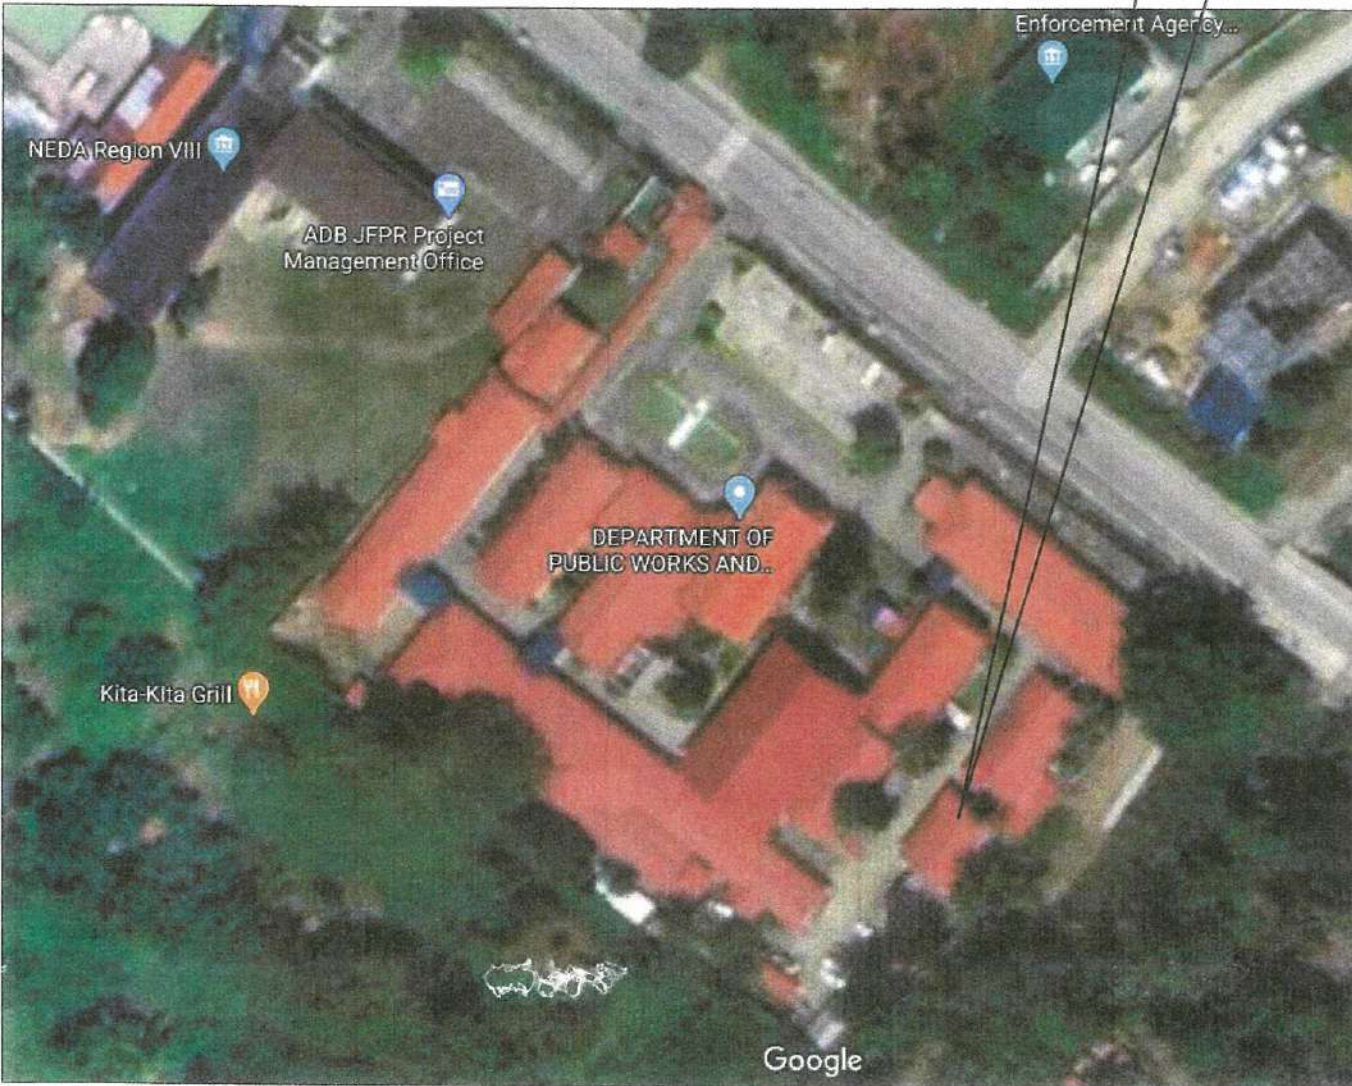

**2 VICINITY MAP**  
GCP-2 DRAWN NOT TO SCALE

**1 LOCATION MAP**  
GCP-2 DRAWN NOT TO SCALE

|                                                                                                                                                                                                                                            |                                                                                                                                                                                          |                                                             |                                                                                                                                                                         |                                                                                                                                                                                        |                                                                                                                                                                                                                    |                                                                                                                                                                                       |                                       |
|--------------------------------------------------------------------------------------------------------------------------------------------------------------------------------------------------------------------------------------------|------------------------------------------------------------------------------------------------------------------------------------------------------------------------------------------|-------------------------------------------------------------|-------------------------------------------------------------------------------------------------------------------------------------------------------------------------|----------------------------------------------------------------------------------------------------------------------------------------------------------------------------------------|--------------------------------------------------------------------------------------------------------------------------------------------------------------------------------------------------------------------|---------------------------------------------------------------------------------------------------------------------------------------------------------------------------------------|---------------------------------------|
|  <p>Republic of the Philippines<br/>DEPARTMENT OF PUBLIC WORKS AND HIGHWAYS<br/>REGIONAL OFFICE NO. VIII<br/>GOVERNMENT CENTER, BARAS, PALAW, LEYTE</p> | <p>PROJECT TITLE:<br/><b>REPAIR/MAINTENANCE/IMPROVEMENT OF DPWH BUILDING, TECHNICAL WORKING GROUP (TWG) BUILDING</b></p> <p>LOCATION: DPWH REGIONAL OFFICE VIII, BARAS, PALAW, LEYTE</p> | <p>SHEET CONTENTS:<br/><b>LOCATION MAP VICINITY MAP</b></p> | <p>PREPARED:<br/><br/><b>NOEL B. BALINA</b><br/>ARCHITECT - II<br/>DATE: _____</p> | <p>SUBMITTED:<br/><br/><b>LUCAS N. BACSAN</b><br/>CHIEF, MAINTENANCE DIVISION<br/>DATE: _____</p> | <p>RECOMMENDED FOR APPROVAL:<br/><br/><b>MA. MARGARITA C. JUNIA, D.M.</b><br/>ASSISTANT REGIONAL DIRECTOR<br/>DATE: _____</p> | <p>APPROVED:<br/><br/><b>EDGAR B. TABACON, CESO IV</b><br/>REGIONAL DIRECTOR<br/>DATE: _____</p> | <p>SHEET NO.:<br/><b>2</b><br/>34</p> |
|--------------------------------------------------------------------------------------------------------------------------------------------------------------------------------------------------------------------------------------------|------------------------------------------------------------------------------------------------------------------------------------------------------------------------------------------|-------------------------------------------------------------|-------------------------------------------------------------------------------------------------------------------------------------------------------------------------|----------------------------------------------------------------------------------------------------------------------------------------------------------------------------------------|--------------------------------------------------------------------------------------------------------------------------------------------------------------------------------------------------------------------|---------------------------------------------------------------------------------------------------------------------------------------------------------------------------------------|---------------------------------------|



Republic of the Philippines  
Department of Public Works and Highways

REGIONAL OFFICE NO. VIII

Government Center, Baras, Palo, Leyte

PROJECT TITLE : REPAIR/MAINTENANCE/IMPROVEMENT OF DPWH BUILDING  
SUPPLY & PROPERTY MANAGEMENT SECTION (PHASE-II)

LOCATION : DEPARTMENT OF PUBLIC WORKS AND HIGHWAYS, REGIONAL  
OFFICE VIII, BARAS, PALO, LEYTE

SUMMARY OF QUANTITIES:

| Item No.      | Description                                                                                                                             | Unit  | Quantity |
|---------------|-----------------------------------------------------------------------------------------------------------------------------------------|-------|----------|
| <b>Part B</b> | <b>OTHER GENERAL REQUIREMENTS, DPWH Standard Specification for Public Works Structures (Vol. III)</b>                                   |       |          |
| B.5 (1)       | Project Billboard/Signboard                                                                                                             | Each  | 2.00     |
| B.7 (1)       | Occupational Safety and Health                                                                                                          | L.S.  | 1.00     |
| B.9 (1)       | Mobilization / Demobilization                                                                                                           | L.S.  | 1.00     |
| B.24          | General Scaffolding, Shoring and Netting                                                                                                | L.S.  | 1.00     |
| <b>Part C</b> | <b>EARTHWORK - DPWH Standard Specification for Public Works Structures (Vol. III), Division I - General</b>                             |       |          |
| 801 (1)       | Removal of Structures and Obstruction                                                                                                   | L.S.  | 1.00     |
| 803 (1) a     | Structure Excavation, Common Soil                                                                                                       | Cu.M  | 2.60     |
| 804 (1) a     | Embankment, from Roadway/Structure Excavation, Common Soil                                                                              | Cu.M  | 1.37     |
| 804 (2) a     | Embankment, from Borrow, Common Soil                                                                                                    | Cu.M  | 7.30     |
| 804 (7)       | Gravel Fill                                                                                                                             | Cu.M  | 0.60     |
| <b>Part D</b> | <b>REINFORCED CONCRETE - DPWH Standard Specification for Public Works Structures (Vol. III), Division I - General</b>                   |       |          |
| 900 (1) h     | Structural Concrete (Class A, 14 Days)                                                                                                  | Cu.M  | 1.80     |
| 902 (1) a1    | Reinforcing Steel (Deformed), Grade 40                                                                                                  | Kg.   | 148.34   |
| 903 (2)       | Formworks and Falseworks (for one-storey building)                                                                                      | Sq.M. | 19.00    |
| <b>PART E</b> | <b>FINISHINGS &amp; OTHER CIVIL WORKS - DPWH Standard Specification for Public Works Structures (Vol. III), Division II - Buildings</b> |       |          |
| <b>1001</b>   | <b>Storm Drainage and Sewerage System</b>                                                                                               |       |          |
| 1001 (9)      | Storm Drainage and Downspout                                                                                                            | L.S.  | 1.00     |
| <b>1002</b>   | <b>Plumbing Works</b>                                                                                                                   |       |          |
| 1002 (4)      | Plumbing Fixtures                                                                                                                       | L.S.  | 1.00     |
| 1002 (24)     | Cold Water Lines                                                                                                                        | L.S.  | 1.00     |
| <b>1003</b>   | <b>Carpentry and Joinery Works</b>                                                                                                      |       |          |
| 1003 (1) a1   | Ceiling 4.5mm Thk. Metal Frame Fiber Cement Board                                                                                       | Sq.M. | 67.00    |
| 1003 (11) a1  | Fascia Board 19mm thk. Fiber Cement Board                                                                                               | M.    | 33.60    |
| 1003 (17)     | Carpentry and Joinery Works                                                                                                             | L.S.  | 1.00     |
| <b>1004</b>   | <b>Hardware</b>                                                                                                                         |       |          |
| 1004 (2)      | Finishing Hardware                                                                                                                      | L.S.  | 1.00     |
| <b>1008</b>   | <b>Aluminum Glass Windows</b>                                                                                                           |       |          |
| 1008 (1) a    | Aluminum Glass Windows, Sliding Type                                                                                                    | Sq.M. | 7.65     |

| Item No.      | Description                                                                                                     | Unit   | Quantity |
|---------------|-----------------------------------------------------------------------------------------------------------------|--------|----------|
| 1008 (1) c    | Aluminum Glass Windows, Awning Type                                                                             | Sq.M.  | 1.56     |
| <b>1013</b>   | <b>Corrugated Metal Roofing</b>                                                                                 |        |          |
| 1013 (2) b    | Fabricated Metal Roofing Accessory, Ga 26 (0.551mm) Flashings                                                   | Ln. m. | 18.00    |
| 1013 (2) c    | Fabricated Metal Roofing Accessory, Ga 24 (0.701mm) Gutters                                                     | Ln. m. | 41.00    |
| 1013 (4)      | Roof Ventilators                                                                                                | Each   | 3.00     |
| <b>1018</b>   | <b>Ceramic/Granite Tiles</b>                                                                                    |        |          |
| 1018 (1)      | Glazed Tile and Trims                                                                                           | Sq.M.  | 64.87    |
| 1018 (2)      | Unglazed Tiles                                                                                                  | Sq.M.  | 3.22     |
| 1018 (3)      | Granite Tiles                                                                                                   | Sq.M.  | 2.88     |
| <b>1027</b>   | <b>Cement Plaster Finish</b>                                                                                    |        |          |
| 1027 (1)      | Cement Plaster Finish                                                                                           | Sq.M.  | 112.00   |
| <b>1032</b>   | <b>Painting, Varnishing and other Related Works</b>                                                             |        |          |
| 1032 (1) a    | Painting Works Masonry/Concrete                                                                                 | Sq.M.  | 399.91   |
| 1032 (1) b    | Painting Works, Wood                                                                                            | Sq.M.  | 90.00    |
| 1032 (1) c    | Painting Works, Steel                                                                                           | Sq.M.  | 108.57   |
| <b>1043</b>   | <b>PVC Doors and Frames</b>                                                                                     |        |          |
| 1043 (1)      | PVC Doors and Frames                                                                                            | Sq.M.  | 1.26     |
| <b>1046</b>   | <b>Masonry Works</b>                                                                                            |        |          |
| 1046 (2) a1   | CHB Non Load Bearing (Including Reinforcing Steel), 100 mm                                                      | Sq.M.  | 14.40    |
| 1046 (2) a2   | CHB Non Load Bearing (Including Reinforcing Steel), 150 mm                                                      | Sq.M.  | 44.73    |
|               | <b>Metal Structures</b>                                                                                         |        |          |
| 1047 (8) a    | Structural Steel Trusses                                                                                        | Kg.    | 261.62   |
| <b>PART F</b> | <b>ELECTRICAL - DPWH Standard Specification for Public Works Structures (Vol. III), Division II - Buildings</b> |        |          |
| 1100 (10)     | Conduits, Boxes and Fittings, (Conduit Works/Conduit Rough-in)                                                  | L.S.   | 1.00     |
| 1101 (33)     | Wires and Wiring Devices                                                                                        | L.S.   | 1.00     |
| 1102 (1)      | Panelboard with Main & Branch Breakers                                                                          | L.S.   | 1.00     |
| 1103 (1)      | Lighting Fixtures                                                                                               | L.S.   | 1.00     |
| 1109 (1)      | Grounding System                                                                                                | L.S.   | 1.00     |
| <b>PART G</b> | <b>MECHANICAL - DPWH Standard Specification for Public Works Structures (Vol. III), Division II - Buildings</b> |        |          |
| <b>1200</b>   | <b>Air Conditioning and Ventilation System</b>                                                                  |        |          |
| 1200 (13) a   | Air Conditioning System, Package/Split Type                                                                     | L.S.   | 1.00     |



Republic of the Philippines  
DEPARTMENT OF PUBLIC WORKS AND HIGHWAYS  
REGIONAL OFFICE NO. VIII  
GOVERNMENT CENTER, BARAS, PALO, LEYTE

PROJECT TITLE:  
REPAIR/MAINTENANCE/IMPROVEMENT OF  
DPWH BUILDING,  
TECHNICAL WORKING GROUP (TWG) BUILDING  
LOCATION: DPWH REGIONAL OFFICE VII, BARAS, PALO, LEYTE

SHEET CONTENTS:  
SUMMARY OF QUANTITIES


PREPARED:  
NOEL B. BALINA  
ARCHITECT-II  
DATE

SUBMITTED:  
LUCAS N. BACSAI  
CHIEF, MAINTENANCE DIVISION  
DATE

RECOMMENDED FOR APPROVAL:  
MA. MARGARITA C. JUNIA, D.M.  
ASSISTANT REGIONAL DIRECTOR  
DATE

APPROVED:  
EDGAR B. TABACON, CESO-IV  
REGIONAL DIRECTOR  
DATE

SET NO. 3  
SHEET NO. 34

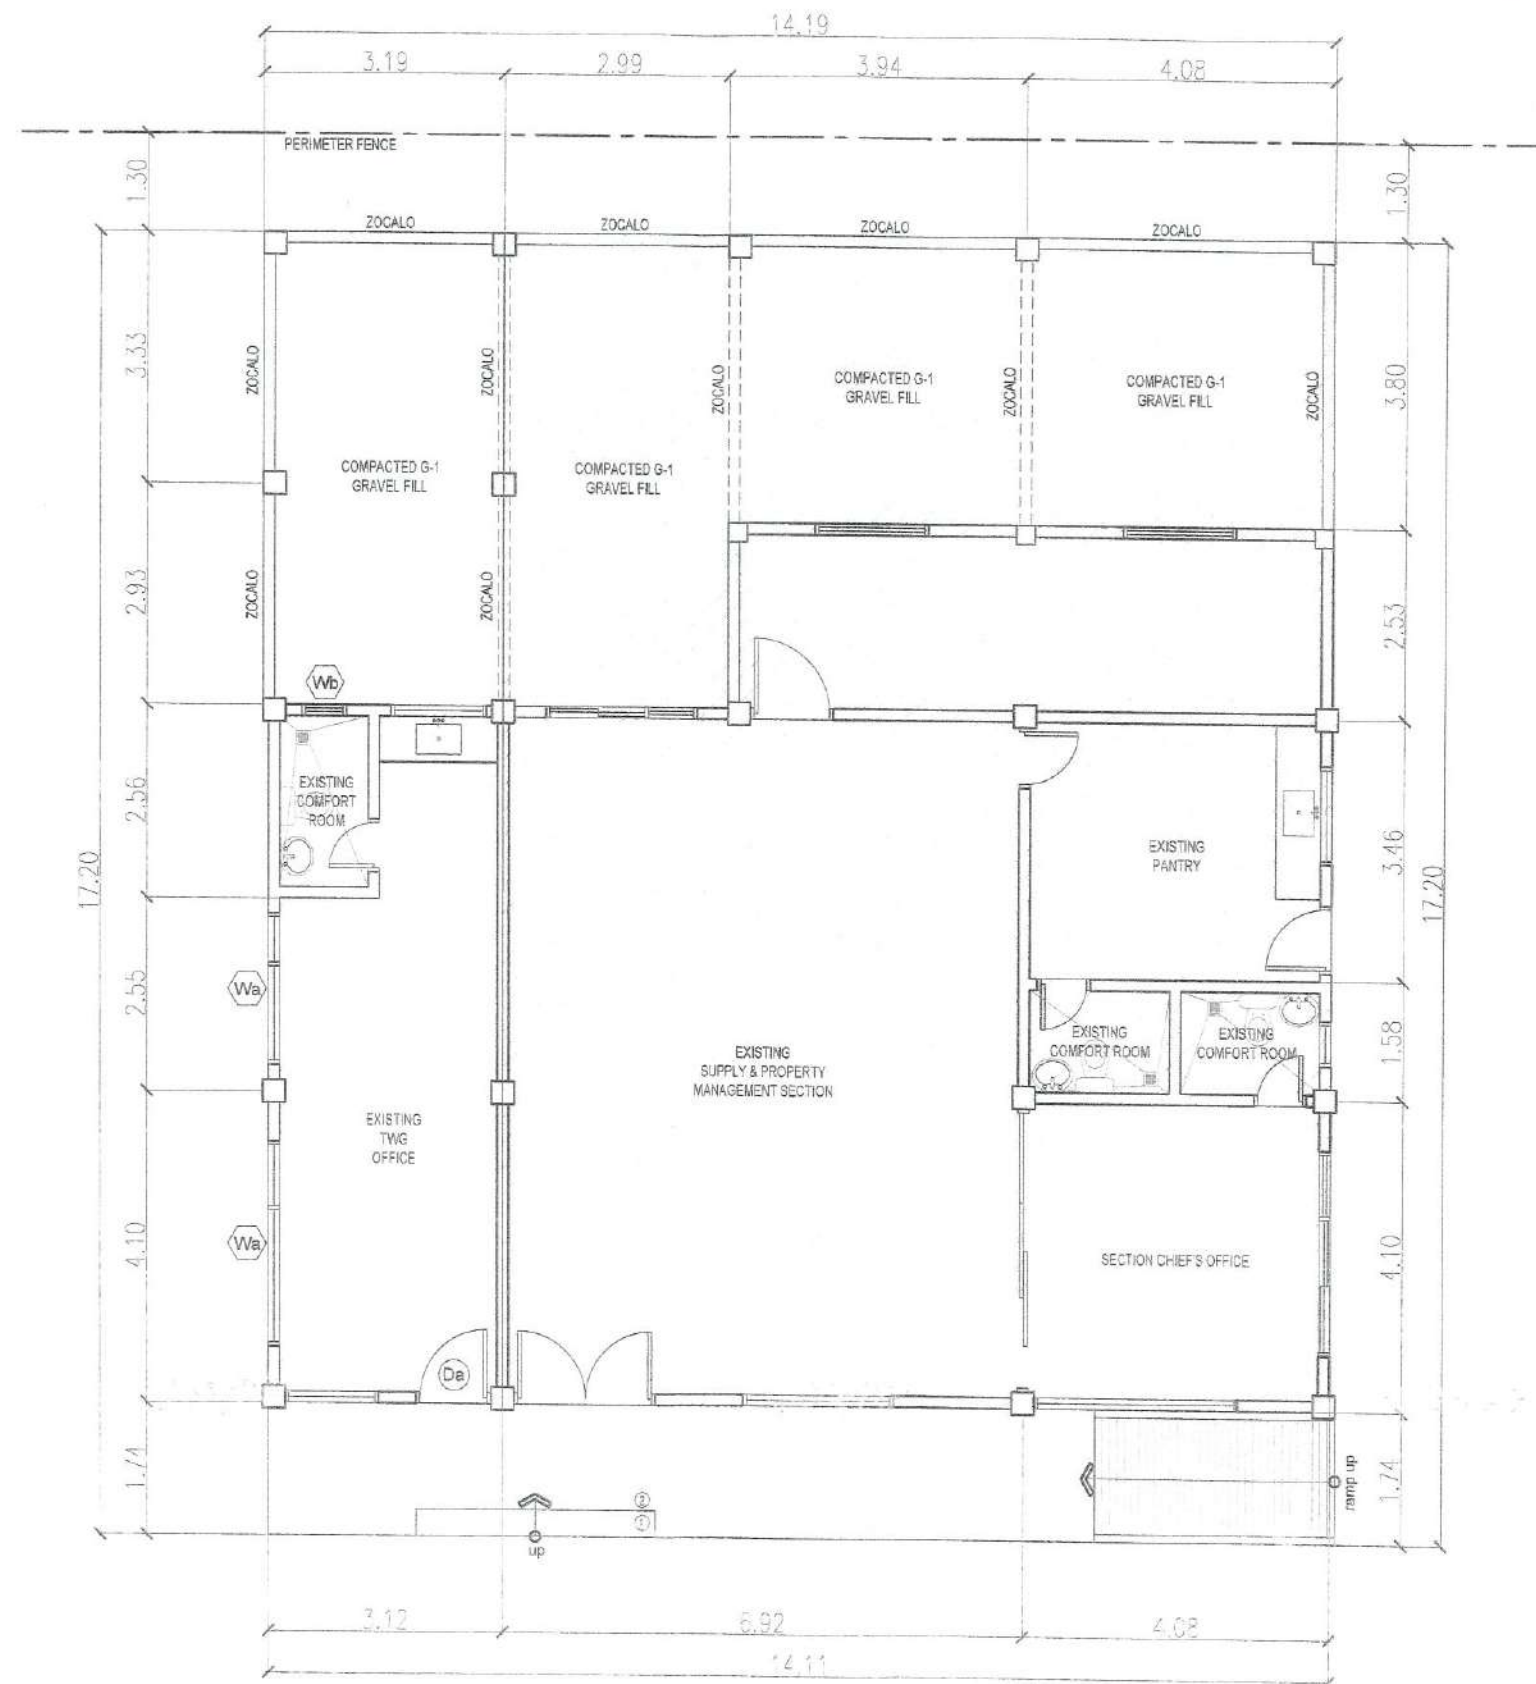

**1 EXISTING GROUND FLOOR PLAN**  
A - 1 SCALE: 1:100 MTS.

LEGEND:  
[Hatched Box] - NOT PART OF SCOPE OF WORK



Republic of the Philippines  
DEPARTMENT OF PUBLIC WORKS AND HIGHWAYS  
REGIONAL OFFICE NO. VIII  
GOVERNMENT CENTER, BARAS, PALO LEYTE

PROJECT TITLE:  
**REPAIR/MAINTENANCE/IMPROVEMENT OF  
DPWH BUILDING,  
TECHNICAL WORKING GROUP (TWG) BUILDING**  
LOCATION: DPWH REGIONAL OFFICE VIII, BARAS, PALO LEYTE

SHEET CONTENTS:  
**EXISTING GROUND FLOOR PLAN**


PREPARED:  
**NOEL B. BALINA**  
ARCHITECT - II  
DATE: \_\_\_\_\_

SUBMITTED:  
**LUCAS N. BACSAI**  
CHIEF, MAINTENANCE DIVISION  
DATE: \_\_\_\_\_

RECOMMENDED FOR APPROVAL:  
**MA. MARGARITA C. JUNIA, D.M.**  
ASSISTANT REGIONAL DIRECTOR  
DATE: \_\_\_\_\_

APPROVED:  
**EDGAR B. TABACON, CESO IV**  
REGIONAL DIRECTOR  
DATE: \_\_\_\_\_


SET NO. SHEET NO.  
A 4  
1 17 34

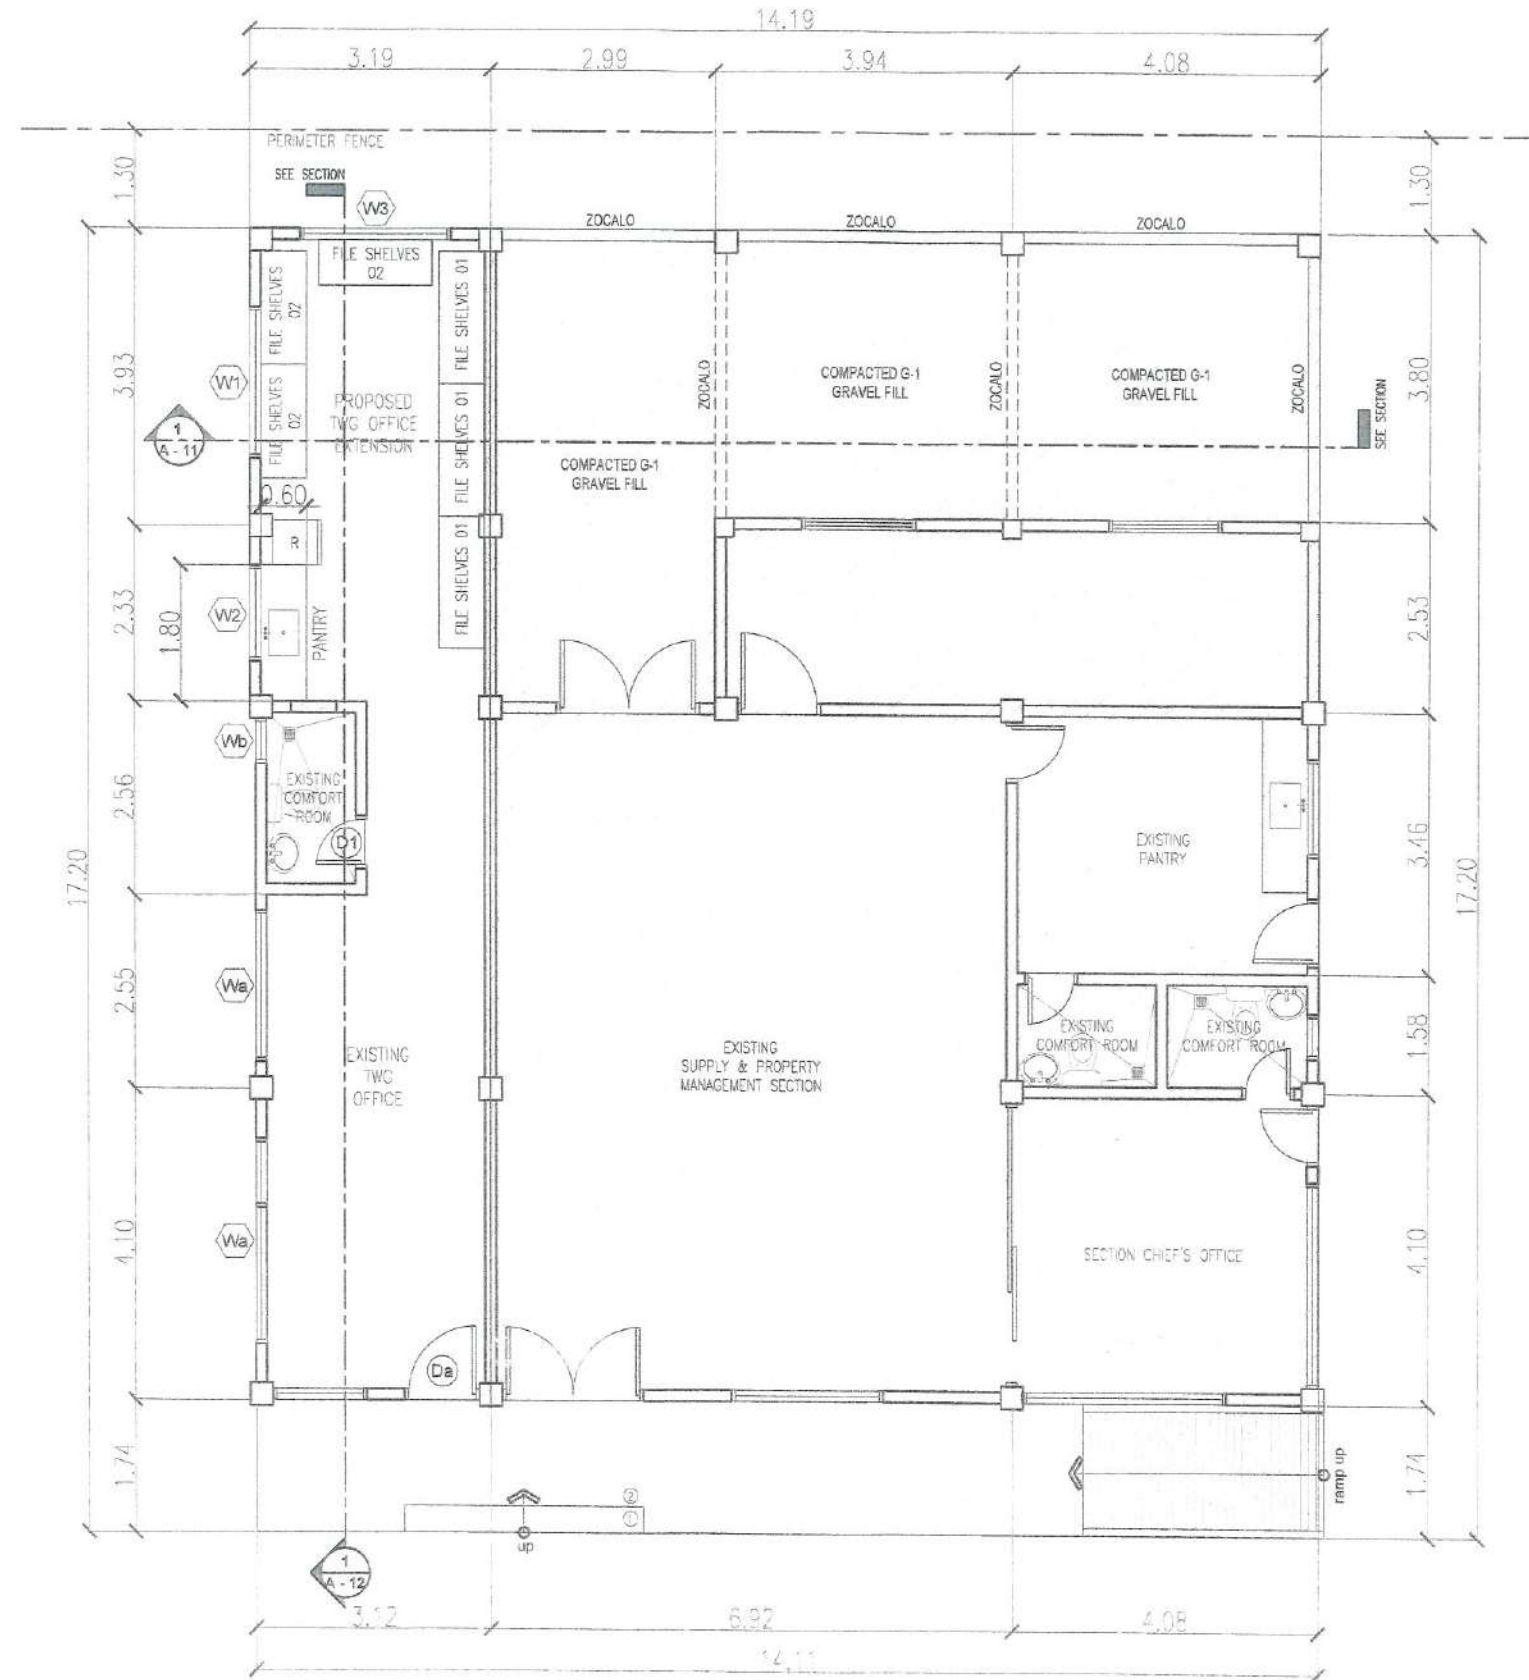

**1 PROPOSED GROUND FLOOR PLAN**  
A - 2 SCALE: 1:100 MTS.

LEGEND:  
 - PROPOSED CHE WALL  
 - NOT PART OF SCOPE OF WORK

|                                                                                                                                                                                                                                              |                                                                                               |                            |                                                                                                                           |                                                                                                                                         |                                                                                                                                                      |                                                                                                                                         |                                                                            |           |   |   |    |  |
|----------------------------------------------------------------------------------------------------------------------------------------------------------------------------------------------------------------------------------------------|-----------------------------------------------------------------------------------------------|----------------------------|---------------------------------------------------------------------------------------------------------------------------|-----------------------------------------------------------------------------------------------------------------------------------------|------------------------------------------------------------------------------------------------------------------------------------------------------|-----------------------------------------------------------------------------------------------------------------------------------------|----------------------------------------------------------------------------|-----------|---|---|----|--|
|  <div>Republic of the Philippines<br/>DEPARTMENT OF PUBLIC WORKS AND HIGHWAYS<br/>REGIONAL OFFICE NO. VIII<br/>GOVERNMENT CENTER, BARAS, PALO LEYTE</div> | PROJECT TITLE:                                                                                | SHEET CONTENTS:            | PREPARED:                                                                                                                 | SUBMITTED:                                                                                                                              | RECOMMENDED FOR APPROVAL:                                                                                                                            | APPROVED:                                                                                                                               | SET NO.                                                                    | SHEET NO. |   |   |    |  |
|                                                                                                                                                                                                                                              | REPAIR/MAINTENANCE/IMPROVEMENT OF<br>DPWH BUILDING,<br>TECHNICAL WORKING GROUP (TWG) BUILDING | PROPOSED GROUND FLOOR PLAN | <br>NOEL B. BALINA<br>ARCHITECT - II | <br>LUCAS N. BACSAL<br>CHIEF, MAINTENANCE DIVISION | <br>MA. MARGARITA C. JUNIA, D.M.<br>ASSISTANT REGIONAL DIRECTOR | <br>EDGAR S. TABACON, CESO IV<br>REGIONAL DIRECTOR | <table><tr><td>A</td><td>5</td></tr><tr><td>2</td><td>34</td></tr></table> | A         | 5 | 2 | 34 |  |
|                                                                                                                                                                                                                                              | A                                                                                             | 5                          |                                                                                                                           |                                                                                                                                         |                                                                                                                                                      |                                                                                                                                         |                                                                            |           |   |   |    |  |
| 2                                                                                                                                                                                                                                            | 34                                                                                            |                            |                                                                                                                           |                                                                                                                                         |                                                                                                                                                      |                                                                                                                                         |                                                                            |           |   |   |    |  |
| LOCATION: DPWH REGIONAL OFFICE VII, BARAS, PALO LEYTE                                                                                                                                                                                        |                                                                                               | DATE:                      | DATE:                                                                                                                     | DATE:                                                                                                                                   | DATE:                                                                                                                                                |                                                                                                                                         |                                                                            |           |   |   |    |  |

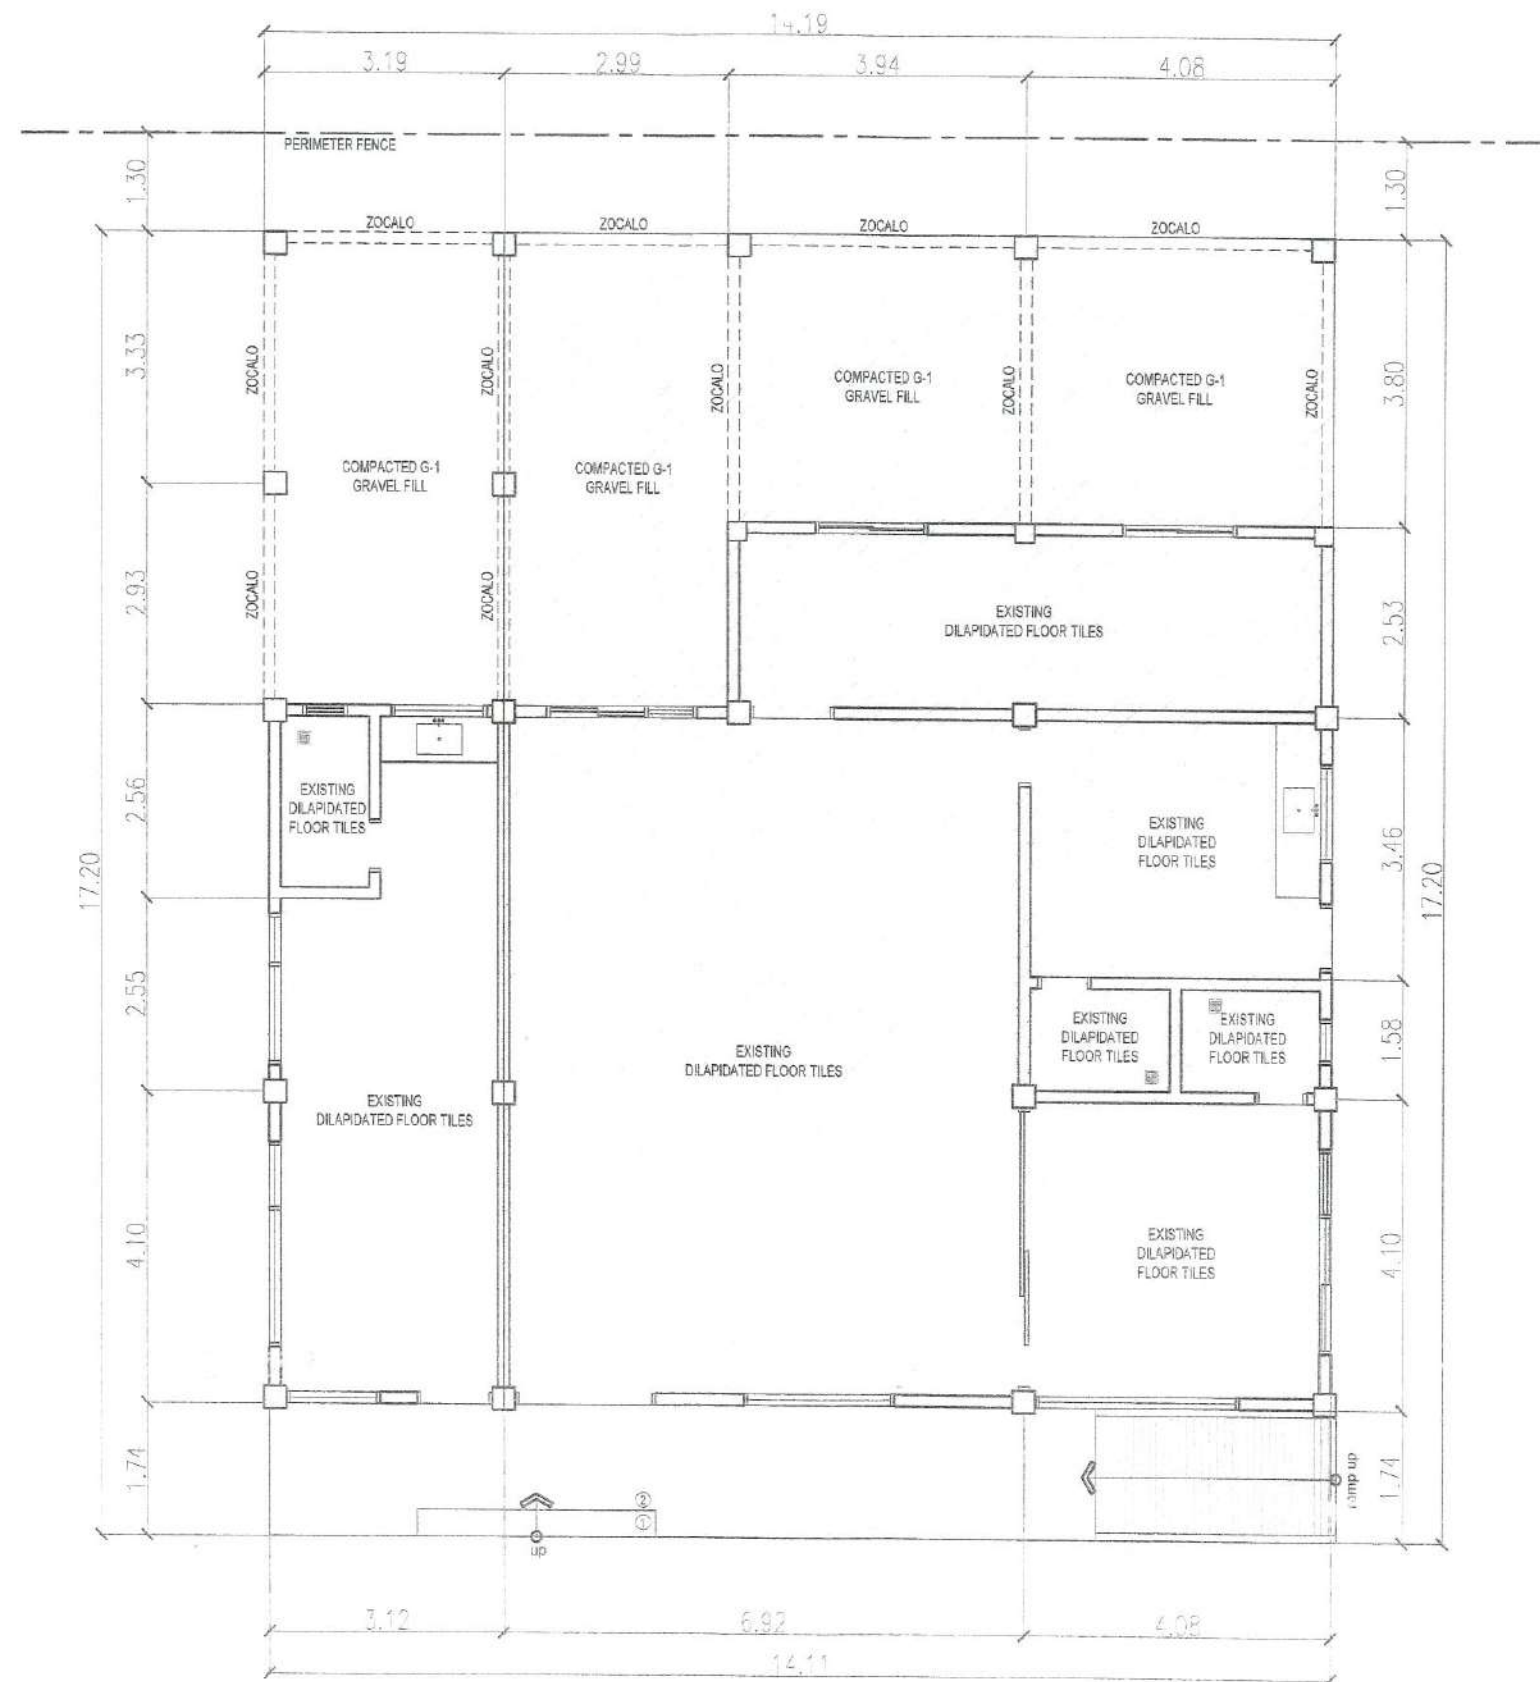

**1 EXISTING FLOOR FINISH PLAN**  
A - 3 SCALE: 1:100 MTS.



Republic of the Philippines  
DEPARTMENT OF PUBLIC WORKS AND HIGHWAYS  
REGIONAL OFFICE NO. VIII  
GOVERNMENT CENTER, BARAS, PALO LEYTE

PROJECT TITLE:

REPAIR/MAINTENANCE/IMPROVEMENT OF  
DPWH BUILDING,  
TECHNICAL WORKING GROUP (TWG) BUILDING

LOCATION: DPWH REGIONAL OFFICE VII, BARAS, PALO LEYTE

SHEET CONTENTS:

EXISTING FLOOR FINISH PLAN

PREPARED:

*ML*  
NOEL B. BALINA  
ARCHITECT-II

DATE

SUBMITTED:

*Lucas*  
LUCAS N. BACAL  
CHIEF MAINTENANCE DIVISION

DATE

RECOMMENDED FOR APPROVAL

*M. Margarita*  
MA. MARGARITA S. JUNIA, D.M.  
ASSISTANT REGIONAL DIRECTOR

DATE

APPROVED

*Edgar B. Tabacon*  
EDGAR B. TABACON, CESO IV  
REGIONAL DIRECTOR


DATE

SET NO

A  
3 17

SHEET NO

6  
34

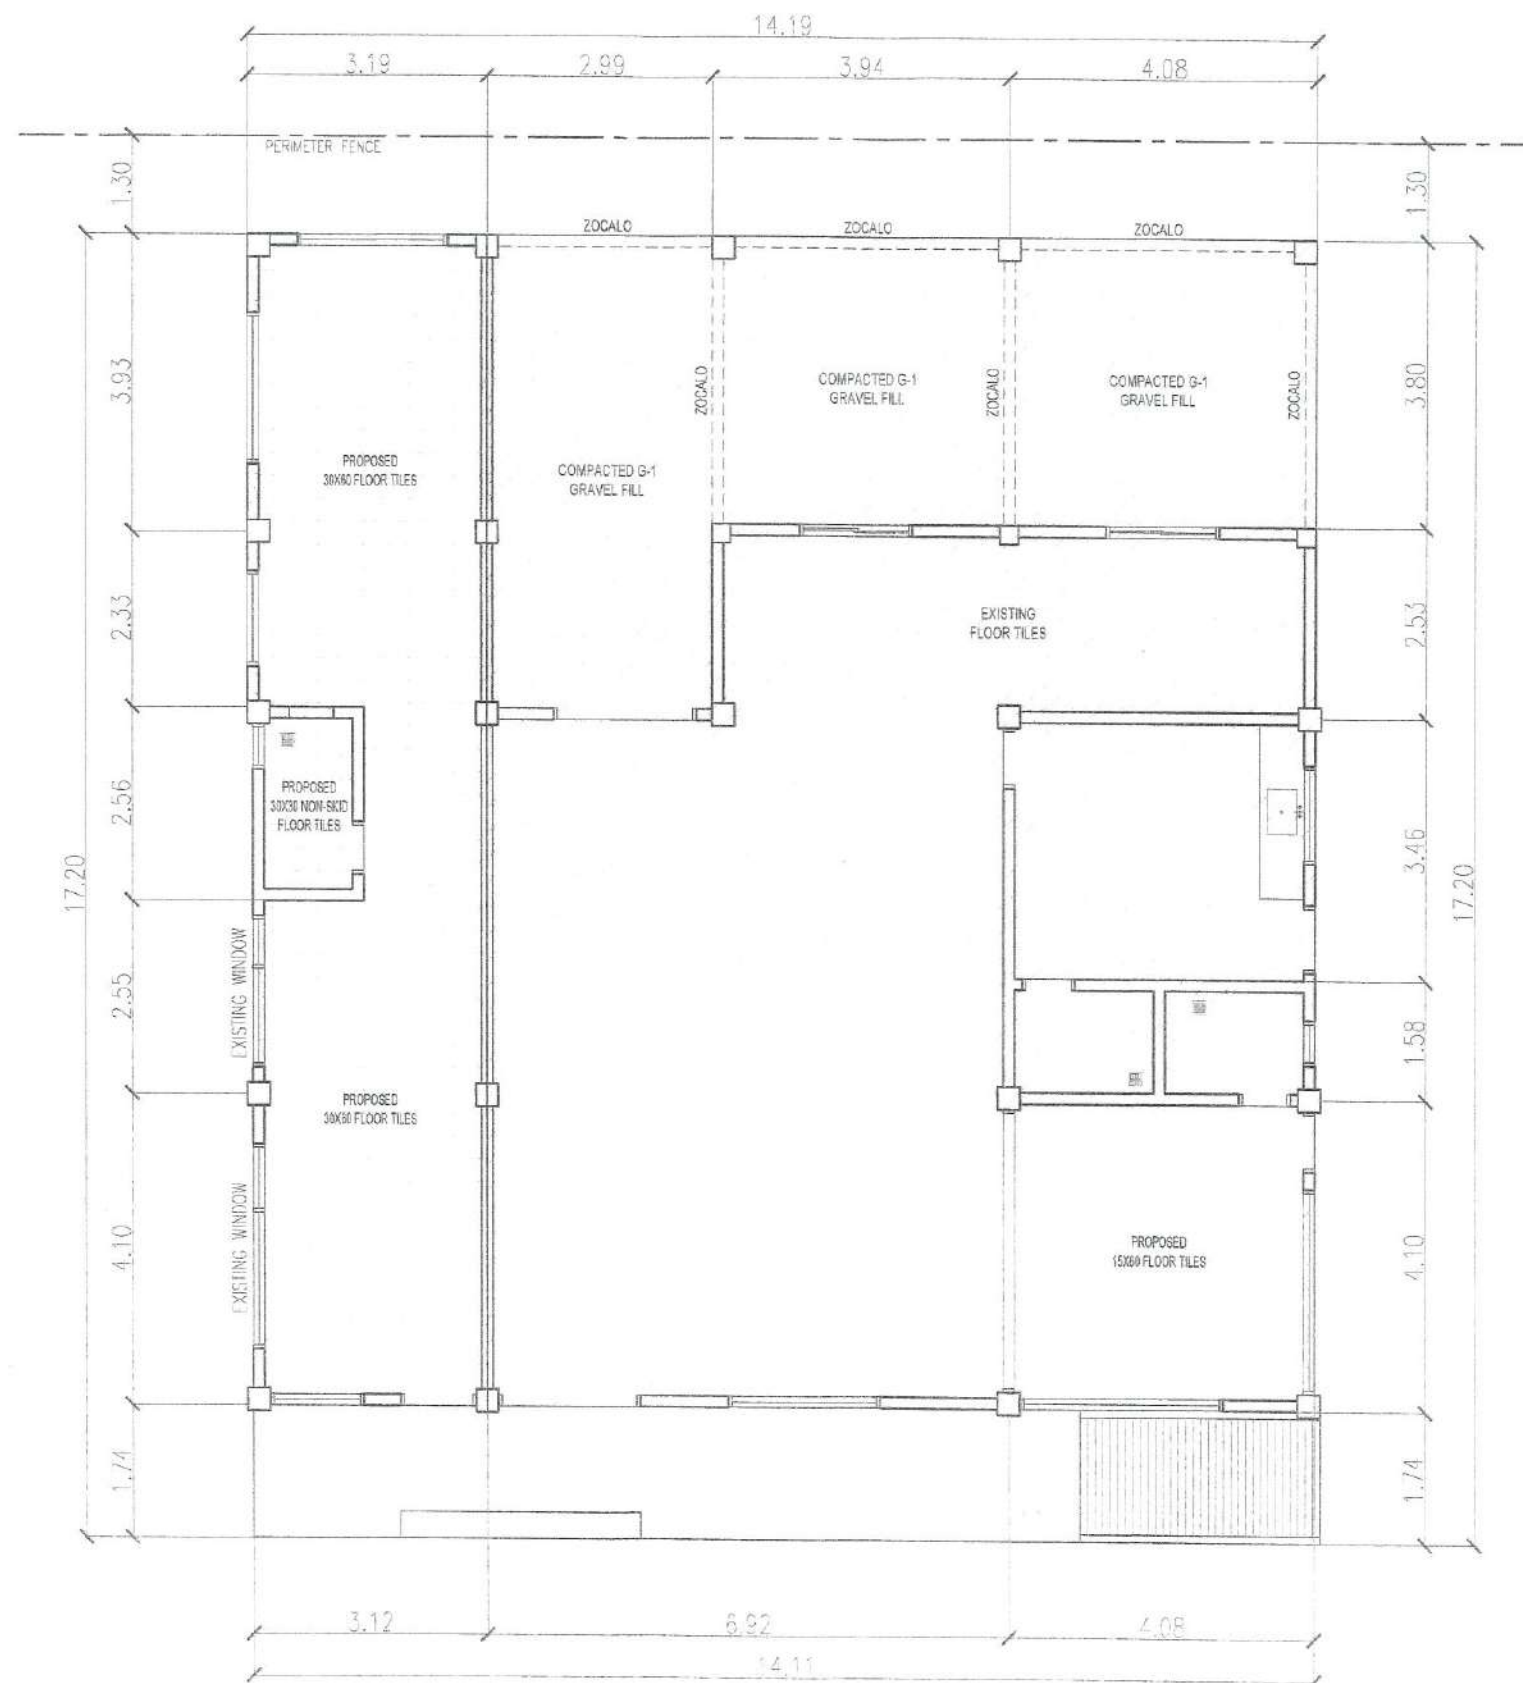

LEGEND:

- PROPOSED DHB WALL
- NOT PART OF SCOPE OF WORK

**1 PROPOSED GROUND FLOOR FINISH PLAN**  
A - 4 SCALE: 1:100 MTS.



Republic of the Philippines  
DEPARTMENT OF PUBLIC WORKS AND HIGHWAYS  
REGIONAL OFFICE NO. VIII  
GOVERNMENT CENTER, BARAS, PALO LEYTE

PROJECT TITLE:  
**REPAIR/MAINTENANCE/IMPROVEMENT OF  
DPWH BUILDING,  
TECHNICAL WORKING GROUP (TWG) BUILDING**  
LOCATION: DPWH REGIONAL OFFICE VII, BARAS, PALO LEYTE

SHEET CONTENTS:  
**PROPOSED GROUND FLOOR FINISH PLAN**


PREPARED:  
**NOEL B. BALINA**  
ARCHITECT - II  
DATE: *1/17/20*

SUBMITTED:  
**LUCAS N. BACSA**  
CHIEF MAINTENANCE DIVISION  
DATE: *1/17/20*

RECOMMENDED FOR APPROVAL:  
**MA. MARGARITA C. JUNIA, D.M.**  
ASSISTANT REGIONAL DIRECTOR  
DATE: *1/17/20*


APPROVED:  
**EDGAR B. TABACON, CESO IV**  
REGIONAL DIRECTOR  
DATE: *1/17/20*

SET NO. **A** SHEET NO. **7**  
4 17 34

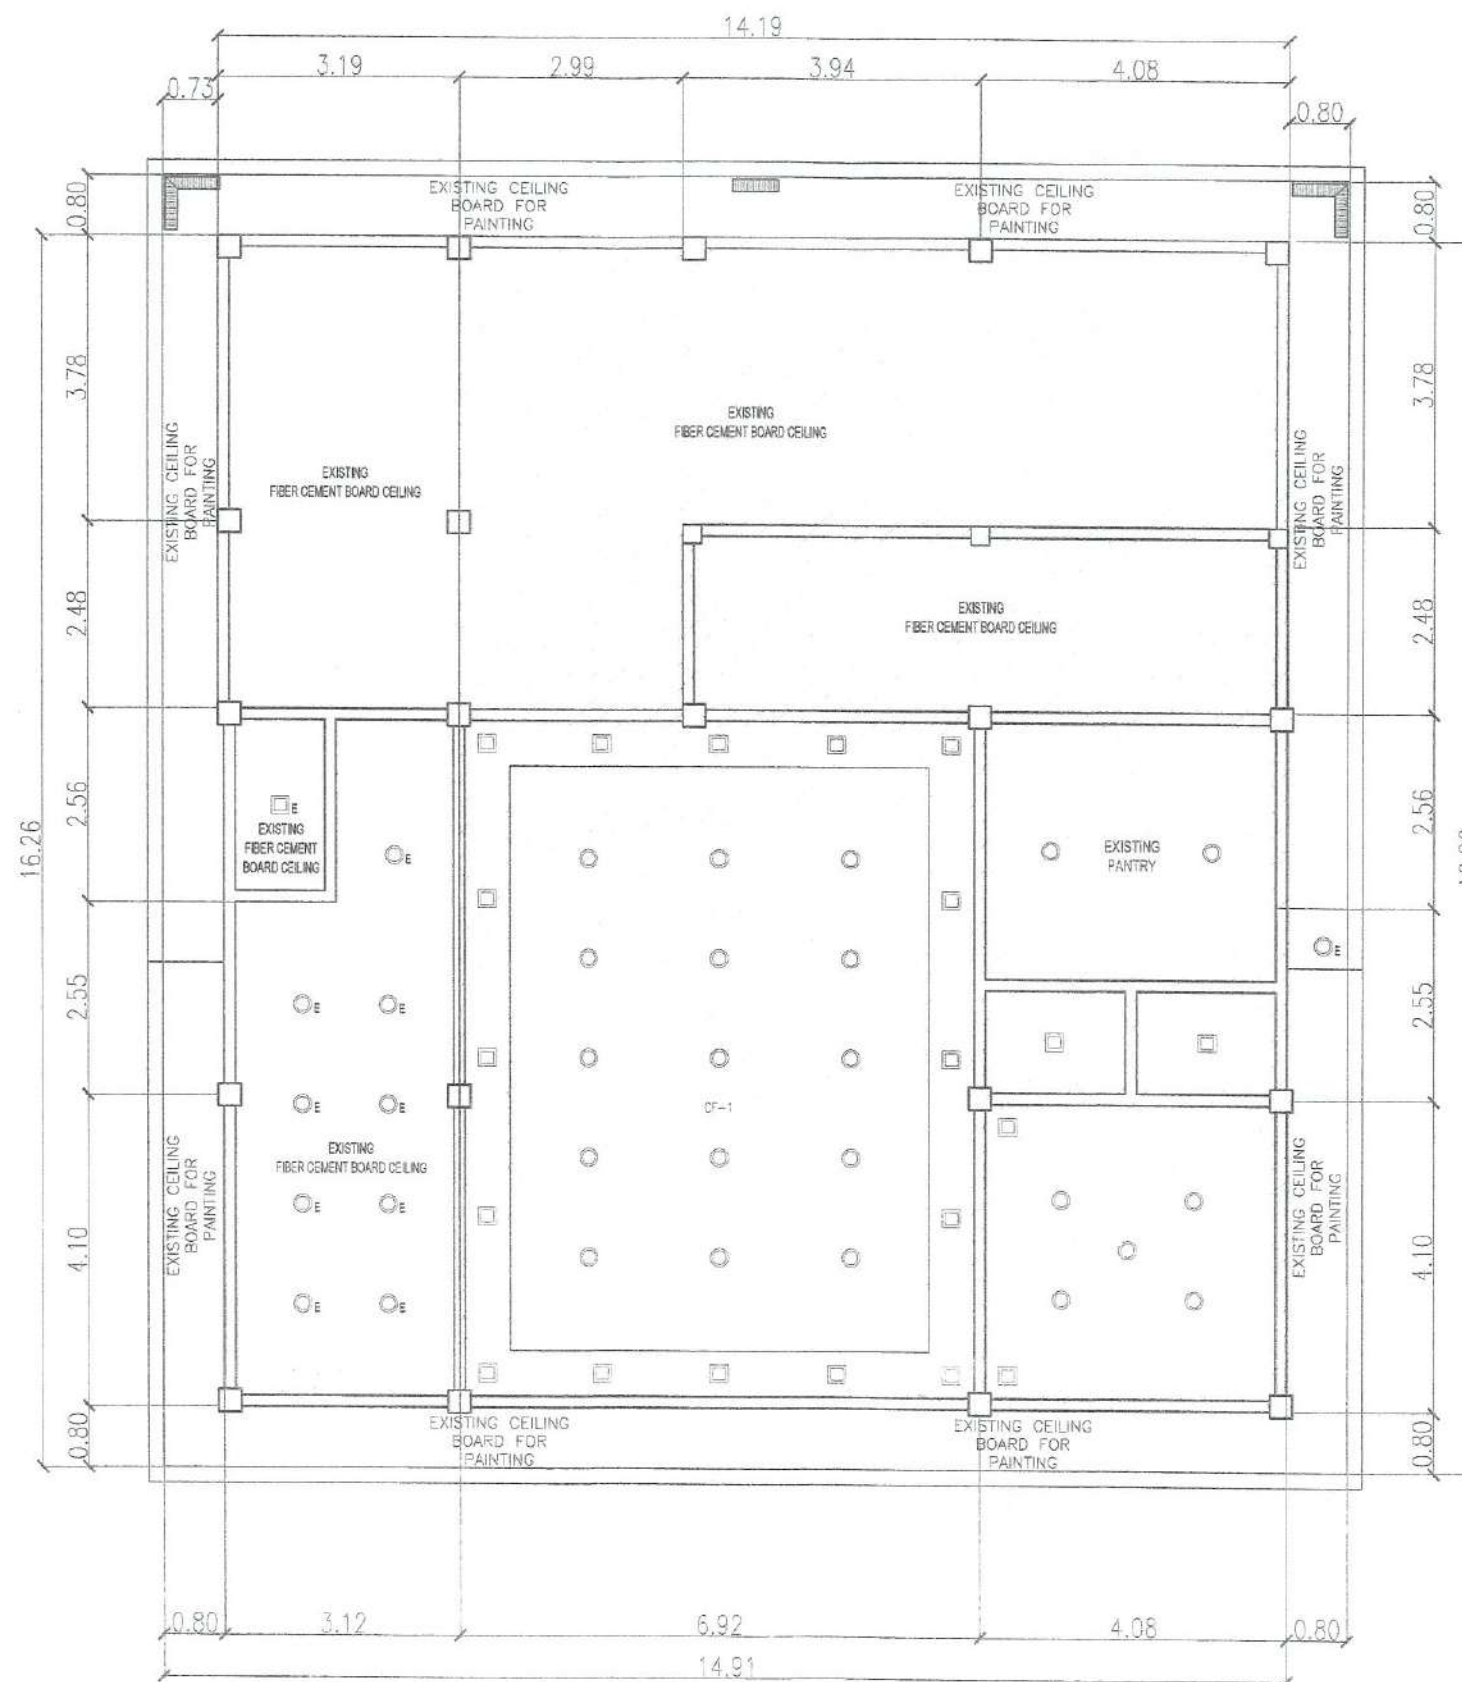


☐ - NOT PART OF SCOPE OF WORK

|                                                                                                                                                                                                                                          |                                                                                               |                                 |                                                                                                                                  |                                                                                                                                                |                                                                                                                                                             |                                                                                                                                                |                                                                                                                                                                                     |                                                                                                                                                                                      |
|------------------------------------------------------------------------------------------------------------------------------------------------------------------------------------------------------------------------------------------|-----------------------------------------------------------------------------------------------|---------------------------------|----------------------------------------------------------------------------------------------------------------------------------|------------------------------------------------------------------------------------------------------------------------------------------------|-------------------------------------------------------------------------------------------------------------------------------------------------------------|------------------------------------------------------------------------------------------------------------------------------------------------|-------------------------------------------------------------------------------------------------------------------------------------------------------------------------------------|--------------------------------------------------------------------------------------------------------------------------------------------------------------------------------------|
|  <p>Republic of the Philippines<br/>DEPARTMENT OF PUBLIC WORKS AND HIGHWAYS<br/>REGIONAL OFFICE NO. VIII<br/>GOVERNMENT CENTER, BARAS, PALO LEYTE</p> | PROJECT TITLE:                                                                                | SHEET CONTENTS:                 | PREPARED:                                                                                                                        | SUBMITTED:                                                                                                                                     | RECOMMENDED FOR APPROVAL:                                                                                                                                   | APPROVED:                                                                                                                                      | SET NO.                                                                                                                                                                             | SHEET NO.                                                                                                                                                                            |
|                                                                                                                                                                                                                                          | REPAIR/MAINTENANCE/IMPROVEMENT OF<br>DPWH BUILDING,<br>TECHNICAL WORKING GROUP (TWG) BUILDING | EXISTING REFLECTED CEILING PLAN | <br><b>NOEL B. BALINA</b><br>ARCHITECT - II | <br><b>LUCAS N. BAYSAL</b><br>CHIEF, MAINTENANCE DIVISION | <br><b>MA. MARGARITA C. JUNIA, D.M.</b><br>ASSISTANT REGIONAL DIRECTOR | <br><b>EDGAR B. TABACON, CESO-IV</b><br>REGIONAL DIRECTOR | <div style="border: 1px solid black; width: 40px; height: 40px; margin: 0 auto; display: flex; align-items: center; justify-content: center;">             A<br/>5           </div> | <div style="border: 1px solid black; width: 40px; height: 40px; margin: 0 auto; display: flex; align-items: center; justify-content: center;">             B<br/>34           </div> |
|                                                                                                                                                                                                                                          | LOCATION: DPWH REGIONAL OFFICE VIII BARAS, PALO LEYTE                                         |                                 | DATE: <u>11/11/2018</u>                                                                                                          | DATE: <u>11/11/2018</u>                                                                                                                        | DATE: <u>11/11/2018</u>                                                                                                                                     | DATE: <u>11/11/2018</u>                                                                                                                        |                                                                                                                                                                                     |                                                                                                                                                                                      |
|                                                                                                                                                                                                                                          |                                                                                               |                                 |                                                                                                                                  |                                                                                                                                                |                                                                                                                                                             |                                                                                                                                                |                                                                                                                                                                                     |                                                                                                                                                                                      |

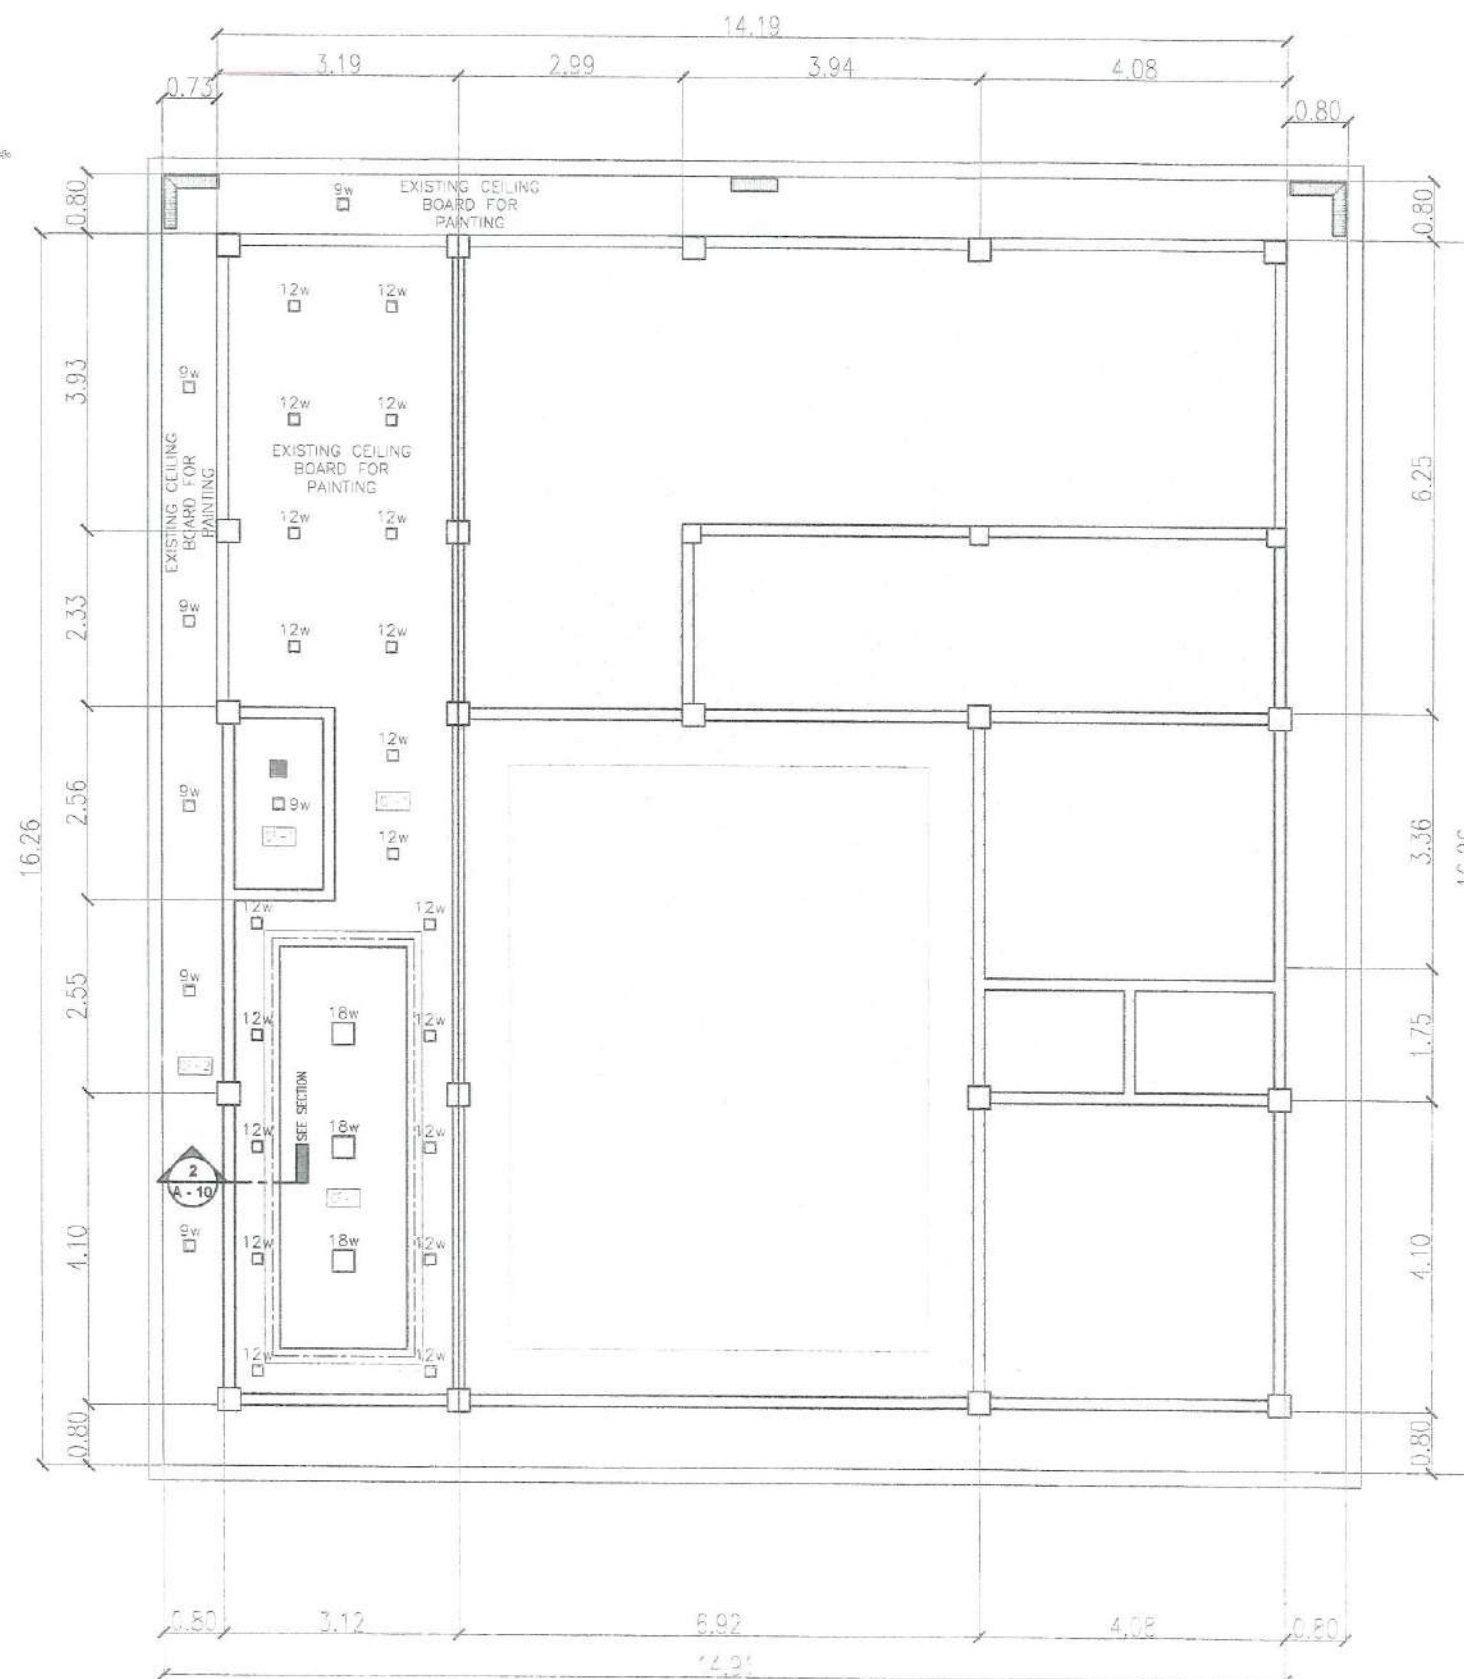

**1 PROPOSED REFLECTED CEILING PLAN**  
A - 6 SCALE: 1:100 MTS.

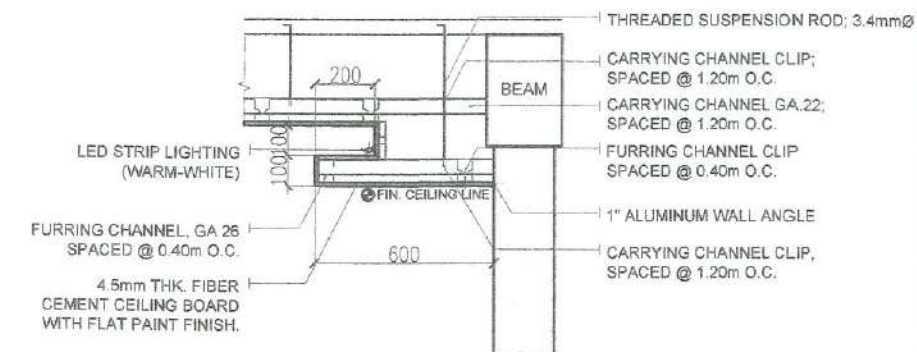

**1 CEILING SECTION DETAILS**  
A - 6 SCALE: 1:100 MTS.

| LEGEND            |                                                                                                                   |
|-------------------|-------------------------------------------------------------------------------------------------------------------|
| LIGHTING FIXTURES |                                                                                                                   |
|                   | RECESSED SQUARE LED PANEL LIGHT (24" x 24")                                                                       |
|                   | RECESSED RECT. LED PANEL LIGHT (24" x 12")                                                                        |
| CEILING FINISHES  |                                                                                                                   |
|                   | 4.5mm THK. HARDIFLEX LITE WITH METAL DOUBLE FURRING CHANNEL (NAILER) 12mm X 38mm X 5m X 0.80 mm THK @ 400 mm O.C. |
|                   | EXISTING 12mm THK. FIBER CEMENT BOARD CEILING WITH LIGHT-GAUGE FRAMES. REPAINT WITH LATEX PAINT                   |
| CEILING FIXTURES  |                                                                                                                   |
|                   | NEW STRAIGHT TYPE PRE-FABRICATED AIR VENT 300mm X 1200mm                                                          |
|                   | EXISTING L-TYPE PRE-FABRICATED AIR VENT 300mm X 1200mm                                                            |





Republic of the Philippines  
DEPARTMENT OF PUBLIC WORKS AND HIGHWAYS  
REGIONAL OFFICE NO. VIII  
GOVERNMENT CENTER, BARAS, PALO LEYTE

| PROJECT TITLE:                                                                                | SHEET CONTENTS:                 | PREPARED:                        | SUBMITTED:                                    | RECOMMENDED FOR APPROVAL:                                   | APPROVED:                                      | SET NO.   | SHEET NO. |
|-----------------------------------------------------------------------------------------------|---------------------------------|----------------------------------|-----------------------------------------------|-------------------------------------------------------------|------------------------------------------------|-----------|-----------|
| REPAIR/MAINTENANCE/IMPROVEMENT OF<br>DPWH BUILDING,<br>TECHNICAL WORKING GROUP (TWG) BUILDING | PROPOSED REFLECTED CEILING PLAN | NOEL S. BALINA<br>ARCHITECT - II | LUCAS N. BACSA<br>CHIEF, MAINTENANCE DIVISION | MA. MARGARITA C. JUNIA, D.M.<br>ASSISTANT REGIONAL DIRECTOR | EDGAR B. TABACON, CESO IV<br>REGIONAL DIRECTOR | A<br>E 17 | 9<br>34   |
| LOCATION: DPWH REGIONAL OFFICE VIII, BARAS, PALO LEYTE                                        |                                 | DATE:                            | DATE:                                         | DATE:                                                       | DATE:                                          |           |           |





 **1 FRONT ELEVATION**  
**A - 7** SCALE: 1:100 MTS.

|                                                                                                                                                                                                                                          |                                                                                               |                 |                                                                                                                           |                                                                                                                                         |                                                                                                                                                      |                                                                                                                                         |                                                                                        |           |    |   |    |  |
|------------------------------------------------------------------------------------------------------------------------------------------------------------------------------------------------------------------------------------------|-----------------------------------------------------------------------------------------------|-----------------|---------------------------------------------------------------------------------------------------------------------------|-----------------------------------------------------------------------------------------------------------------------------------------|------------------------------------------------------------------------------------------------------------------------------------------------------|-----------------------------------------------------------------------------------------------------------------------------------------|----------------------------------------------------------------------------------------|-----------|----|---|----|--|
|  <p>Republic of the Philippines<br/>DEPARTMENT OF PUBLIC WORKS AND HIGHWAYS<br/>REGIONAL OFFICE NO. VIII<br/>GOVERNMENT CENTER, BARAS, PALO LEYTE</p> | PROJECT TITLE:                                                                                | SHEET CONTENTS: | PREPARED:                                                                                                                 | SUBMITTED:                                                                                                                              | RECOMMENDED FOR APPROVAL:                                                                                                                            | APPROVED:                                                                                                                               | SET NO.                                                                                | SHEET NO. |    |   |    |  |
|                                                                                                                                                                                                                                          | REPAIR/MAINTENANCE/IMPROVEMENT OF<br>DPWH BUILDING,<br>TECHNICAL WORKING GROUP (TWG) BUILDING | FRONT ELEVATION | <br>NOEL B. BALINA<br>ARCHITECT - II | <br>LUCAS N. BACSAL<br>CHIEF, MAINTENANCE DIVISION | <br>MA. MARGARITA E. JUNIA, D.M.<br>ASSISTANT REGIONAL DIRECTOR | <br>EDGAR B. TABACON, CESO IV<br>REGIONAL DIRECTOR | <table border="1"><tr><td>A</td><td>10</td></tr><tr><td>7</td><td>34</td></tr></table> | A         | 10 | 7 | 34 |  |
|                                                                                                                                                                                                                                          | A                                                                                             | 10              |                                                                                                                           |                                                                                                                                         |                                                                                                                                                      |                                                                                                                                         |                                                                                        |           |    |   |    |  |
| 7                                                                                                                                                                                                                                        | 34                                                                                            |                 |                                                                                                                           |                                                                                                                                         |                                                                                                                                                      |                                                                                                                                         |                                                                                        |           |    |   |    |  |
| LOCATION: DPWH REGIONAL OFFICE VIII BARAS, PALO LEYTE                                                                                                                                                                                    |                                                                                               | DATE:           | DATE:                                                                                                                     | DATE:                                                                                                                                   | DATE:                                                                                                                                                | DATE:                                                                                                                                   |                                                                                        |           |    |   |    |  |

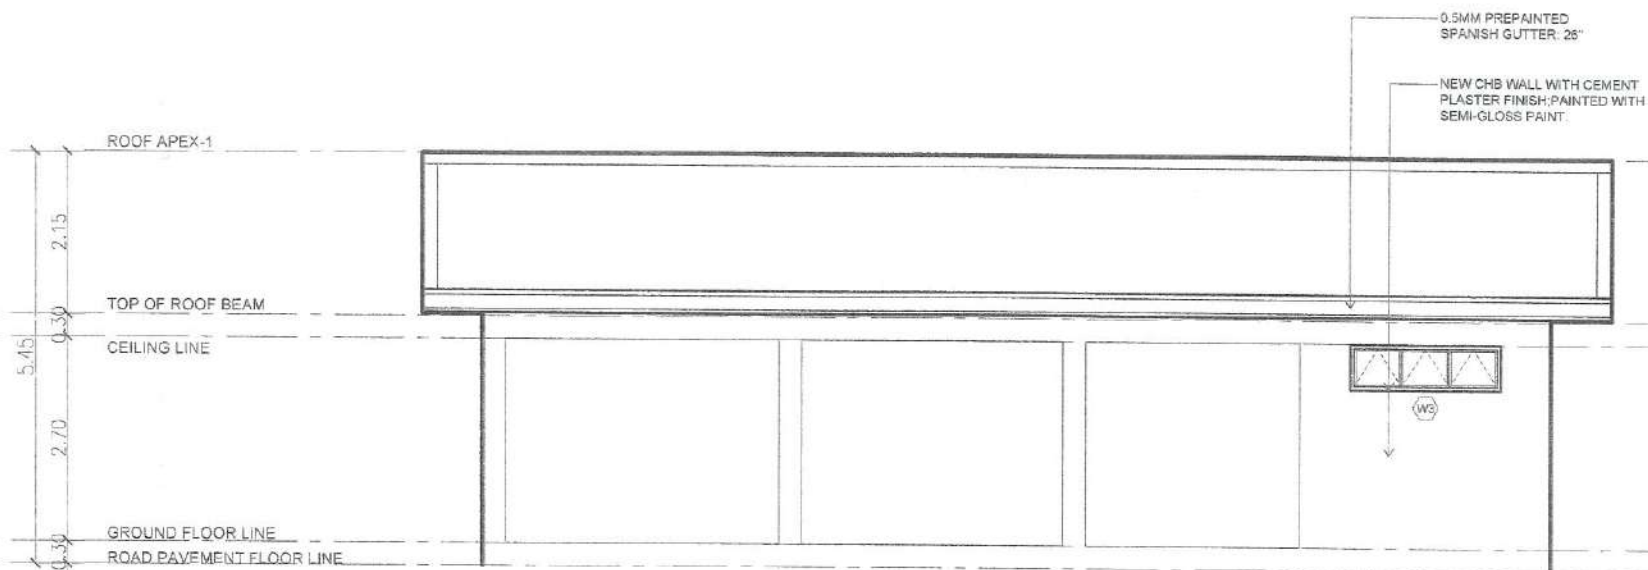

  1 REAR ELEVATION  
A - 8 SCALE: 1:100 MTS.

|                                                                                                                                                                                                                                          |                                                                                               |                 |                                                                                                                                         |                                                                                                                                                        |                                                                                                                                                                      |                                                                                                                                                         |             |           |
|------------------------------------------------------------------------------------------------------------------------------------------------------------------------------------------------------------------------------------------|-----------------------------------------------------------------------------------------------|-----------------|-----------------------------------------------------------------------------------------------------------------------------------------|--------------------------------------------------------------------------------------------------------------------------------------------------------|----------------------------------------------------------------------------------------------------------------------------------------------------------------------|---------------------------------------------------------------------------------------------------------------------------------------------------------|-------------|-----------|
|  <p>Republic of the Philippines<br/>DEPARTMENT OF PUBLIC WORKS AND HIGHWAYS<br/>REGIONAL OFFICE NO. VIII<br/>GOVERNMENT CENTER, BARAS, PALO LEYTE</p> | PROJECT TITLE:                                                                                | SHEET CONTENTS: | PREPARED:                                                                                                                               | SUBMITTED:                                                                                                                                             | RECOMMENDED FOR APPROVAL:                                                                                                                                            | APPROVED:                                                                                                                                               | SET NO.     | SHEET NO. |
|                                                                                                                                                                                                                                          | REPAIR/MAINTENANCE/IMPROVEMENT OF<br>DPWH BUILDING,<br>TECHNICAL WORKING GROUP (TWG) BUILDING | REAR ELEVATION  | <br><b>NOEL B. BALINA</b><br>ARCHITECT-II<br>DATE: | <br><b>LUCAS N. BACSI</b><br>CHIEF, MAINTENANCE DIVISION<br>DATE: | <br><b>MA. MARGARITA C. JUNIA, D.M.</b><br>ASSISTANT REGIONAL DIRECTOR<br>DATE: | <br><b>EDGAR B. TABACON, CESO IV</b><br>REGIONAL DIRECTOR<br>DATE: | A<br>6   17 | 11<br>34  |
|                                                                                                                                                                                                                                          | LOCATION: DPWH REGIONAL OFFICE VII, BARAS, PALO LEYTE                                         |                 |                                                                                                                                         |                                                                                                                                                        |                                                                                                                                                                      |                                                                                                                                                         |             |           |