


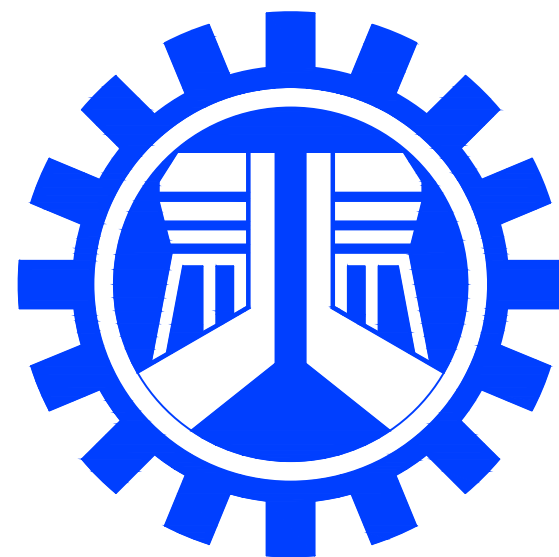

REPUBLIC OF THE PHILIPPINES
DEPARTMENT OF PUBLIC WORKS AND HIGHWAYS
REGIONAL OFFICE No. IV-A
BATANGAS 2ND DISTRICT ENGINEERING OFFICE
BATANGAS CITY

C.Y. 2025 PROJECT
DETAILED ARCHITECTURAL AND ENGINEERING DESIGN

CONVERGENCE AND SPECIAL SUPPORT PROGRAM,
BASIC INFRASTRUCTURE PROGRAM (BIP),
MULTI-PURPOSE BUILDINGS/FACILITIES TO SUPPORT SOCIAL SERVICES,
CONSTRUCTION OF MULTI-PURPOSE BUILDING
(TINGLOY MUNICIPAL TOURISM AND CULTURAL ARTS BUILDING) ,
AT TINGLOY, BATANGAS

LATITUDE = 13.661778
LONGITUDE = 120.874028

CHECKED & REVIEWED BY:

RECOMMENDING APPROVAL :

APPROVED :

GEMMA L. OLAN
CHIEF, PLANNING & DESIGN SECTION

ARIEL V. ARMEDILLA
ASSISTANT DISTRICT ENGINEER

SONIA D. PAGLICAUAN
DISTRICT ENGINEER

SUMMARY OF QUANTITIES

ITEM NO.	DESCRIPTION	QTY	UNIT	REMARKS
PART A	FACILITIES FOR THE ENGINEER			
A.1.1 (8)	Provision of Field Office for the Engineer (Rental Basis)	9.10	Month	
A.1.4 (1)	Provision of Progress Photographs	9.10	Month	
PART B	OTHER GENERAL REQUIREMENTS			
B.3 (1)	Permits and Clearances	1.00	Lump Sum	
B.5 (1)	Project Billboard / Signboard	1.00	Each	1 "Each" Corresponds to a set of 1 DPWH & 1 COA Billboard
B.7 (1)	Occupational Safety and Health	1.00	Lump Sum	
B.9 (1)	Mobilization/Demobilization	1.00	Lump Sum	
PART C	EARTHWORK			
800 (1)	Clearing and Grubbing	800.00	sq.m.	
801 (1)	Removal of Structures and Obstruction	1.00	Lump Sum	
803 (1) a	Structure Excavation, Common Soil	289.98	cu.m.	
804 (1) a	Embankment from Roadway/Structure Excavation, Common Soil	217.48	cu.m.	
804 (2) a	Embankment from Borrow, Common Soil	30.15	cu.m.	
804 (7)	Gravel Fill	29.78	cu.m.	
PART D	REINFORCED CONCRETE			
900 (1) c	Structural Concrete, 3000 psi, Class A, 28 days	217.40	cu.m.	
902 (1) a1	Reinforcing Steel (Deformed), Grade 40	42,065.79	kg.	
903 (2)	Formworks and Falseworks	1,567.85	sq.m.	
PART E	FINISHING AND OTHER CIVIL WORKS			
1000 (1)	Soil Poisoning	197.77	Liter	
1001 (8)	Sewer Line Works	1.00	Lump Sum	
1001 (9)	Storm Drainage and Downspout	1.00	Lump Sum	
1002 (4)	Plumbing Fixtures	1.00	Lump Sum	
1002 (24)	Cold Water Lines	1.00	Lump Sum	
1003 (1) a1	Ceiling, 4.5 mm, Metal Frame, Fiber Cement Board	354.88	sq.m.	
1006 (5)	Fire Rated Fire Exit Steel Door	2.15	sq.m.	

ITEM NO.	DESCRIPTION	QTY	UNIT	REMARKS
1007 (1) a	Aluminum Framed Glass Door, Sliding Type	3.66	sq.m.	
1007 (1) b	Aluminum Framed Glass Door, Swing Type	12.46	sq.m.	
1008 (1) b	Aluminum Glass Windows, Casement Type	58.14	sq.m.	
1008 (1) c	Aluminum Glass Windows, Awning Type	25.65	sq.m.	
1008 (1) d	Aluminum Glass Windows, Fixed Type	49.80	sq.m.	
1010 (2) a	Doors, Flush	12.47	sq.m.	
1016 (1) a	Waterproofing, Cement-base	477.60	sq.m.	
1018 (1)	Glazed Tiles and Trims	322.65	sq.m.	
1018 (2)	Unglazed Tiles	74.12	sq.m.	
1027 (1)	Cement Plaster Finish	1,602.27	sq.m.	
1032 (1) a	Painting Works, Masonry/Concrete	1,805.79	sq.m.	
1046 (2) a2	CHB Non-Load Bearing (including Reinforcing Steel), 150 mm	790.01	sq.m.	
1051 (8)	Railing	1.00	Lump Sum	
PART F	ELECTRICAL			
1100 (10)	Conduits, Boxes & Fittings (Conduit Works/Conduit Rough-in)	1.00	Lump Sum	
1101 (33)	Wires and Wiring Devices	1.00	Lump Sum	
1102 (1)	Panelboard with Main & Branch Breakers	1.00	Lump Sum	
1103 (1)	Lighting Fixtures	1.00	Lump Sum	
1105 (20)	Network Cabling	1.00	Lump Sum	
1109 (1)	Grounding System	1.00	Lump Sum	
1111 (9)	3 Spool Insulator Secondary Rack	1.00	Set	
	TOTAL PART F			
PART G	MECHANICAL			
1200 (13) a	Air Conditioning System, Package/Split Type	1.00	Lump Sum	
1202 (6) a1	Fire Extinguisher, 4.54 kg, ABC with bracket	3.00	Set	
1208 (1)	Fire Alarm System	1.00	Lump Sum	



REPUBLIC OF THE PHILIPPINES
DEPARTMENT OF PUBLIC WORKS AND HIGHWAYS
REGIONAL OFFICE No. IV-A
BATANGAS 2ND DISTRICT ENGINEERING OFFICE
KUMINTANG ILAYA, BATANGAS CITY

PROJECT TITLE / LOCATION :

C.Y. 2025 PROJECT
CONVERGENCE AND SPECIAL SUPPORT PROGRAM,
BASIC INFRASTRUCTURE PROGRAM (BIP),
MULTI-PURPOSE BUILDINGS/FACILITIES TO SUPPORT SOCIAL SERVICES,
CONSTRUCTION OF MULTI-PURPOSE BUILDING
(TINGLOY MUNICIPAL TOURISM AND CULTURAL ARTS BUILDING) ,
AT TINGLOY, BATANGAS

PREPARED BY :

CHRISTIAN S. BAGSIT
ENGINEER II

DATE :

CHECKED & REVIEWED :

GEMMA L. OLAN
CHIEF, PLANNING & DESIGN SECTION

DATE :

RECOMMENDED :

ARIEL V. ARMEDILLA
ASSISTANT DISTRICT ENGINEER

DATE :

APPROVED :

SONIA D. PAGLICAUAN
DISTRICT ENGINEER

DATE :

SHEET CONTENT :

SUMMARY OF QUANTITIES

SHEET NO.:

G-1




NOTES:

AS PER DEPARTMENT ORDER NO. 021 SERIES OF 2017

1. THE NEW BILLBOARD DESIGN LAYOUT AND DIMENSION (SEE DRAWING) SHALL BE INSTALLED ON A STANDARD BILLBOARD MEASURING 1220mm. x 2440mm. USING 12mm. (1/2 inch) THICK MARINE PLYWOOD OR TARPULIN POSTED ON 5mm. (3/16 inch) MARINE PLYWOOD.
2. FOR EACH BUILDING PROJECT, THE BILLBOARD SHALL BE INSTALLED IN FRONT OF THE PROJECT SITE.
3. FOR EACH ROAD/BRIDGE/FLOOD CONTROL PROJECT, TWO BILLBOARDS SHALL BE INSTALLED, ONE AT THE BEGINNING AND ONE AT THE END OF THE PROJECT.
4. FOR ROAD PROJECTS WITH LENGTH OF 10 KILOMETERS OR MORE, BILLBOARD(S) SHALL ALSO BE INSTALLED AT EVERY 5 KILOMETERS INTERVAL.
5. NAME(S) AND/OR PICTURE(S) OF ANY PERSONAGES SHOULD NOT APPEAR IN THE BILLBOARD.
6. NO POLITICAL BILLBOARDS SHALL BE ALLOWED TO BE INSTALLED 100 METERS BEFORE AND 100 METERS AFTER ALL DPWH PROJECTS AND IN BETWEEN THE PROJECT LIMITS OR WITHIN THE ROAD RIGHT-OF-WAY.
7. DPWH CONTRACTORS SHALL NOT BE ALLOWED TO PLACE NAMES OF POLITICIANS ON THEIR EQUIPMENT OR CARRY POLITICAL BILLBOARD ON THEIR EQUIPMENT.



TARPAULIN, WHITE, 8 ft x 8 ft
RESOLUTION : 70 DPI
FONT : HELVETICA
FONT SIZE : MAIN INFORMATION - 3"
FONT COLOR : BLACK

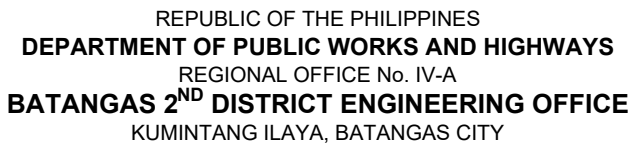

PROJECT TITLE / LOCATION :

C.Y. 2025 PROJECT
CONVERGENCE AND SPECIAL SUPPORT PROGRAM,
BASIC INFRASTRUCTURE PROGRAM (BIP),
MULTI-PURPOSE BUILDINGS/FACILITIES TO SUPPORT SOCIAL SERVICES,
CONSTRUCTION OF MULTI-PURPOSE BUILDING
(TINGLOY MUNICIPAL TOURISM AND CULTURAL ARTS BUILDING) ,
AT TINGLOY, BATANGAS

PREPARED :

JACINTO T. MACARAIG
ARCHITECT II

DATE : _____

REVIEWED & SUBMITTED :

GEMMA L. OLAN
 CHIEF, PLANNING & DESIGN SECTION

DATE : _____

RECOMMENDED :

ARIEL V. ARMEDILLA
ASSISTANT DISTRICT ENGINEER

DATE : _____

APPROVED :

SONIA D. PAGLICAUAN
DISTRICT ENGINEER

DATE :

SHEET CONTENT :

SIGN BOARD DETAILS


SHEET NO.:

G-2

SITE

SITE


SITE

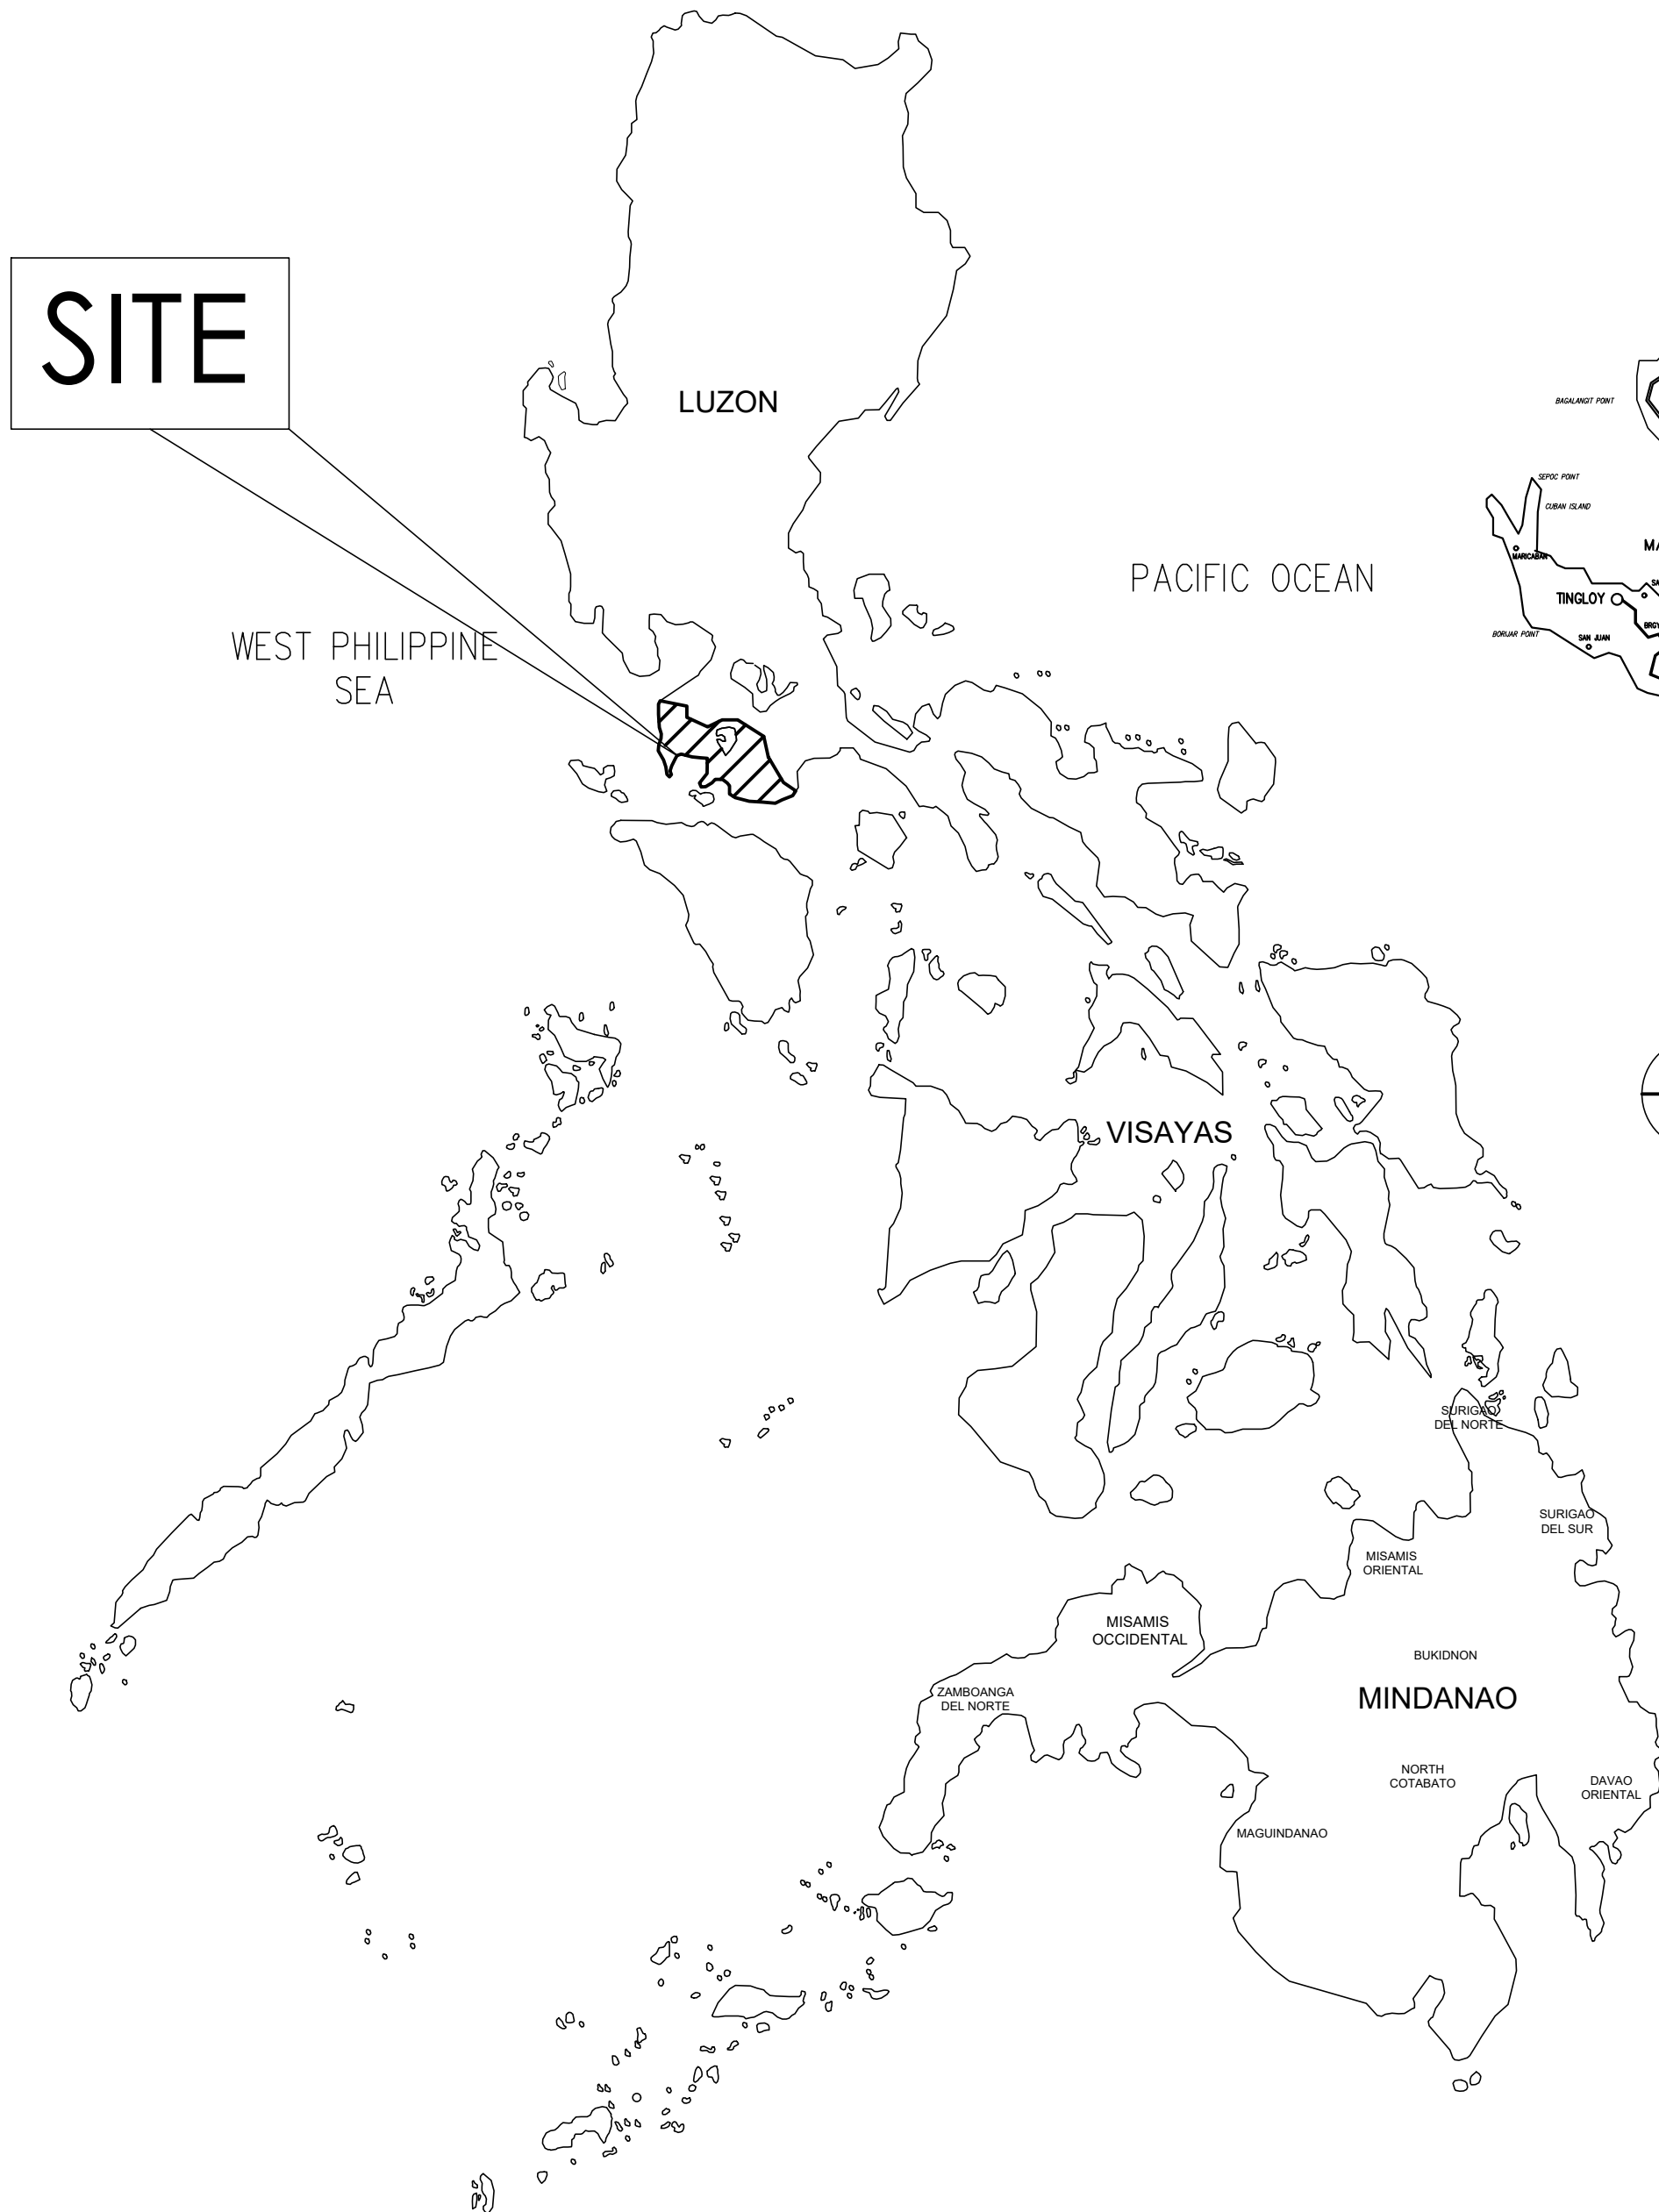

MAP OF BATANGAS
2ND & 5TH DISTRICT
SCALE NTS.





- LEGEND:
- BARANGAY BOUNDARY
 - NATIONAL ROAD
 - BARANGAY/MUNICIPAL ROAD
 - RIVER/CREEK LINE

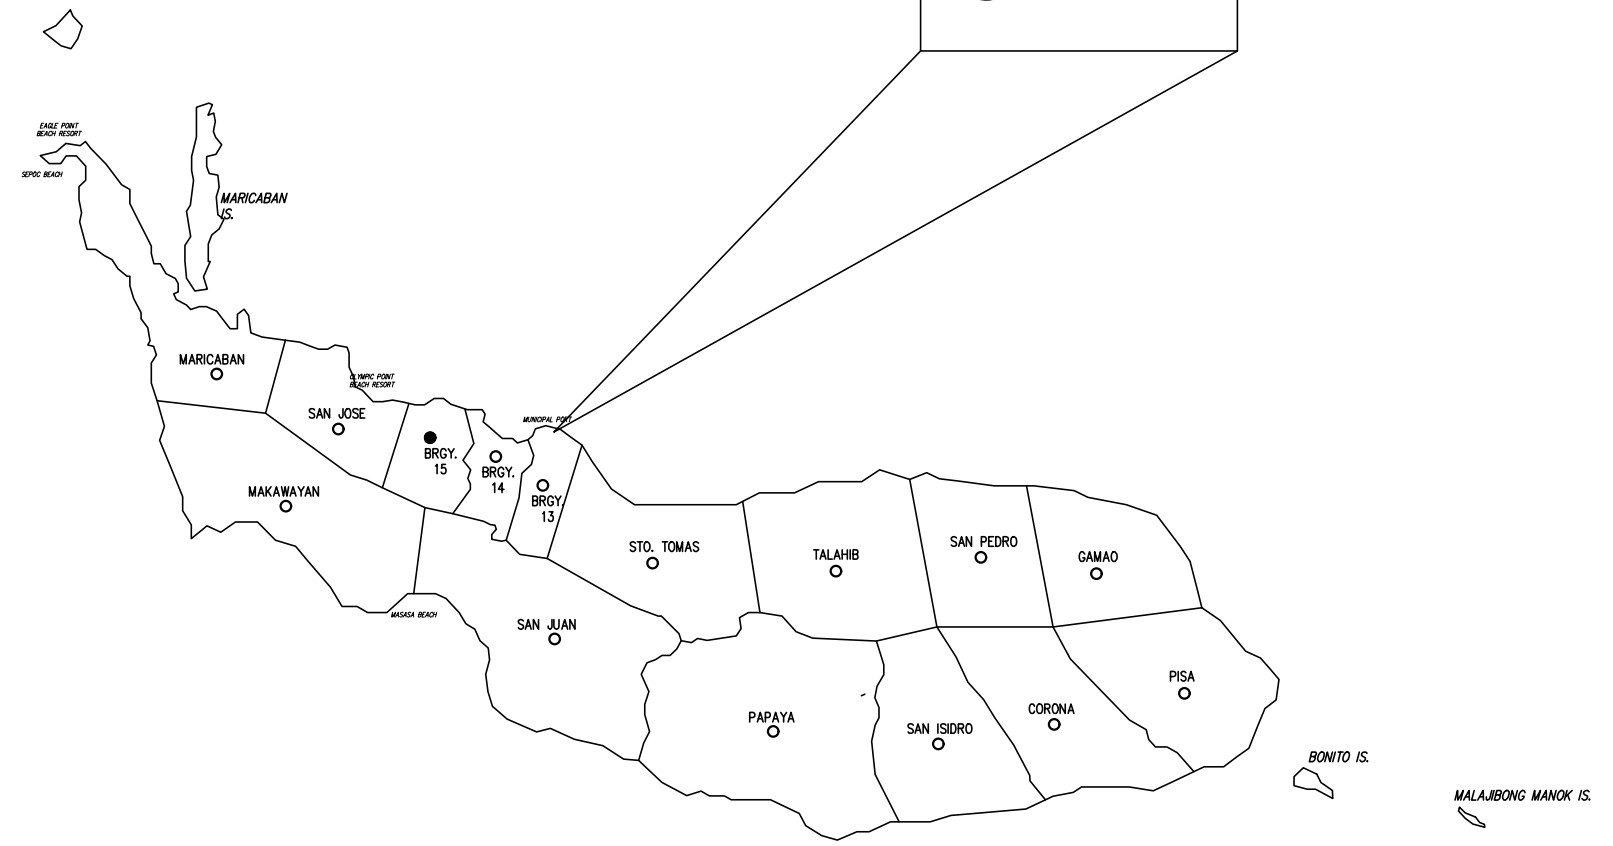

MAP OF TINGLOY
LOCATION MAP
SCALE

MAP OF THE PHILIPPINES
SCALE NTS.

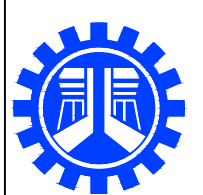 REPUBLIC OF THE PHILIPPINES DEPARTMENT OF PUBLIC WORKS AND HIGHWAYS REGIONAL OFFICE No. IV-A BATANGAS 2ND DISTRICT ENGINEERING OFFICE KUMINTANG ILAYA, BATANGAS CITY	PROJECT TITLE / LOCATION : C.Y. 2025 PROJECT CONVERGENCE AND SPECIAL SUPPORT PROGRAM, BASIC INFRASTRUCTURE PROGRAM (BIP), MULTI-PURPOSE BUILDINGS/FACILITIES TO SUPPORT SOCIAL SERVICES, CONSTRUCTION OF MULTI-PURPOSE BUILDING (TINGLOY MUNICIPAL TOURISM AND CULTURAL ARTS BUILDING) , AT TINGLOY, BATANGAS	PREPARED : JACINTO T. MACARAIG ARCHITECT II DATE :	REVIEWED & SUBMITTED : GEMMA L. OLAN CHIEF, PLANNING & DESIGN SECTION DATE :	RECOMMENDED : ARIEL V. ARMEDILLA ASSISTANT DISTRICT ENGINEER DATE :	APPROVED : SONIA D. PAGLICAUAN DISTRICT ENGINEER DATE :	SHEET CONTENT : MAP OF THE PHILIPPINES MAP OF BATANGAS 2ND DISTRICT MAP OF TINGLOY	SHEET NO.: G-3
--	--	---	---	--	--	--	-----------------------

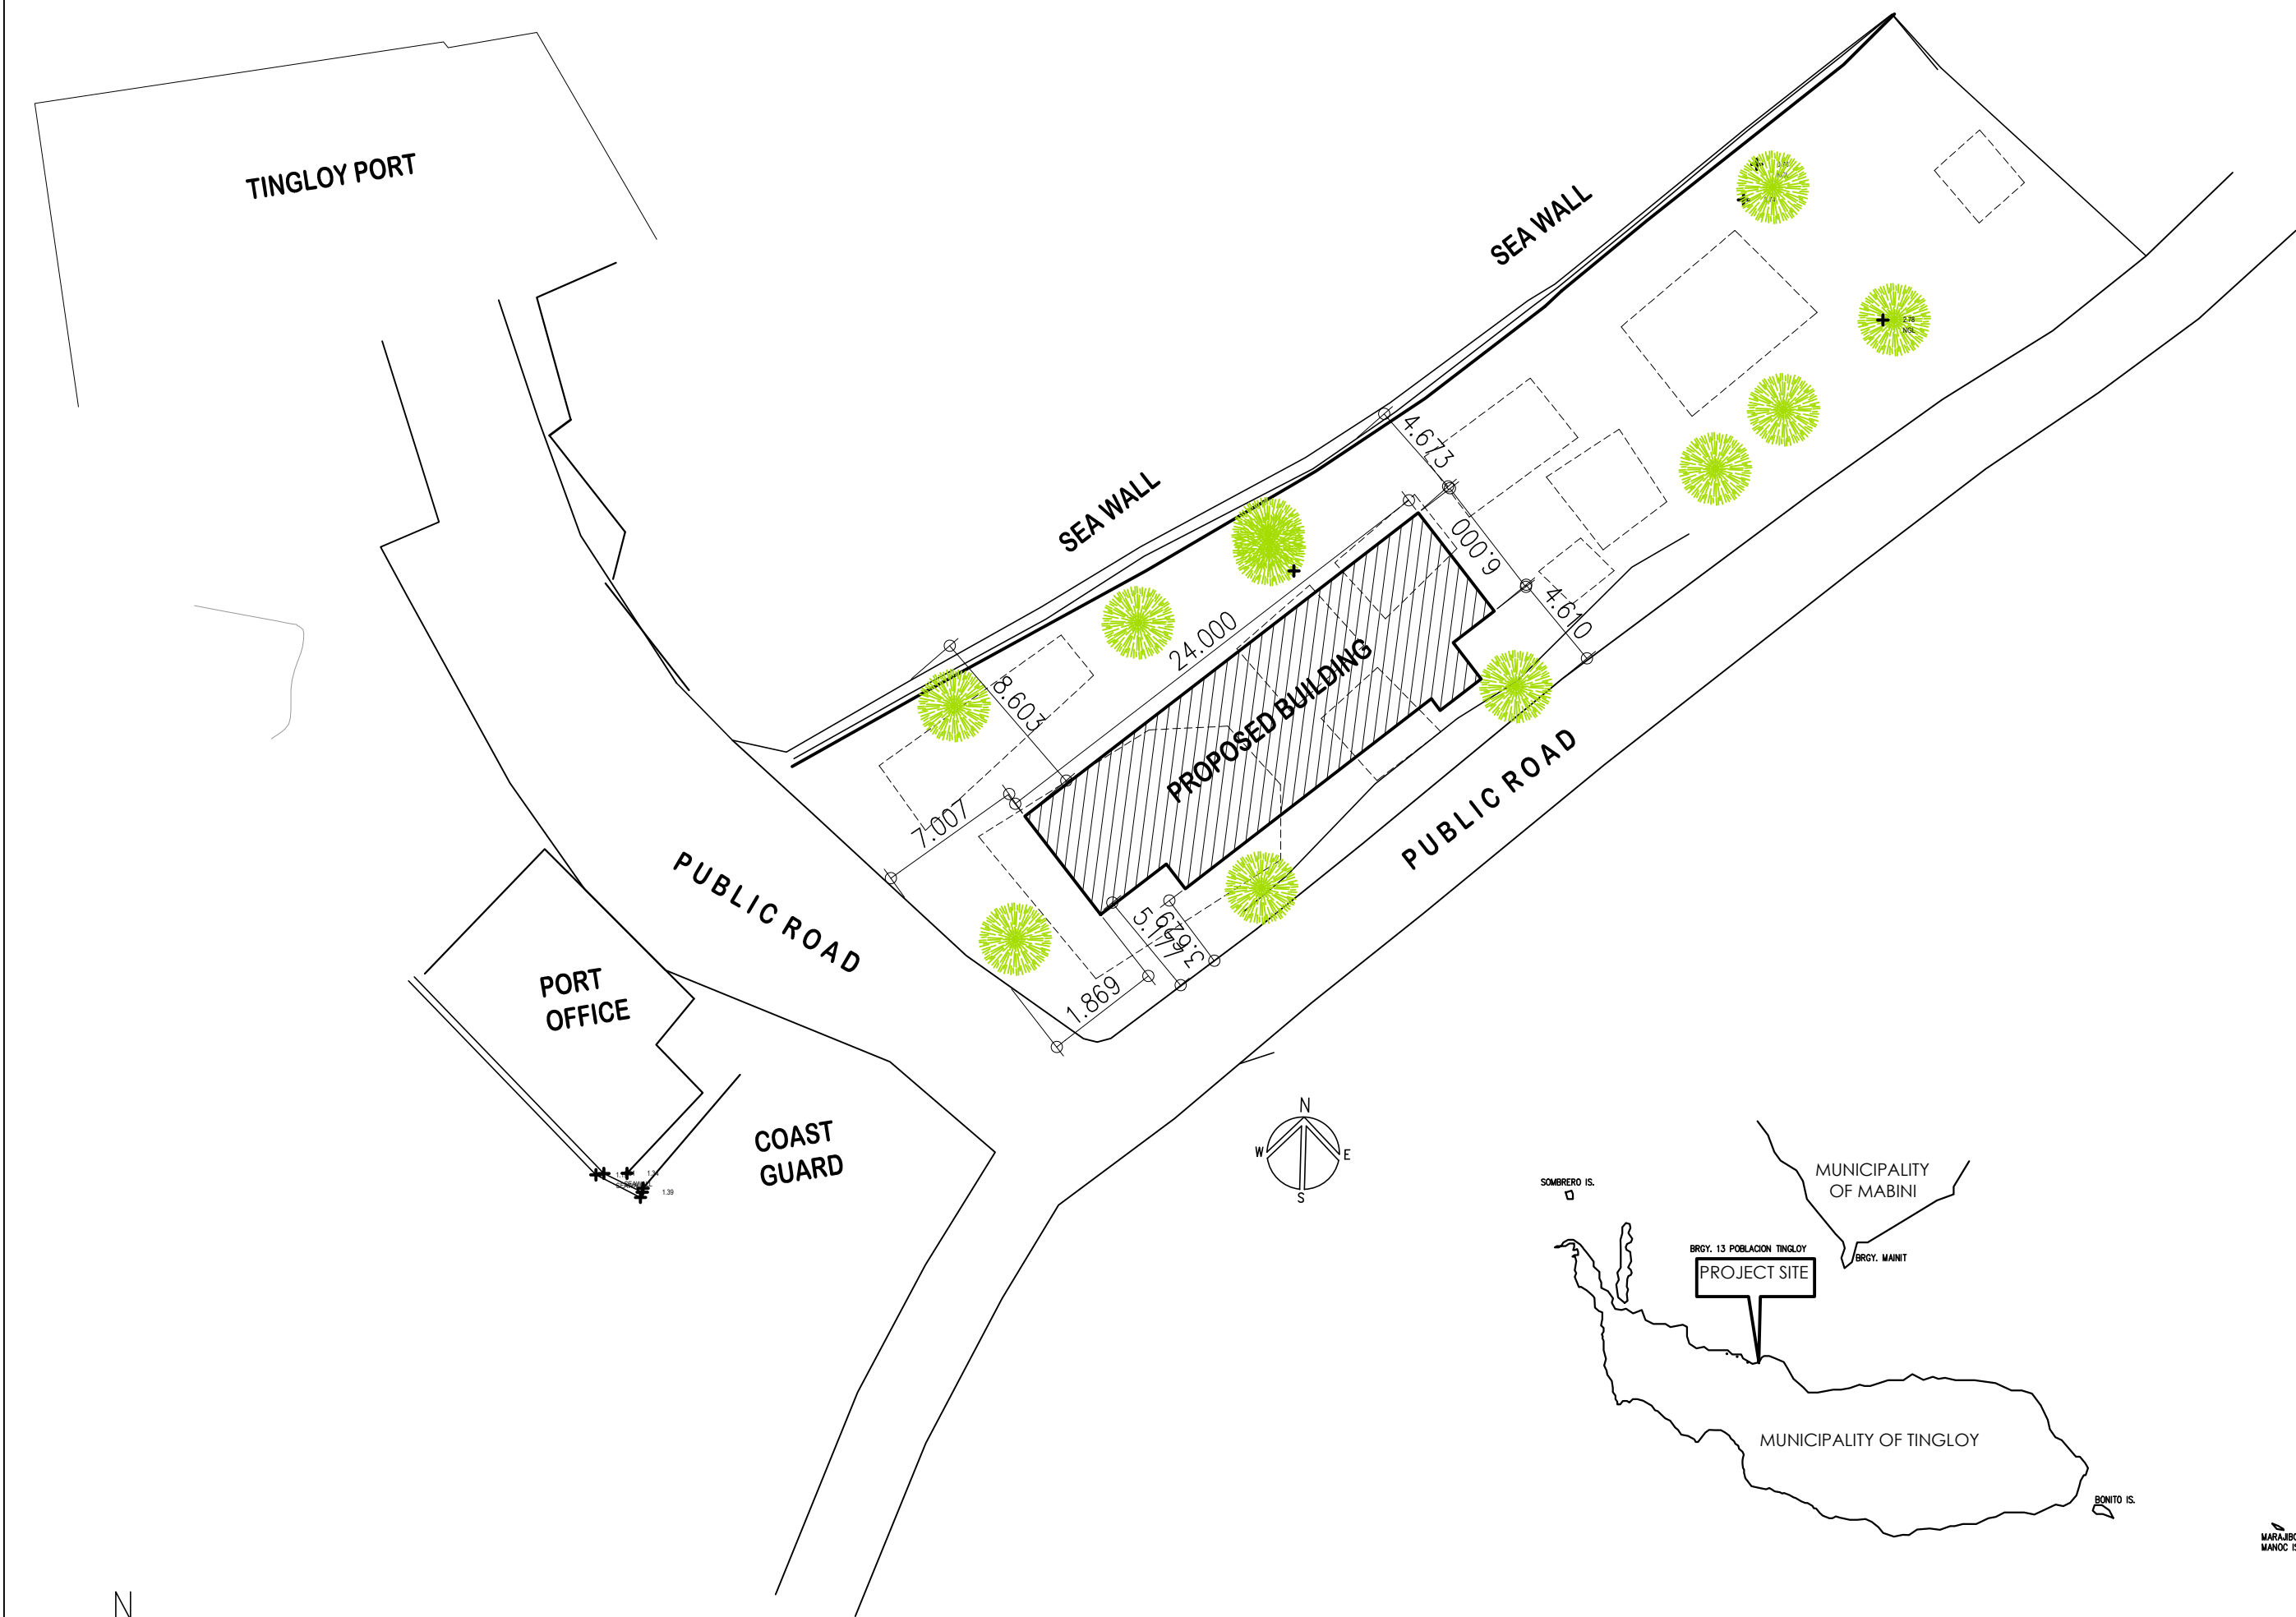


GROSS AREA = 385.52 SQ. M.
SITE DEVELOPMENT PLAN
1 : 300 MTS.







2
A-1
PERSPECTIVE
NOT TO SCALE

POBLACION BRGY. 13
LATITUDE = 13.661778
LONGITUDE = 120.874028

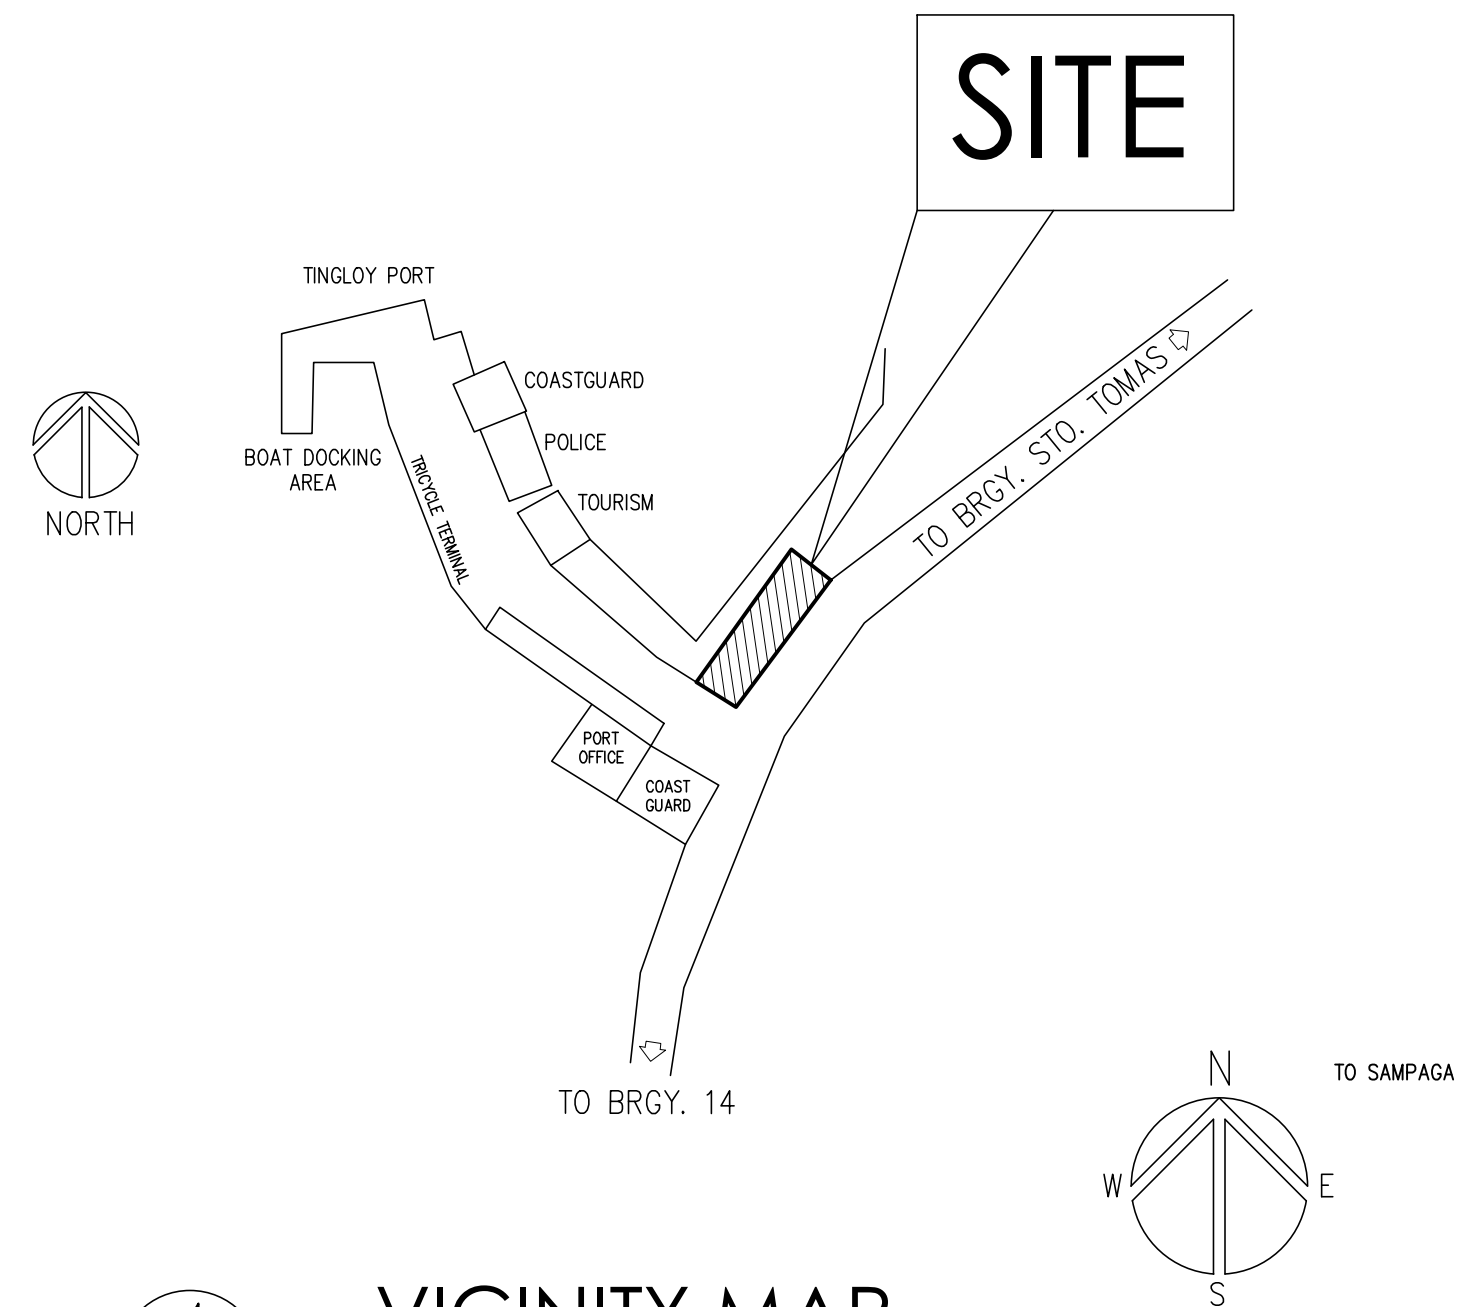

4
A-1
VICINITY MAP
SCALE NTS

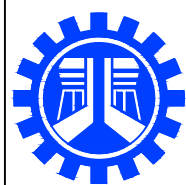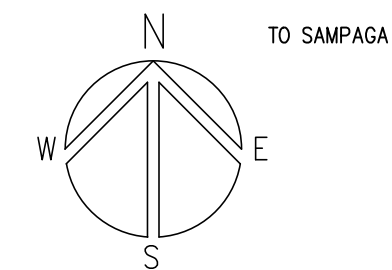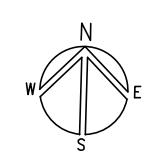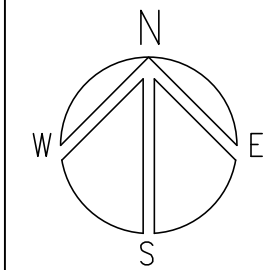

REPUBLIC OF THE PHILIPPINES
DEPARTMENT OF PUBLIC WORKS AND HIGHWAYS
REGIONAL OFFICE No. IV-A
BATANGAS 2ND DISTRICT ENGINEERING OFFICE
KUMINTANG ILAYA, BATANGAS CITY

PROJECT TITLE / LOCATION :
C.Y. 2025 PROJECT
CONVERGENCE AND SPECIAL SUPPORT PROGRAM,
BASIC INFRASTRUCTURE PROGRAM (BIP),
MULTI-PURPOSE BUILDINGS/FACILITIES TO SUPPORT SOCIAL SERVICES,
CONSTRUCTION OF MULTI-PURPOSE BUILDING
(TINGLOY MUNICIPAL TOURISM AND CULTURAL ARTS BUILDING) ,
AT TINGLOY, BATANGAS

DRAWN & PREPARED BY:

JACINTO T. MACARAIG
ARCHITECT II
DATE :

REVIEWED & SUBMITTED :

GEMMA L. OLAN
CHIEF, PLANNING & DESIGN SECTION
DATE :


RECOMMENDED :

ARIEL V. ARMEDILLA
ASSISTANT DISTRICT ENGINEER
DATE :


APPROVED :

SONIA D. PAGLICAUAN
DISTRICT ENGINEER
DATE :


REPUBLIC OF THE PHILIPPINES OFFICE OF THE BUILDING OFFICIAL	
CITY/MUNICIPALITY	
BUILDING OFFICIAL	
LANDUSE & ZONING	
LINE & GRADE	
ARCHITECTURAL	
STRUCTURAL	
ELECTRICAL	
MECHANICAL	
SANITARY	
ELECTRONICS	
FIRE & SAFETY	
DESIGN BY :	
ARCHITECT OF RECORD	
PRC No.	VALIDITY :
PTR No.	DATE ISSUED :
PLACE ISSUED:	TIN :
SHEET CONTENT :	SHEET NO.:
PERSPECTIVE SITE DEVELOPMENT PLAN LOCATION MAP VICINITY MAP	A-1

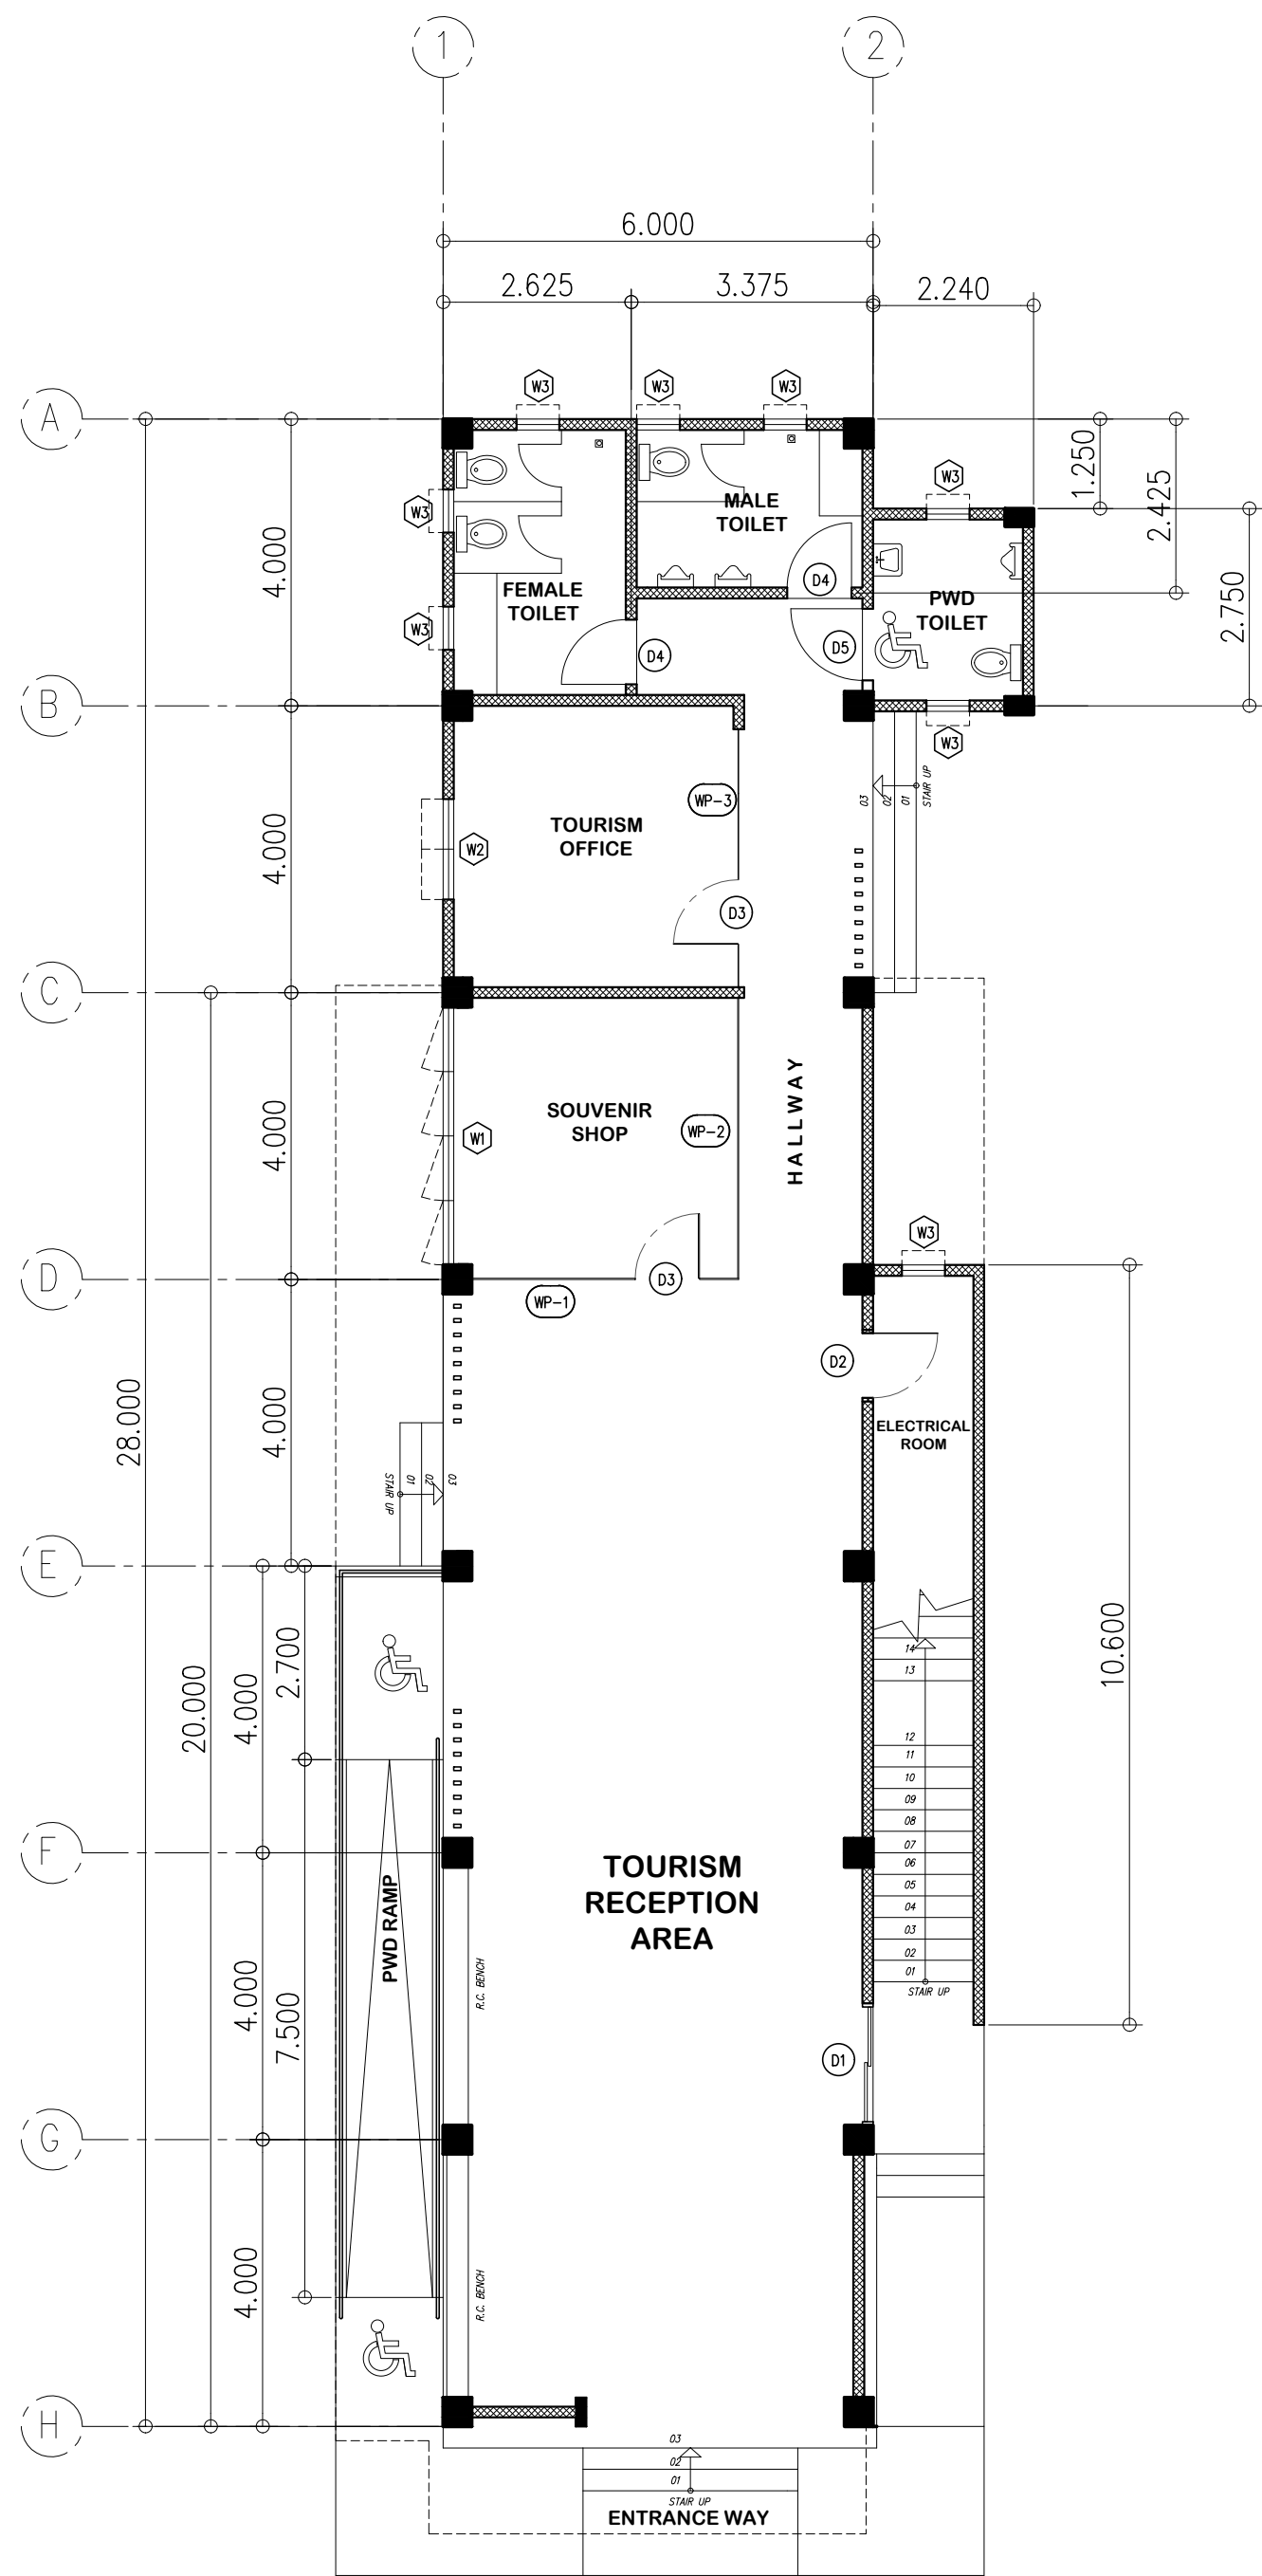

1
A-2 SCALE 1:100 MTS.

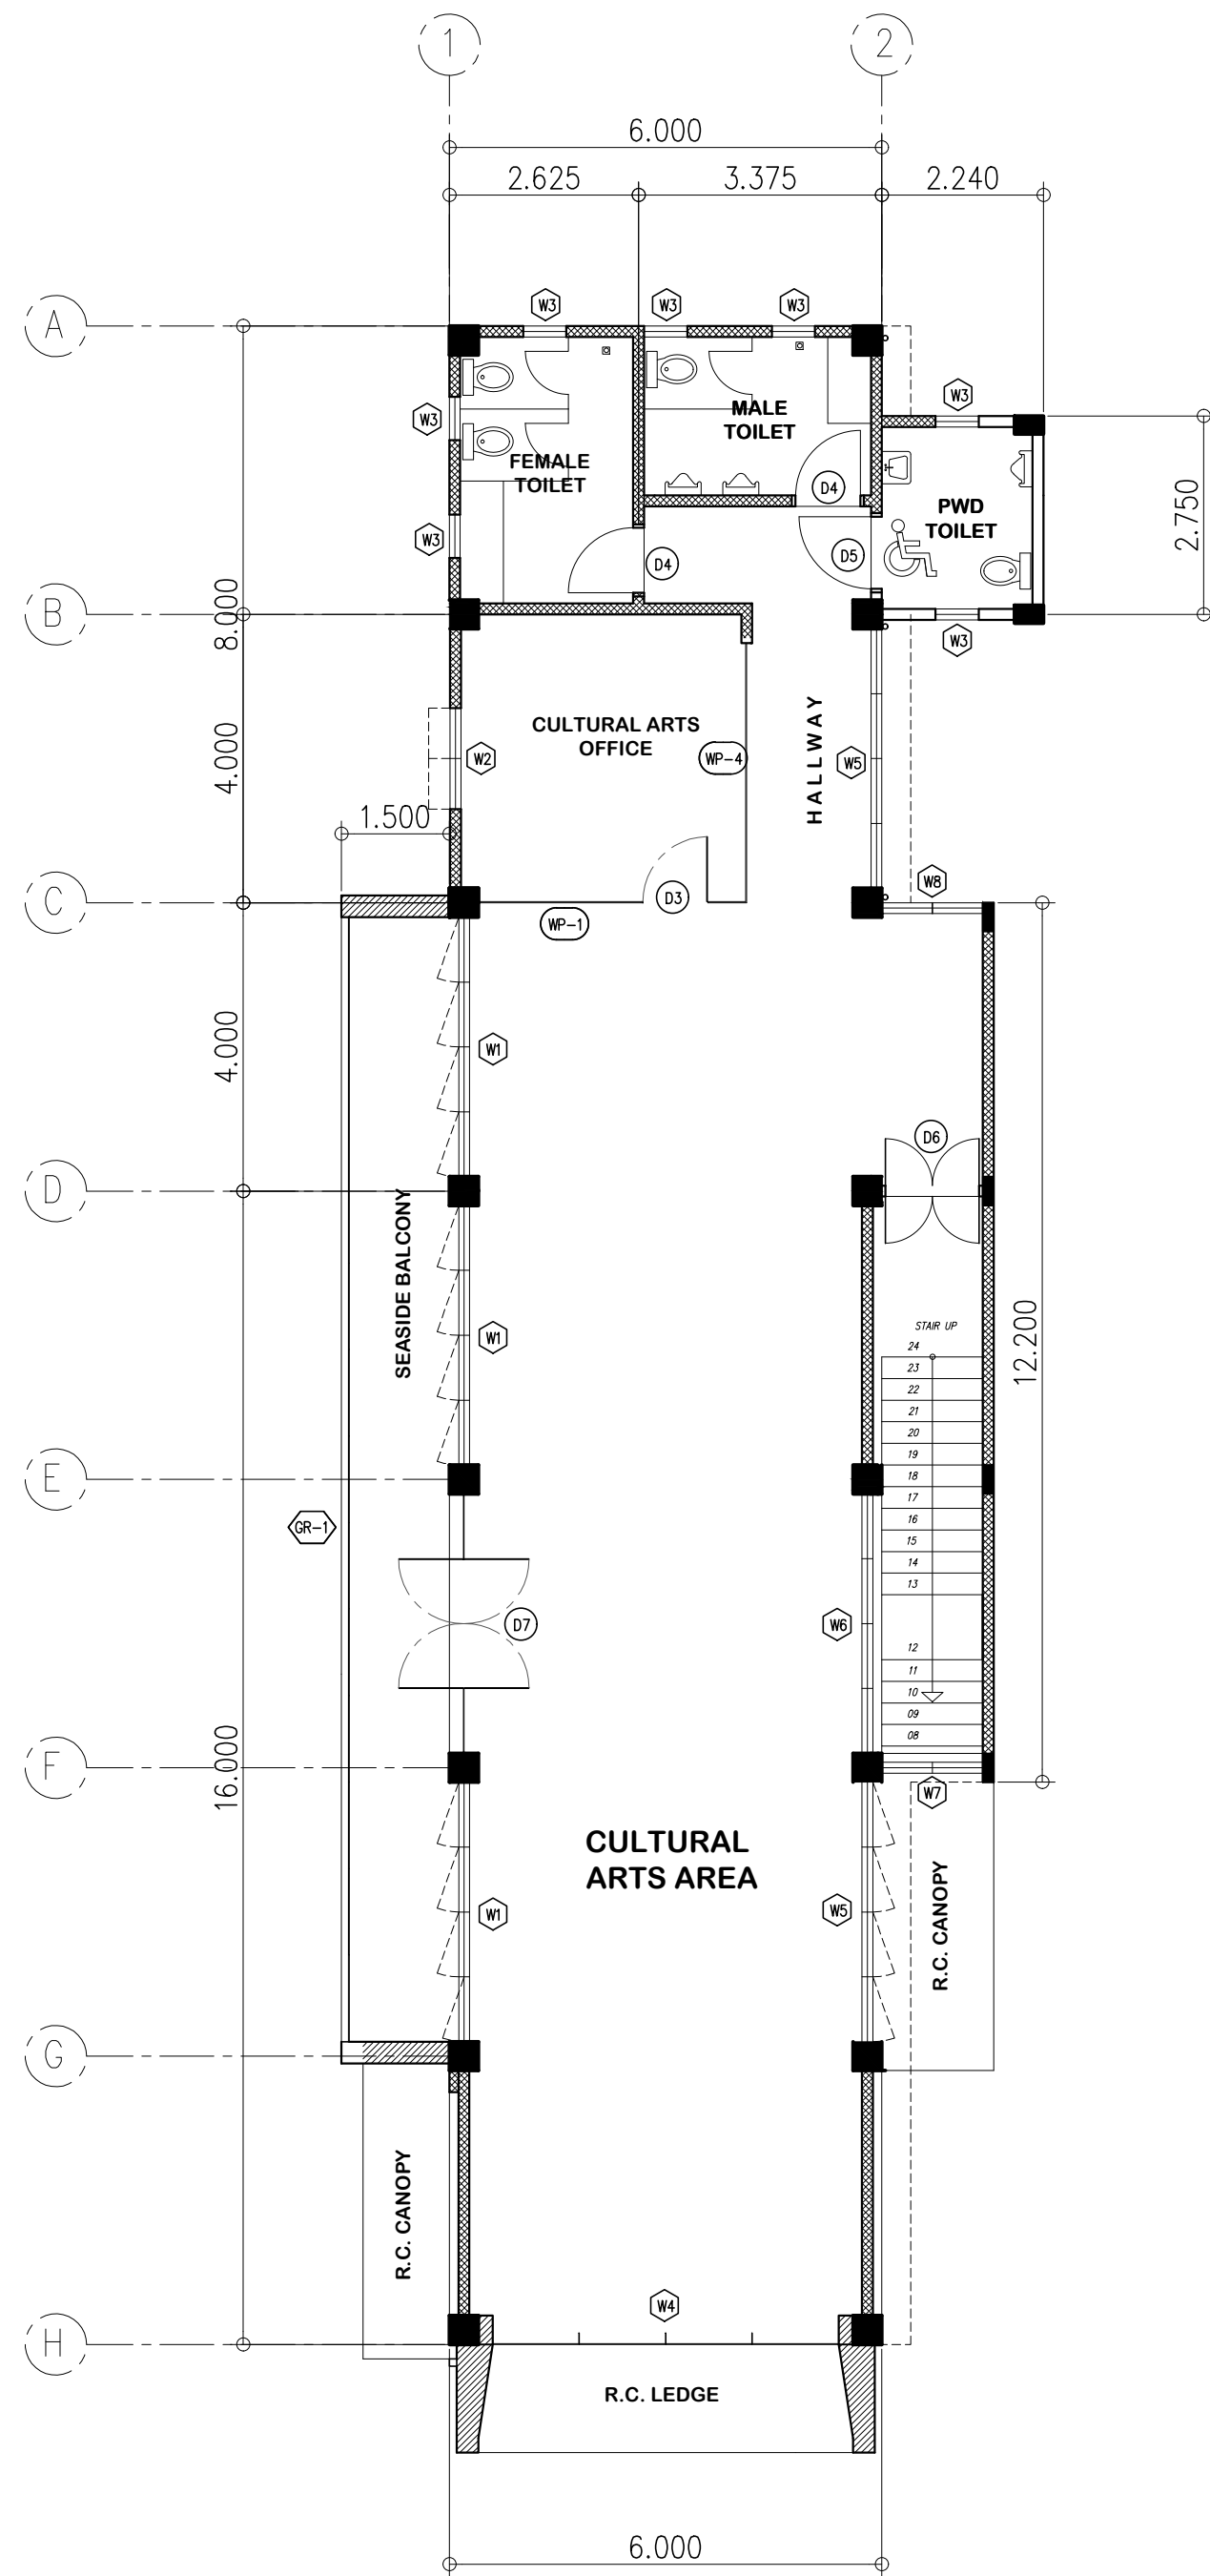


2
A-2 SCALE 1:100 MTS.

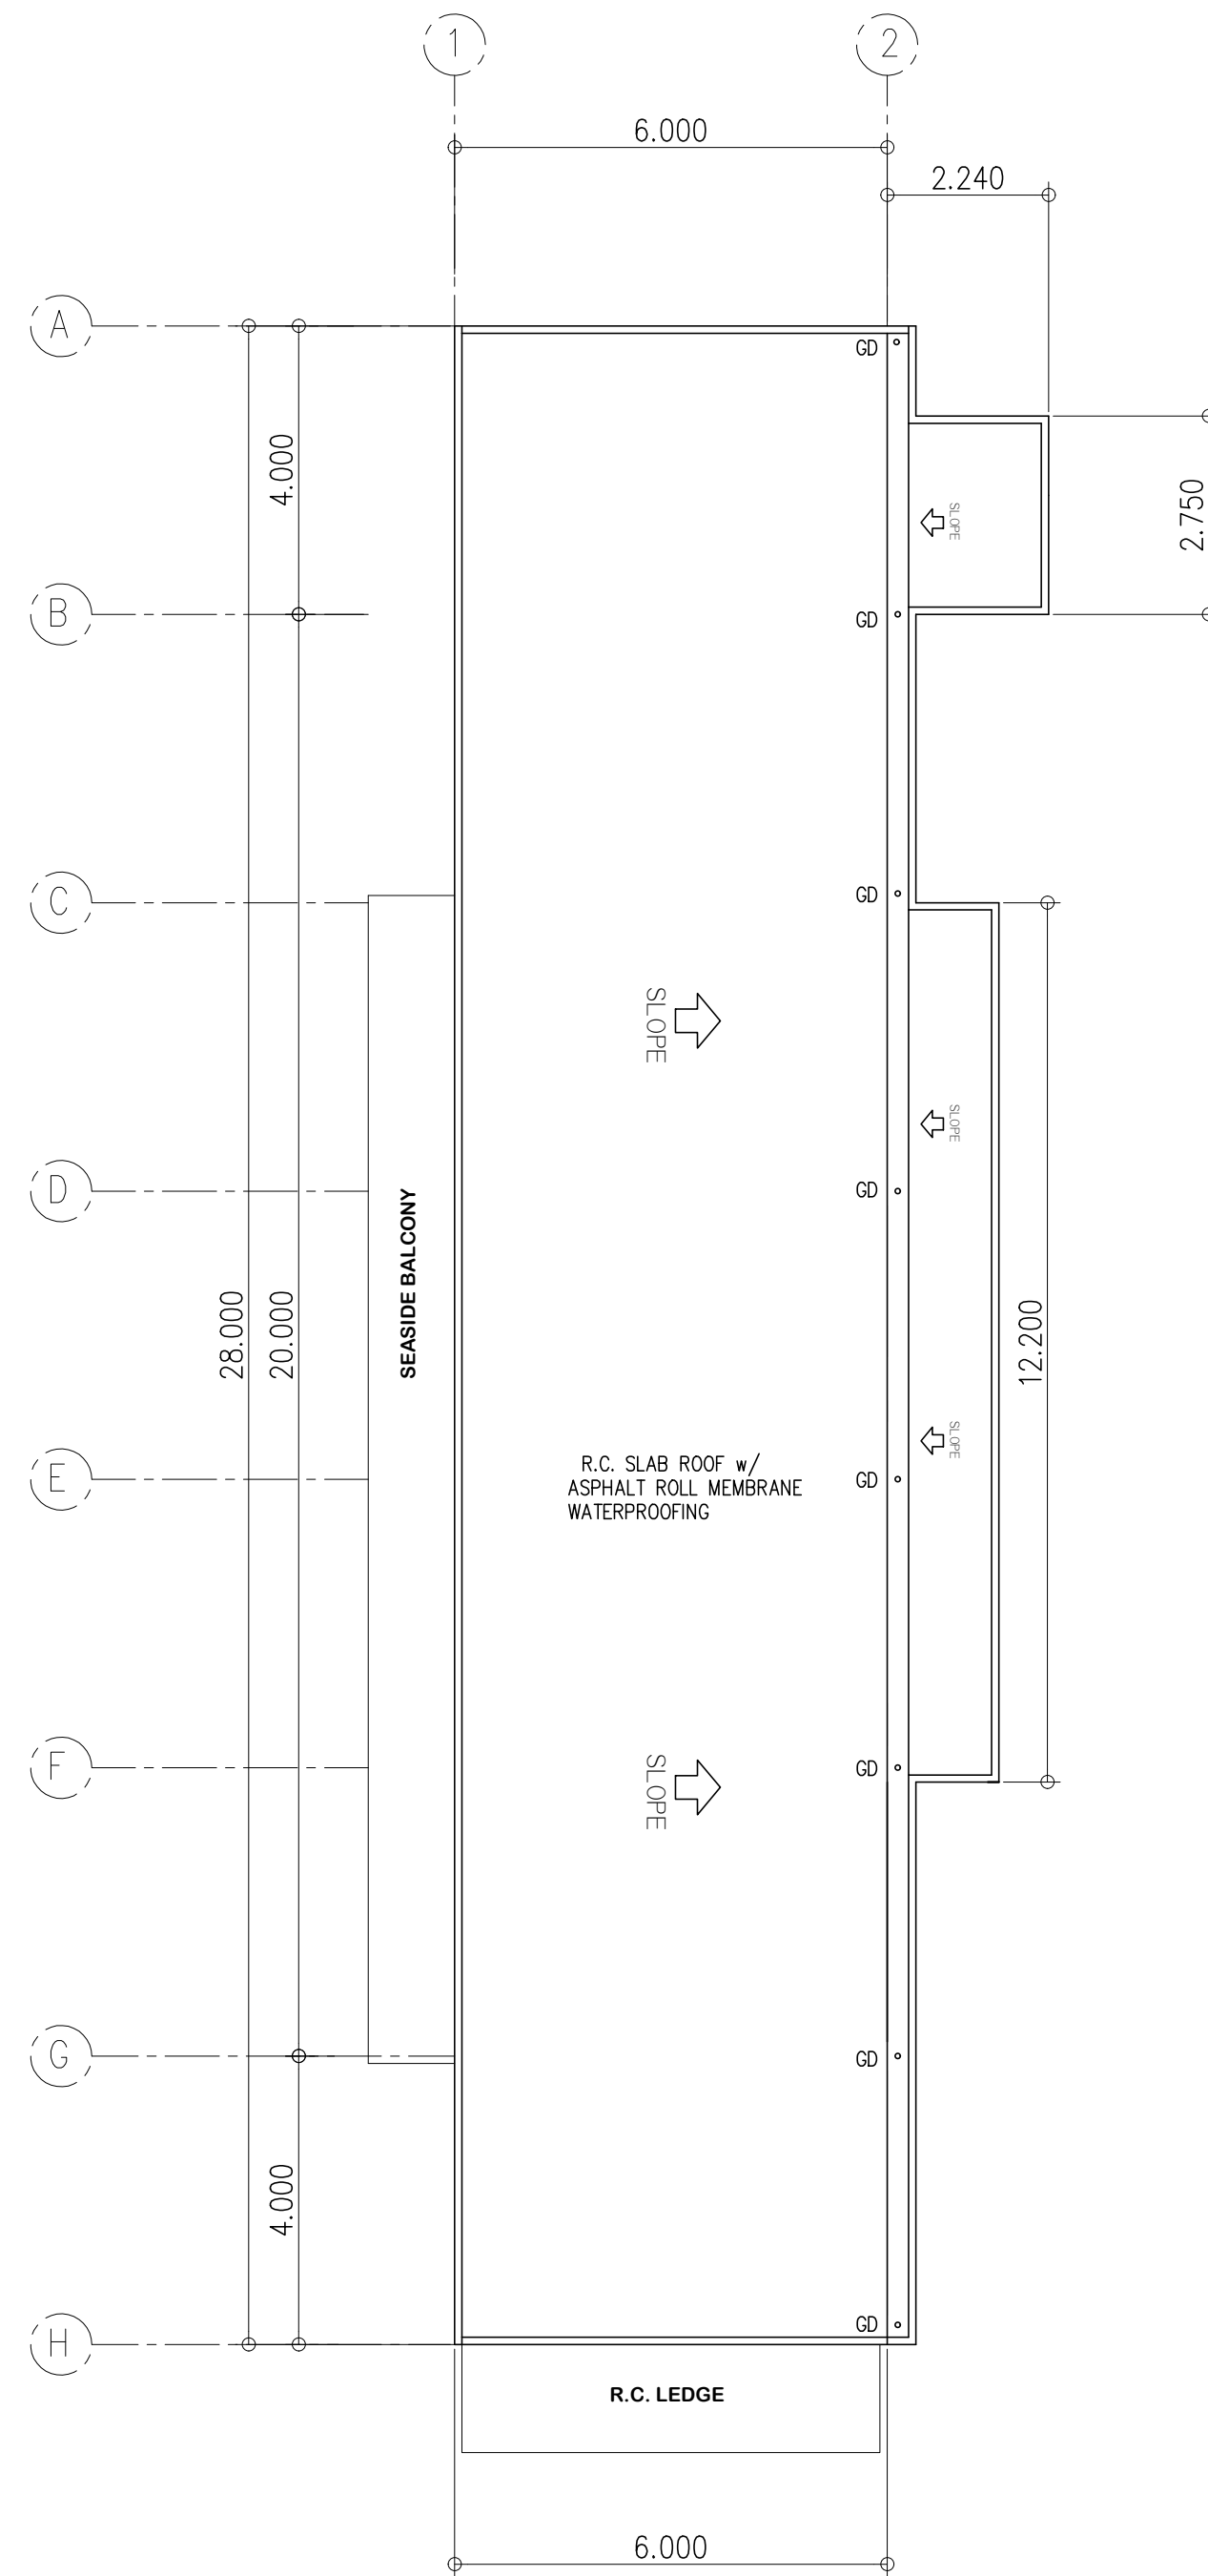

2
A-2 SCALE 1:100 MTS.

DESIGN BY :	
ARCHITECT OF RECORD	
PRC No.	VALIDITY :
PTR No.	DATE ISSUED :
PLACE ISSUED:	TIN :
SHEET CONTENT :	SHEET NO.:
FLOOR PLANS	A-2

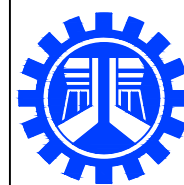

REPUBLIC OF THE PHILIPPINES
DEPARTMENT OF PUBLIC WORKS AND HIGHWAYS
REGIONAL OFFICE No. IV-A
BATANGAS 2ND DISTRICT ENGINEERING OFFICE
KUMINTANG ILAYA, BATANGAS CITY


PROJECT TITLE / LOCATION :
C.Y. 2025 PROJECT
CONVERGENCE AND SPECIAL SUPPORT PROGRAM,
BASIC INFRASTRUCTURE PROGRAM (BIP),
MULTI-PURPOSE BUILDINGS/FACILITIES TO SUPPORT SOCIAL SERVICES,
CONSTRUCTION OF MULTI-PURPOSE BUILDING
(TINGLOY MUNICIPAL TOURISM AND CULTURAL ARTS BUILDING) ,
AT TINGLOY, BATANGAS

DRAWN & PREPARED BY:
JACINTO T. MACARAIG
ARCHITECT II
DATE :


REVIEWED & SUBMITTED :
GEMMA L. OLAN
CHIEF, PLANNING & DESIGN SECTION
DATE :

RECOMMENDED :
ARIEL V. ARMEDILLA
ASSISTANT DISTRICT ENGINEER
DATE :


APPROVED :
SONIA D. PAGLICAUAN
DISTRICT ENGINEER
DATE :

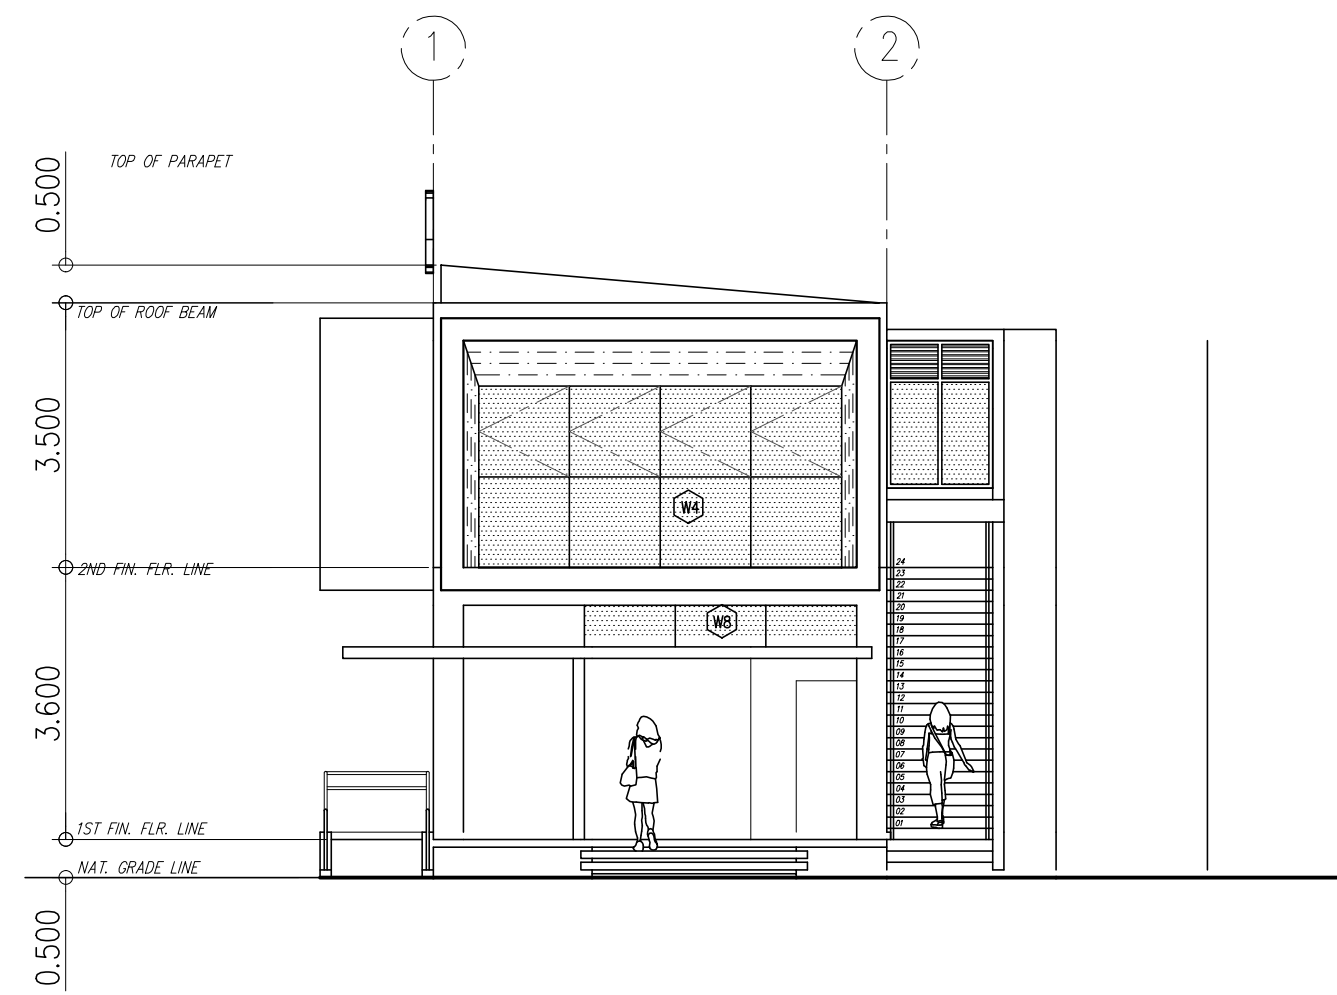


1 FRONT ELEVATION
A-3 SCALE 1:100 MTS.

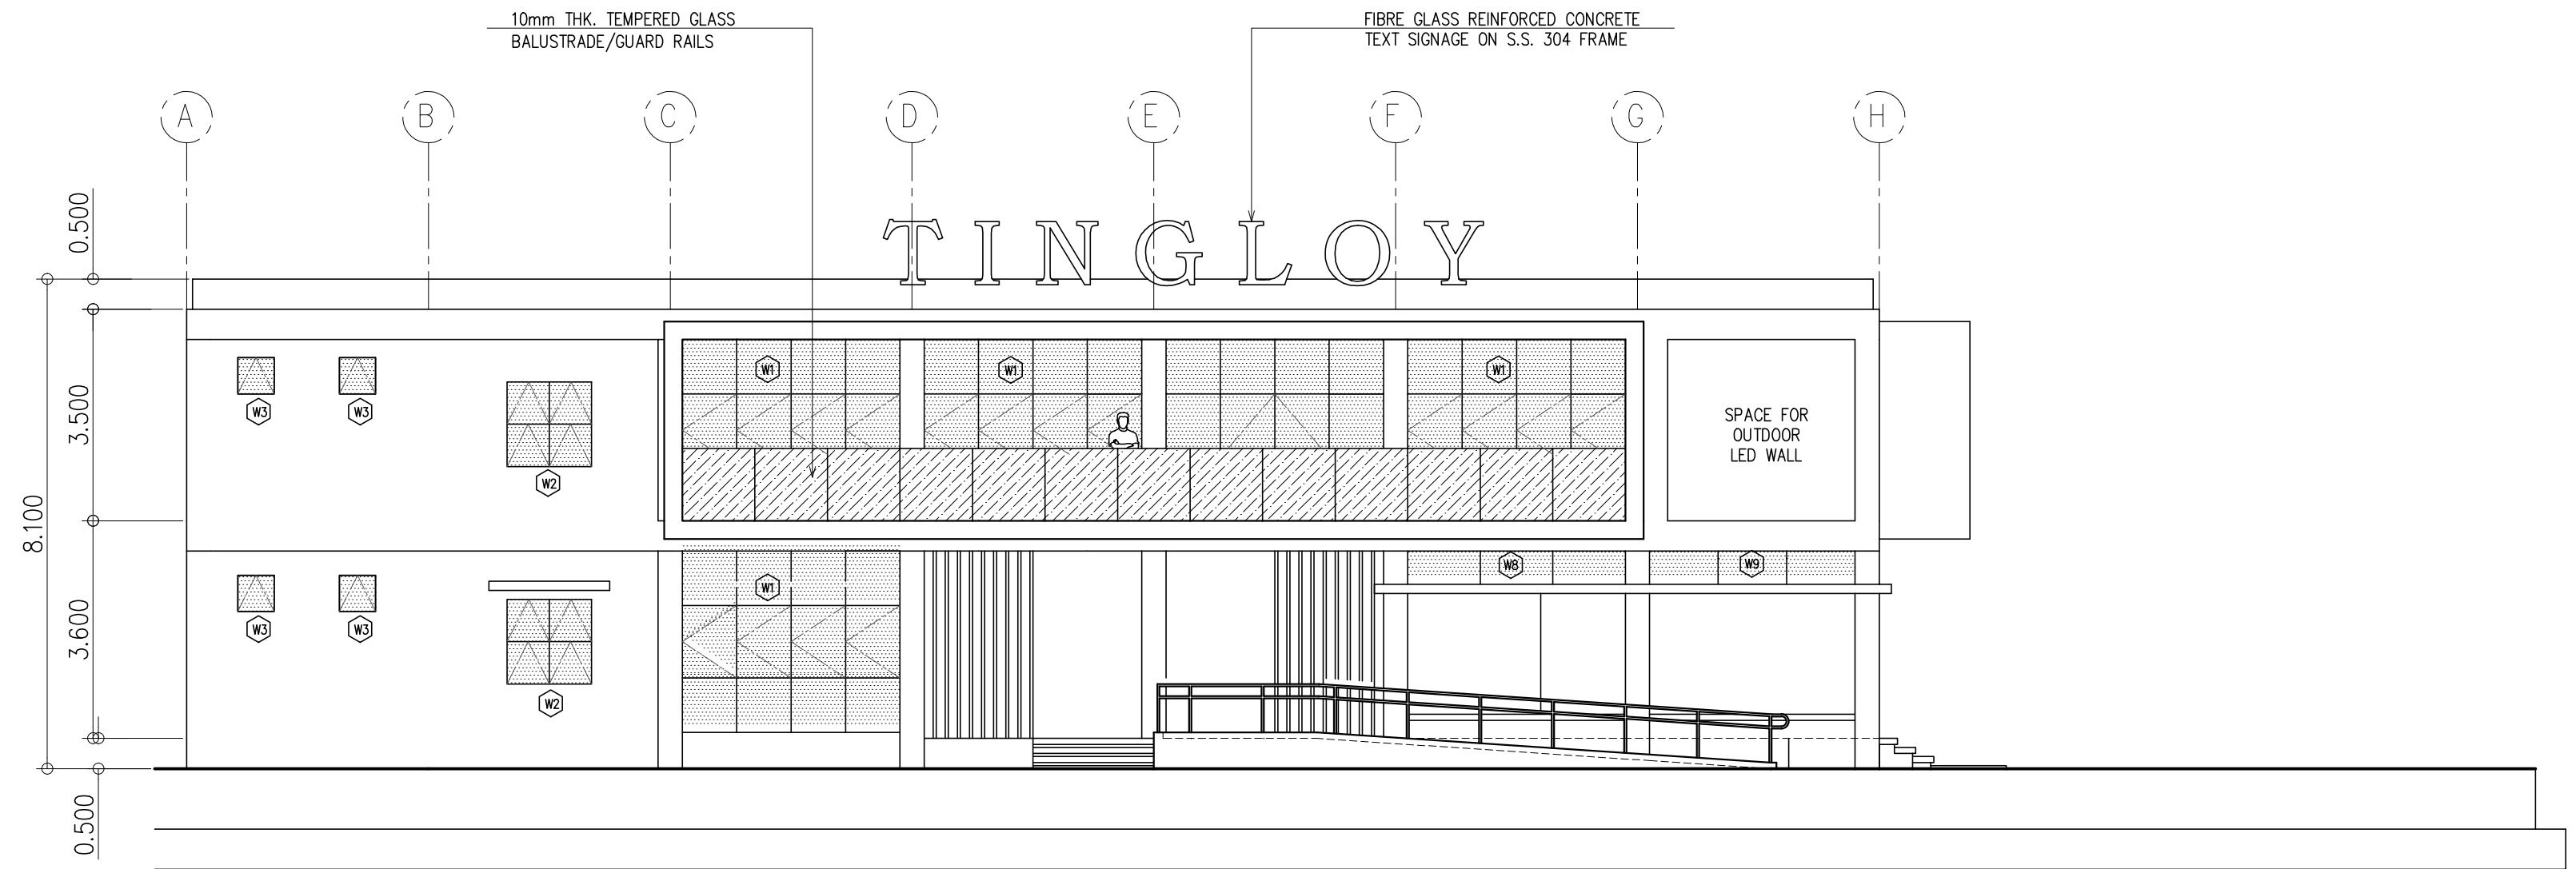


2 LEFT-SIDE ELEVATION
A-3 SCALE 1:100 MTS.

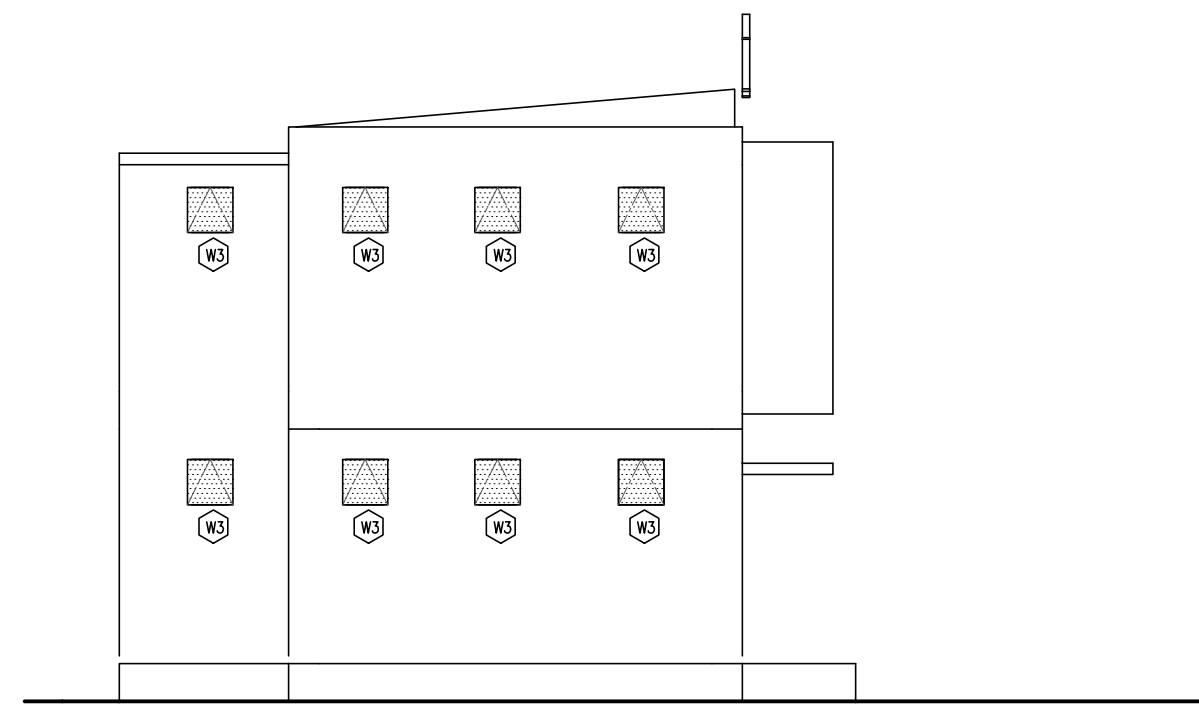

1 REAR ELEVATION
A-3 SCALE 1:100 MTS.

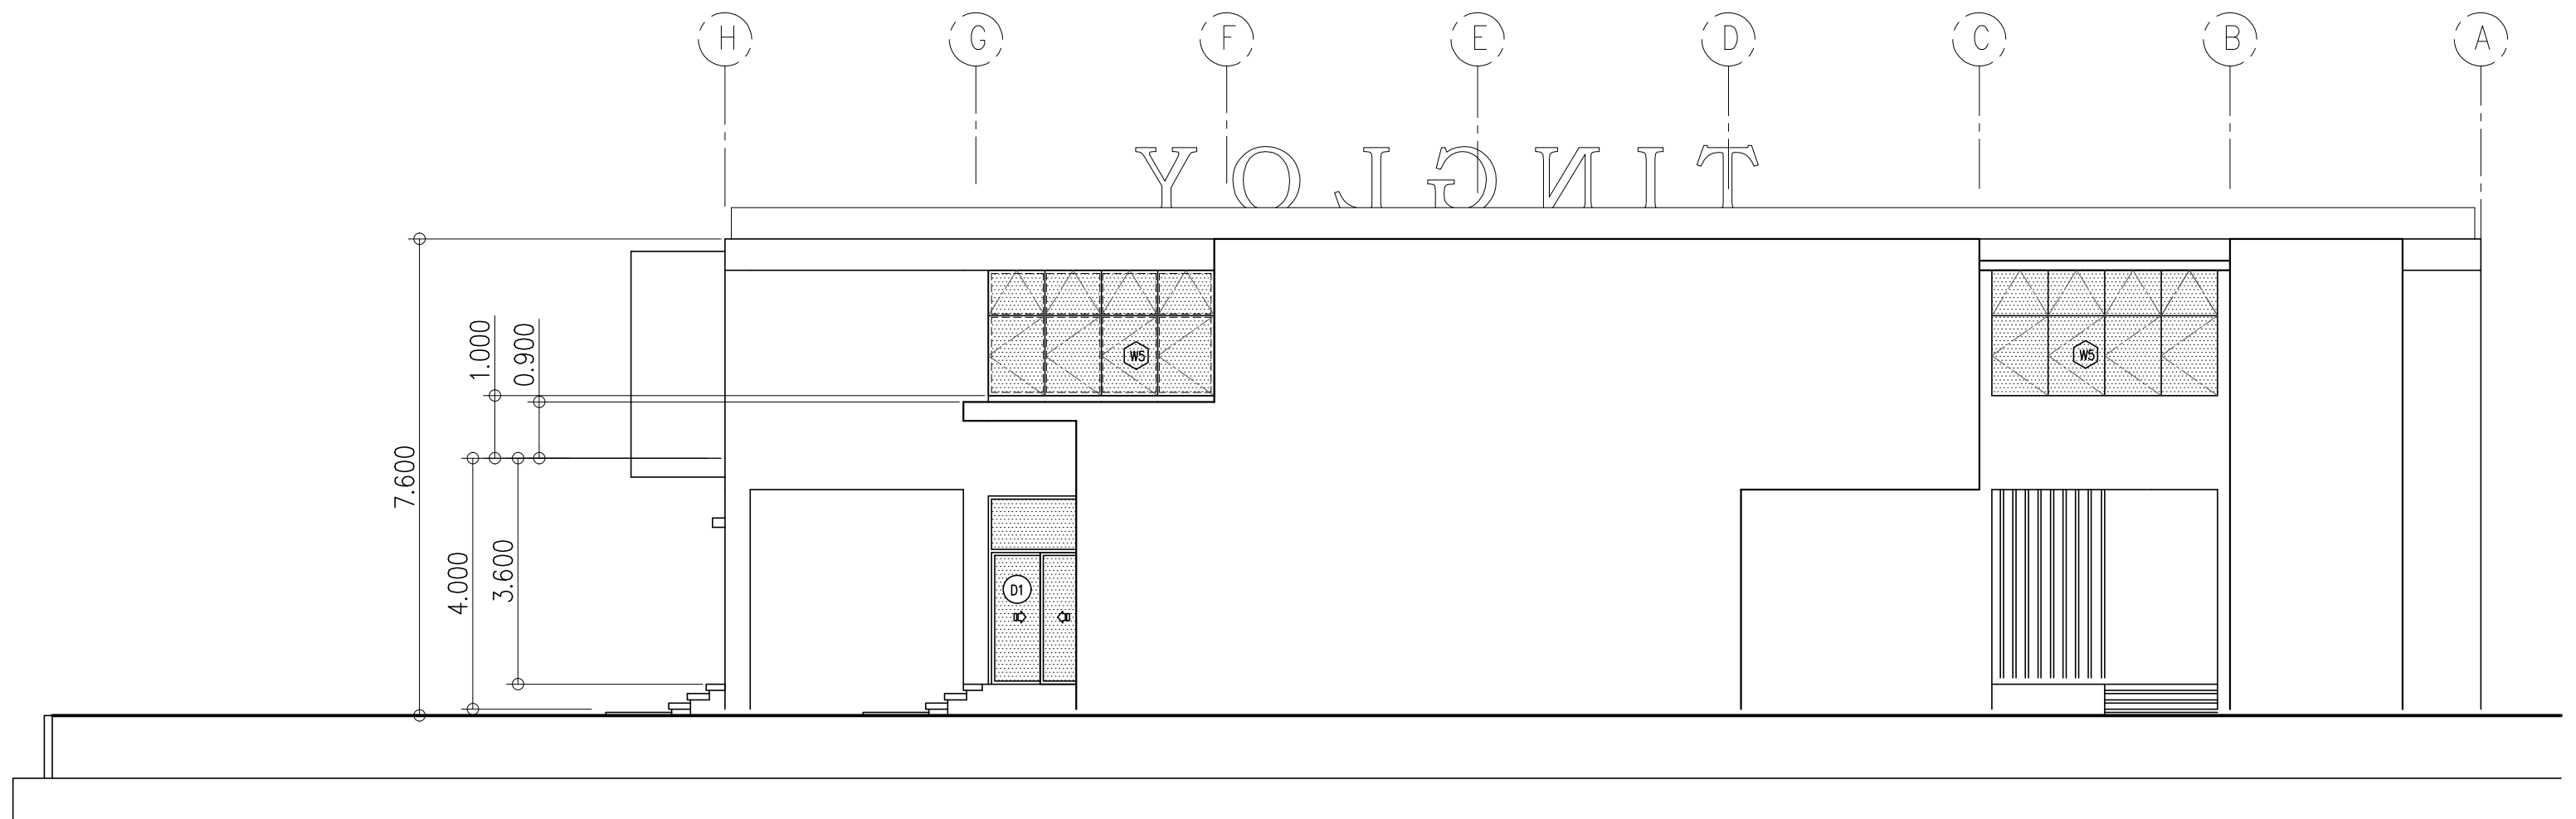

2 RIGHT-SIDE ELEVATION
A-3 SCALE 1:100 MTS.

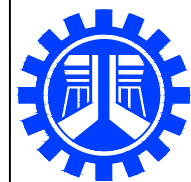

REPUBLIC OF THE PHILIPPINES
DEPARTMENT OF PUBLIC WORKS AND HIGHWAYS
REGIONAL OFFICE No. IV-A
BATANGAS 2ND DISTRICT ENGINEERING OFFICE
KUMINTANG ILAYA, BATANGAS CITY

PROJECT TITLE / LOCATION :
C.Y. 2025 PROJECT
CONVERGENCE AND SPECIAL SUPPORT PROGRAM,
BASIC INFRASTRUCTURE PROGRAM (BIP),
MULTI-PURPOSE BUILDINGS/FACILITIES TO SUPPORT SOCIAL SERVICES,
CONSTRUCTION OF MULTI-PURPOSE BUILDING
(TINGLOY MUNICIPAL TOURISM AND CULTURAL ARTS BUILDING) ,
AT TINGLOY, BATANGAS

DRAWN & PREPARED BY:
JACINTO T. MACARAIG
ARCHITECT II
DATE :

REVIEWED & SUBMITTED :
GEMMA L. OLAN
CHIEF, PLANNING & DESIGN SECTION
DATE :

RECOMMENDED :
ARIEL V. ARMEDILLA
ASSISTANT DISTRICT ENGINEER
DATE :






APPROVED :
SONIA D. PAGLICAUAN
DISTRICT ENGINEER
DATE :

DESIGN BY :	
ARCHITECT OF RECORD	
PRC No.	VALIDITY :
PTR No.	DATE ISSUED :
PLACE ISSUED:	TIN :
SHEET CONTENT :	SHEET NO.:
ELEVATIONS	A-3

LEGEND :



F = FIXED GLASS
A = AWNING PANEL
S = SLIDING PANEL
C = CASEMENT PANEL

1ST FIN. FLR. LINE

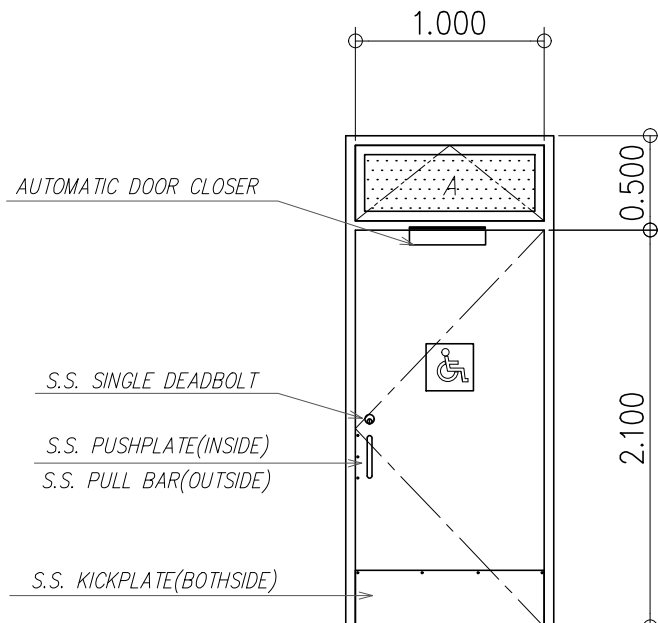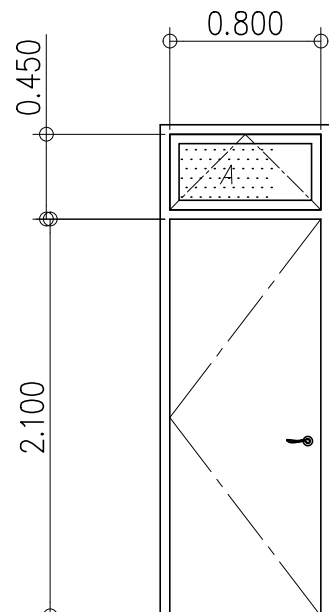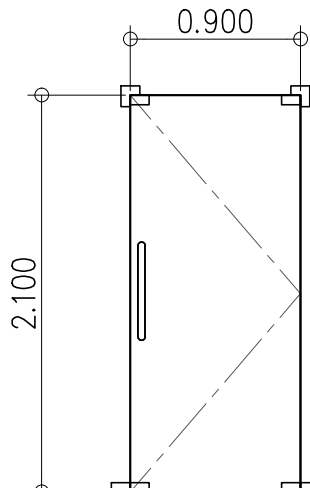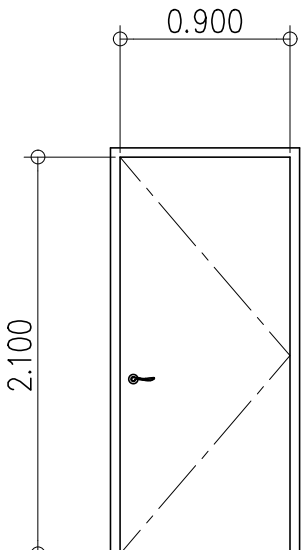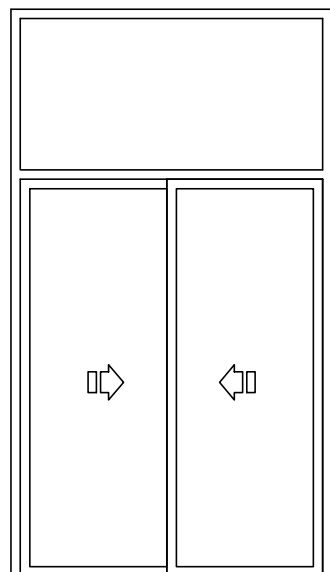



D1		D2		D3		D4		D5	
DOOR TYPE :	2-LEAF DOUBLE SLIDING GLASS DOOR w/TRANSOM WINDOW	STL. FLUSHED FIRE RATED SWING DOOR		FRAMELESS GLASS SWING DOOR		WOODEN FLUSH DOOR w/AWNING TRANSOM WINDOW		WOODEN FLUSH DOOR w/AWNING TRANSOM WINDOW	
FRAME :	EXTRUDED ALUMINUM	STL. TUBULAR				K.D. WD.		K.D. WD.	
GLAZING/PANEL:	6mm THK. REFLECTIVE TEMPERED GLASS (SILVER MIRROR)	Ga.#20 P.P.G.I. /INSULATION		12mm THK. TEMPERED CLEAR GLASS		MARINE PLYWOOD		MARINE PLYWOOD	
FINISH :	POWDERCOATED FINISH (BLACK)	POWDERCOATED							
JAMB :	EXTRUDED ALUMINUM	L.G. STEEL DOOR JAMB				DUCCO FINISH 2"x5" S4S K.D. WD.		DUCCO FINISH 2"x5" S4S K.D. WD.	
HINGES/TRACK :	DOUBLE SWING FLOOR/TRANSOM CLOSER HINGES	H.D. BUTT HINGES		S.S. SWING DOOR PATCH FITTINGS		3 - BUTT HINGES		3 - BUTT HINGES	
LOCK :	GLASS DOOR DEADBOLT LOCKSET	LEVER TYPE LOCKSET		SWING GLASS DOOR LOCKSET		LEVER TYPE LOCKSET		SINGLE DEAD BOLT	
ACCESSORIES :	FLUSH BOLT ON 1-LEAF			S.S. PULL BAR (BOTH SIDE)		AUTOMATIC DOOR CLOSER, GENDER S.S. SIGNAGE		AUTOMATIC DOOR CLOSER, PWD S.S. SIGNAGE	
LOCATION :	TOURIST WAITING AREA	ELECTRICAL ROOM		SOUVENIR SHOP, TOURISM OFFICE & CULTURAL ARTS OFFICE		MALE & FEMALE TOILETS		S.S. PUSHPLATE & PULLBAR,S.S. KICKPLATE	
QUANTITY :	ONE (1) SET	ONE (1) SET				FOUR (4) SETS		TWO (2) SETS	

1ST FIN. FLR. LINE

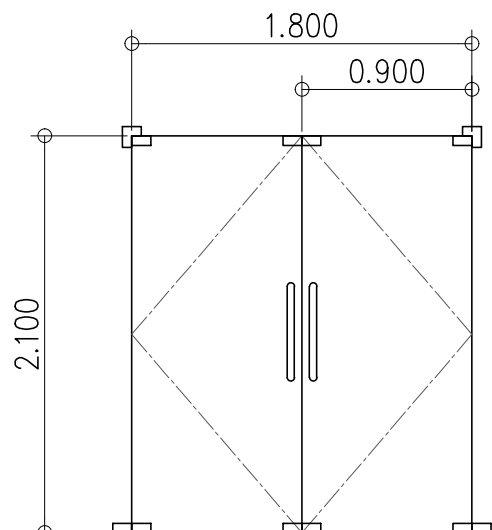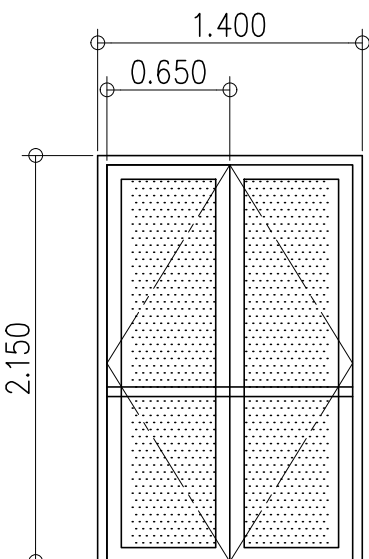


LEGEND :
F = FIXED GLASS
A = AWNING PANEL
S = SLIDING PANEL
C = CASEMENT PANEL

1ST FIN. FLR. LINE

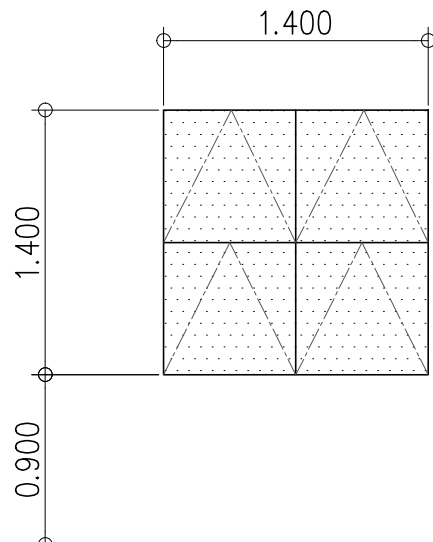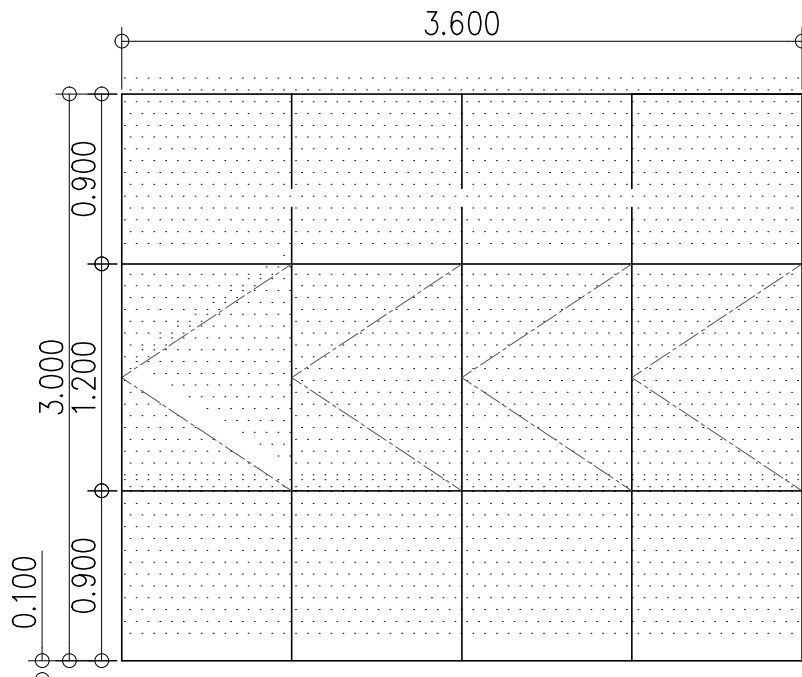

D6		D7		W1		W2	
DOOR TYPE :	DOUBLE SWING GLASS DOOR	2-LEAF FRAMELESS GLASS SWING DOOR		WINDOW TYPE:	CURTAIN WALL CASEMENT WINDOW	SEAMLESS WALL AWNING WINDOW	
FRAME :	ALUMINUM			FRAME:	ALUMINUM	ALUMINUM	
GLAZING/PANEL:	6mm CLEAR TEMPERED GLASS	12mm THK. TEMPERED CLEAR GLASS		FINISH:	POWDERCOATED (BLACK)	POWDERCOATED (BLACK)	
FINISH :	POWDERCOATED			GLAZING/VENT:	6mm THK. REFLECTIVE TEMPERED GLASS	6mm THK. REFLECTIVE TEMPERED GLASS	
JAMB :	ALUMINUM			ACCESORIES:	CASEMENT G.I. WIRE MESH INSECT SCREEN	SLIDING G.I. WIRE MESH INSECT SCREEN	
HINGES/TRACK :	FLOOR & HEADER SPRING HINGES	S.S. SWING DOOR PATCH FITTINGS		LOCATION:	SOUVENIR SHOP & CULTURAL ARTS AREA	TOURISM OFFICE & CULTURAL ARTS OFFICE	
LOCK :	GLASS DOOR LOCKSET	SWING GLASS DOOR LOCKSET					
ACCESSORIES :		S.S. PULL BAR (BOTH SIDE)		QUANTITY:		FOUR (4) SETS	
LOCATION :	SK FEDERATION HALL ENTRANCE	2F BALCONY				TWO (2) SETS	
QUANTITY :	ONE (1) SET	ONE (1) SET					

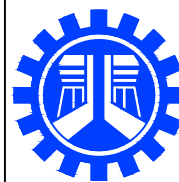

REPUBLIC OF THE PHILIPPINES
DEPARTMENT OF PUBLIC WORKS AND HIGHWAYS
REGIONAL OFFICE No. IV-A
BATANGAS 2ND DISTRICT ENGINEERING OFFICE
KUMINTANG ILAYA, BATANGAS CITY

PROJECT TITLE / LOCATION :

C.Y. 2025 PROJECT
CONVERGENCE AND SPECIAL SUPPORT PROGRAM,
BASIC INFRASTRUCTURE PROGRAM (BIP),
MULTI-PURPOSE BUILDINGS/FACILITIES TO SUPPORT SOCIAL SERVICES,
CONSTRUCTION OF MULTI-PURPOSE BUILDING
(TINGLOY MUNICIPAL TOURISM AND CULTURAL ARTS BUILDING) ,
AT TINGLOY, BATANGAS

DRAWN & PREPARED BY:

JACINTO T. MACARAIG
ARCHITECT II

DATE :

REVIEWED & SUBMITTED :

GEMMA L. OLAN
CHIEF, PLANNING & DESIGN SECTION

DATE :

RECOMMENDED :

ARIEL V. ARMEDILLA
ASSISTANT DISTRICT ENGINEER

DATE :

APPROVED :

SONIA D. PAGLICAUAN
DISTRICT ENGINEER

DATE :

DESIGN BY :

ARCHITECT OF RECORD

PRC No.

VALIDITY :

PIR No.

DATE ISSUED :

PLACE ISSUED:

TIN :





SHEET CONTENT :

SHEET NO.:





SCHEDULE OF DOORS & WINDOWS

A-4

LEGEND :
F = FIXED GLASS
A = AWNING PANEL
S = SLIDING PANEL
C = CASEMENT PANEL

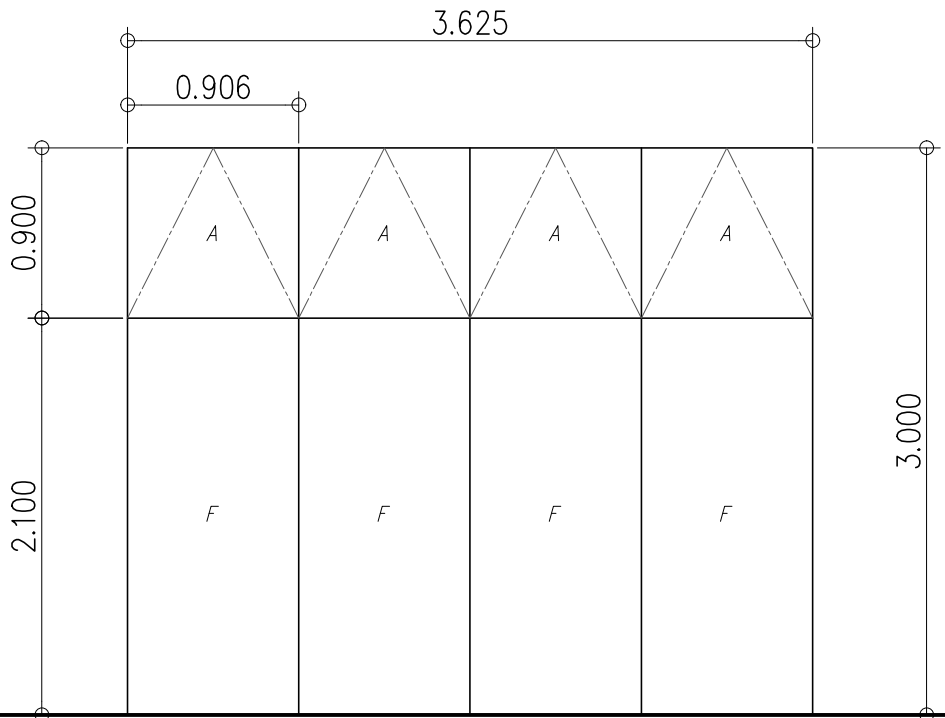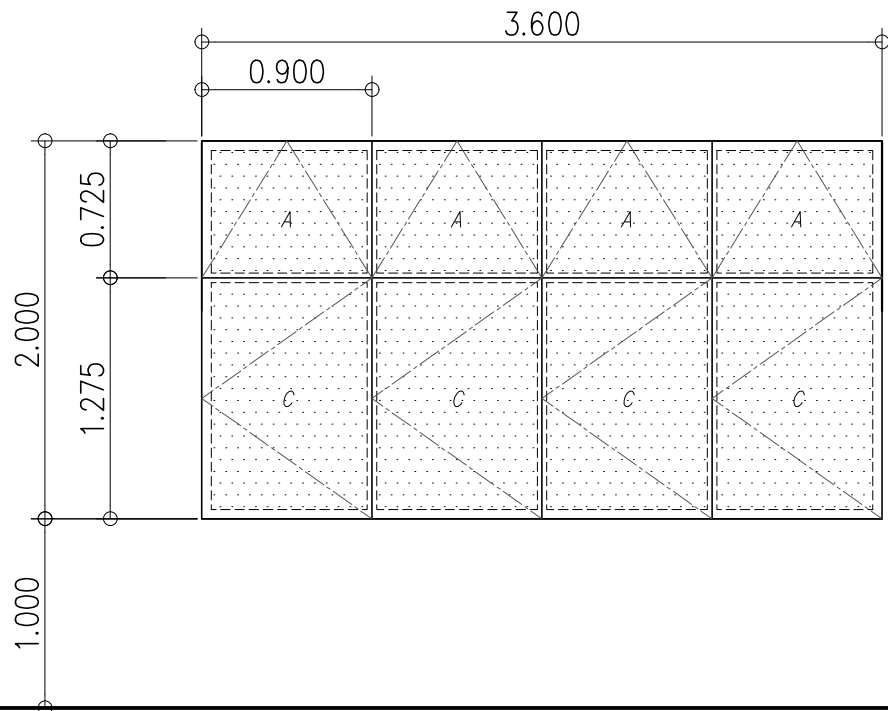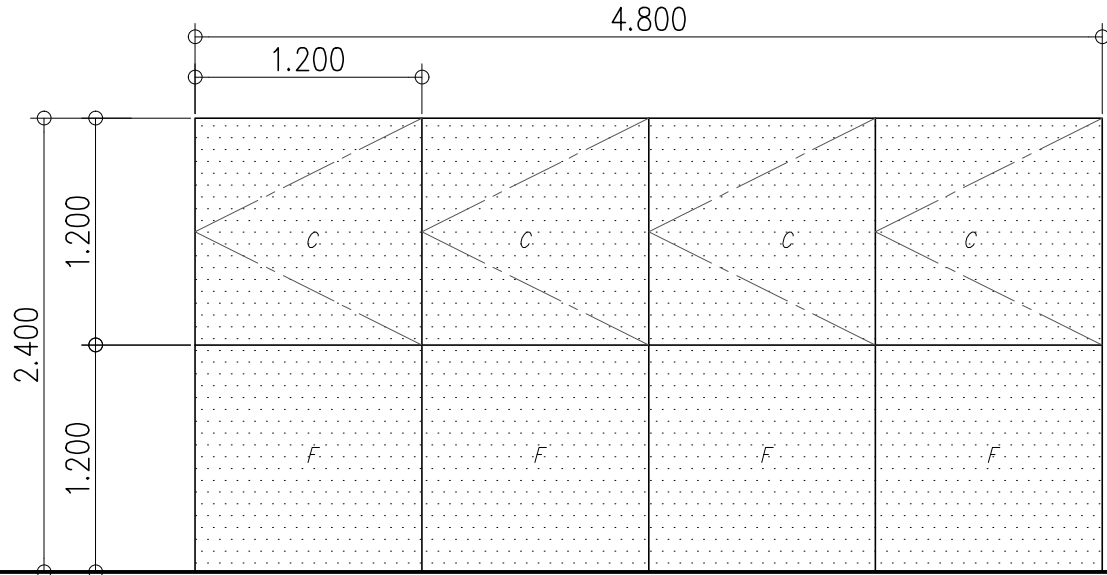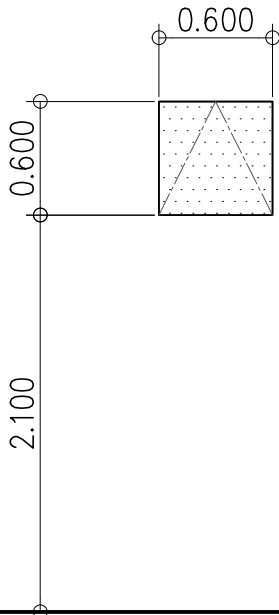


W3		W4		W5		W6	
WINDOW TYPE:	SEAMLESS WALL AWNING WINDOW	CURTAIN WALL CASEMENT WINDOW		CURTAIN WALL CASEMENT/AWNING WINDOW		CURTAIN WALL AWNING WINDOW	
FRAME:	ALUMINUM	ALUMINUM		ALUMINUM		ALUMINUM	
FINISH:	POWDERCOATED (BLACK)	POWDERCOATED (BLACK)		POWDERCOATED (BLACK)		POWDERCOATED (BLACK)	
GLAZING/VENT:	6mm THK. REFLECTIVE TEMPERED GLASS	6mm THK. REFLECTIVE TEMPERED GLASS		6mm THK. REFLECTIVE TEMPERED GLASS		6mm THK. REFLECTIVE TEMPERED GLASS	
ACCESORIES:	SLIDING G.I. WIRE MESH INSECT SCREEN	CASEMENT G.I. WIRE MESH INSECT SCREEN		CASEMENT G.I. WIRE MESH INSECT SCREEN		CASEMENT G.I. WIRE MESH INSECT SCREEN	
LOCATION:	TOURISM OFFICE & CULTURAL ARTS OFFICE	SOUVENIR SHOP & CULTURAL ARTS AREA		SOUVENIR SHOP & CULTURAL ARTS AREA		SOUVENIR SHOP & CULTURAL ARTS AREA	
QUANTITY:	TWO (2) SETS	FOUR (4) SETS		FOUR (4) SETS		ONE (1) SET	

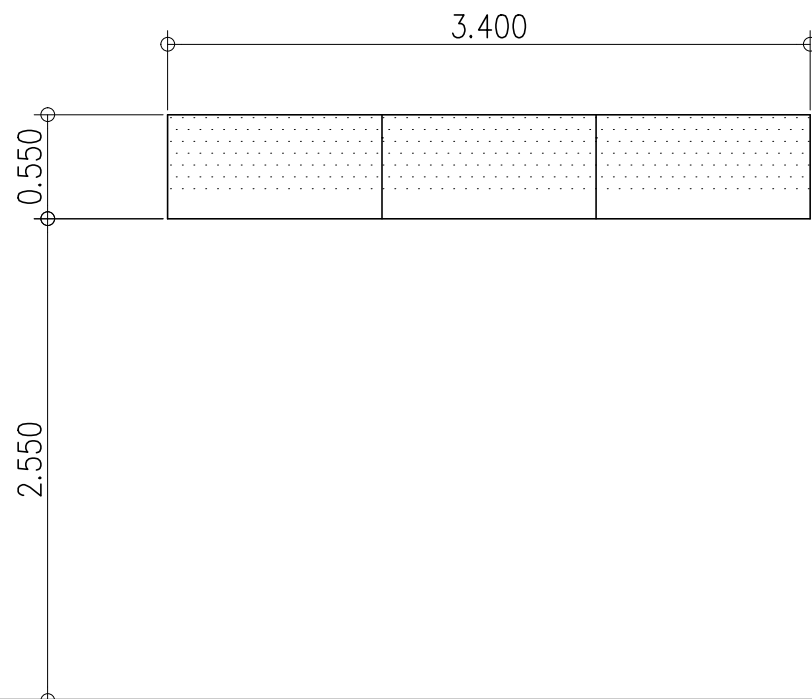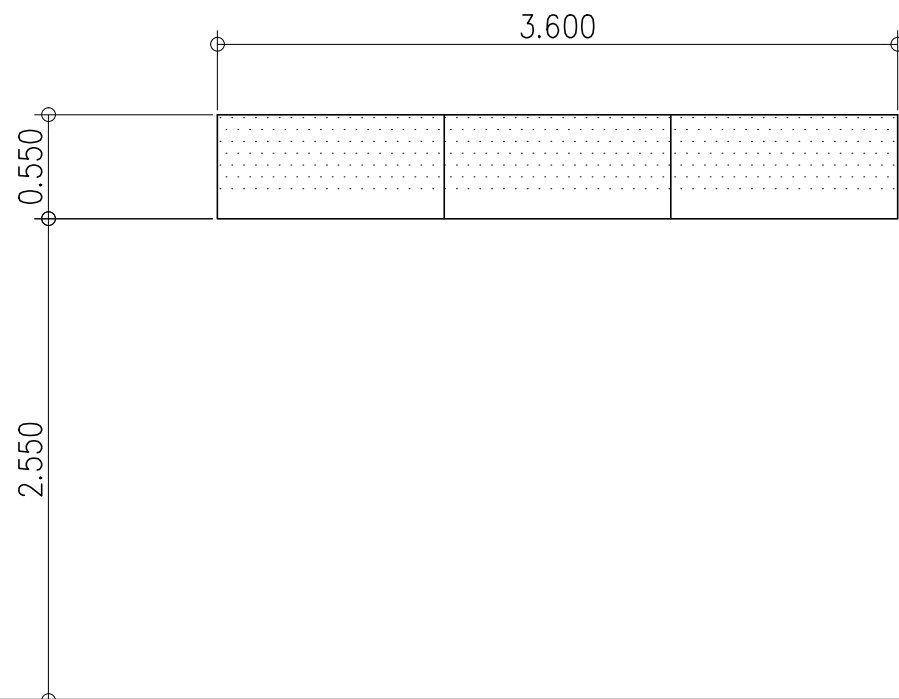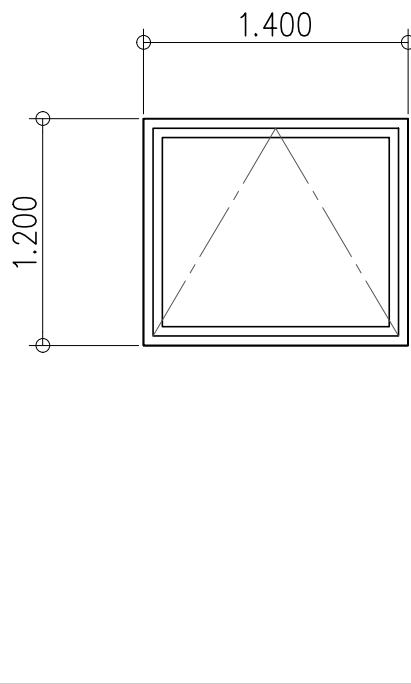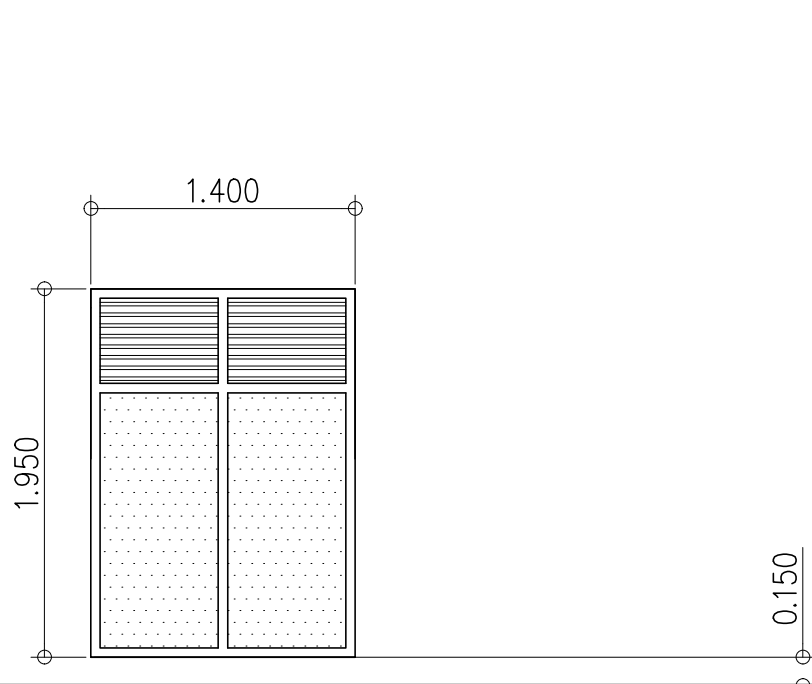


W7		W8		W8		W9	
WINDOW TYPE:	FIXED GLASS WINDOW w/LOUVER	AWNING WINDOW		FIXED WINDOW		FIXED WINDOW	
FRAME:	ALUMINUM	ALUMINUM		ALUMINUM		ALUMINUM	
FINISH:	POWDERCOATED (BLACK)	POWDERCOATED (BLACK)		POWDERCOATED (BLACK)		POWDERCOATED (BLACK)	
GLAZING/VENT:	6mm THK. REFLECTIVE TEMPERED GLASS	6mm THK. REFLECTIVE TEMPERED GLASS		6mm THK. REFLECTIVE TEMPERED GLASS		6mm THK. REFLECTIVE TEMPERED GLASS	
ACCESORIES:	6a.#24 BENDED P.P.G.I. LOUVER BLADES	SLIDING G.I. WIRE MESH INSECT SCREEN		TOURIST WAITING AREA		TOURIST WAITING AREA	
LOCATION:	STAIRWELL	CULTURAL ARTS AREA		TOURIST WAITING AREA		TOURIST WAITING AREA	
QUANTITY:	ONE (1) SET	ONE (1) SET		TWO (2) SETS		ONE (1) SET	

 REPUBLIC OF THE PHILIPPINES DEPARTMENT OF PUBLIC WORKS AND HIGHWAYS REGIONAL OFFICE No. IV-A BATANGAS 2ND DISTRICT ENGINEERING OFFICE KUMINTANG ILAYA, BATANGAS CITY	PROJECT TITLE / LOCATION : C.Y. 2025 PROJECT CONVERGENCE AND SPECIAL SUPPORT PROGRAM, BASIC INFRASTRUCTURE PROGRAM (BIP), MULTI-PURPOSE BUILDINGS/FACILITIES TO SUPPORT SOCIAL SERVICES, CONSTRUCTION OF MULTI-PURPOSE BUILDING (TINGLOY MUNICIPAL TOURISM AND CULTURAL ARTS BUILDING) , AT TINGLOY, BATANGAS	DRAWN & PREPARED BY: JACINTO T. MACARAIG ARCHITECT II DATE :	REVIEWED & SUBMITTED : GEMMA L. OLAN CHIEF, PLANNING & DESIGN SECTION DATE :	RECOMMENDED : ARIEL V. ARMEDILLA ASSISTANT DISTRICT ENGINEER DATE :	APPROVED : SONIA D. PAGLICAUAN DISTRICT ENGINEER DATE :	ARCHITECT OF RECORD	
						PRC No. VALIDITY :	
						PTR No. DATE ISSUED :	
						PLACE ISSUED: TIN :	
						SHEET CONTENT :	SHEET NO.:
						SCHEDULE OF WINDOWS	A-5

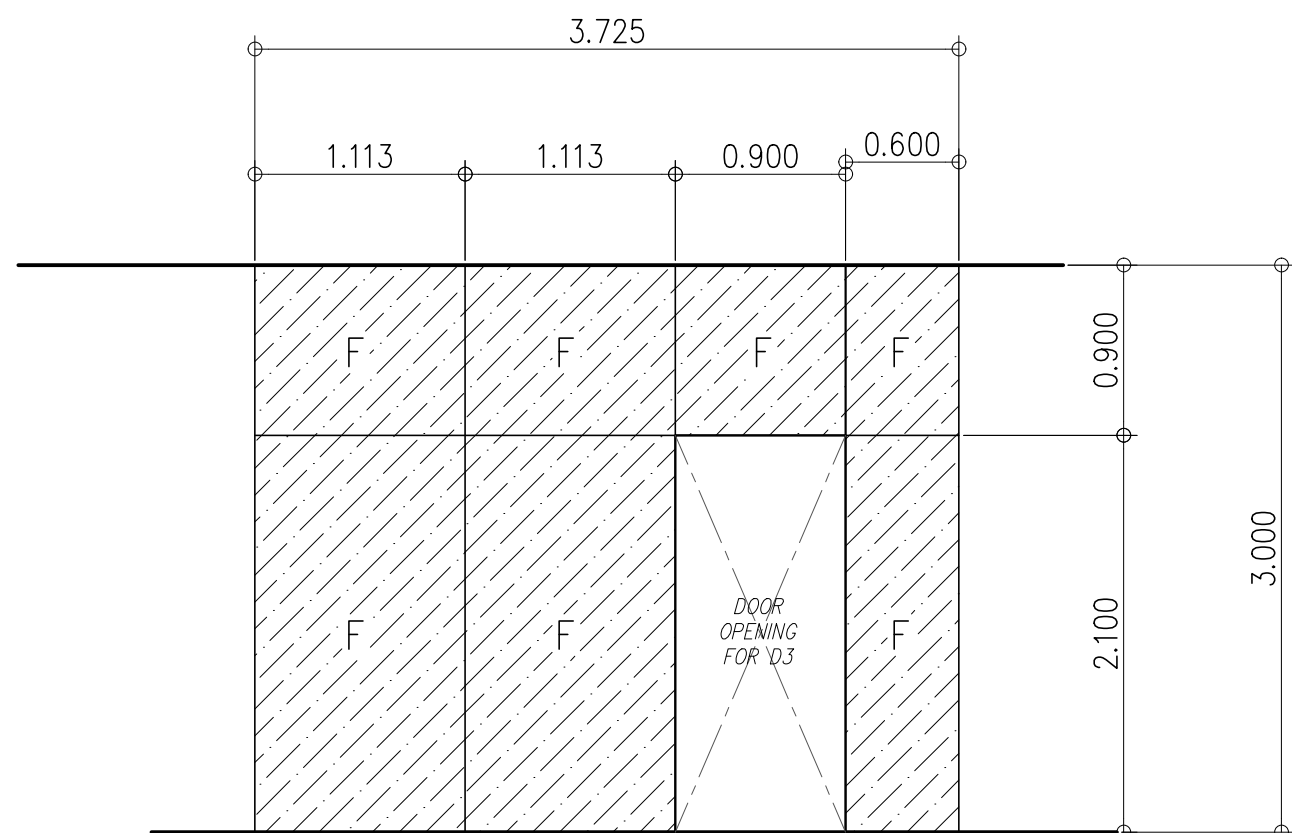


WP-1

10mm THK. REFLECTIVE TEMPERED GLASS

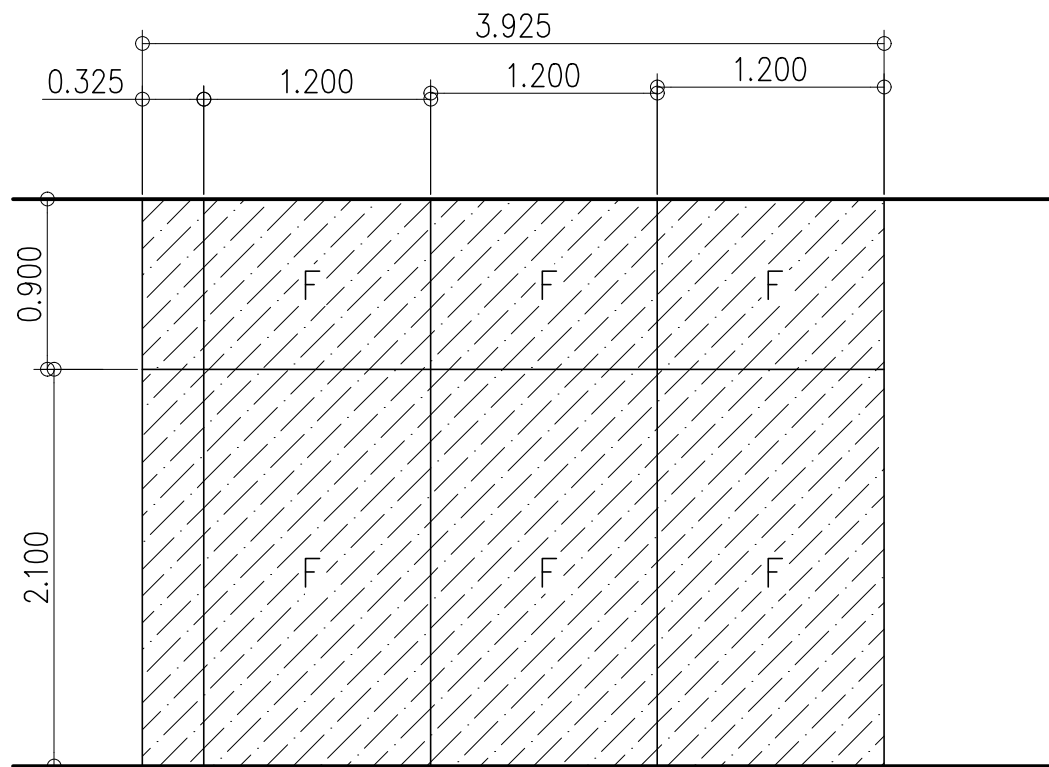

WP-2

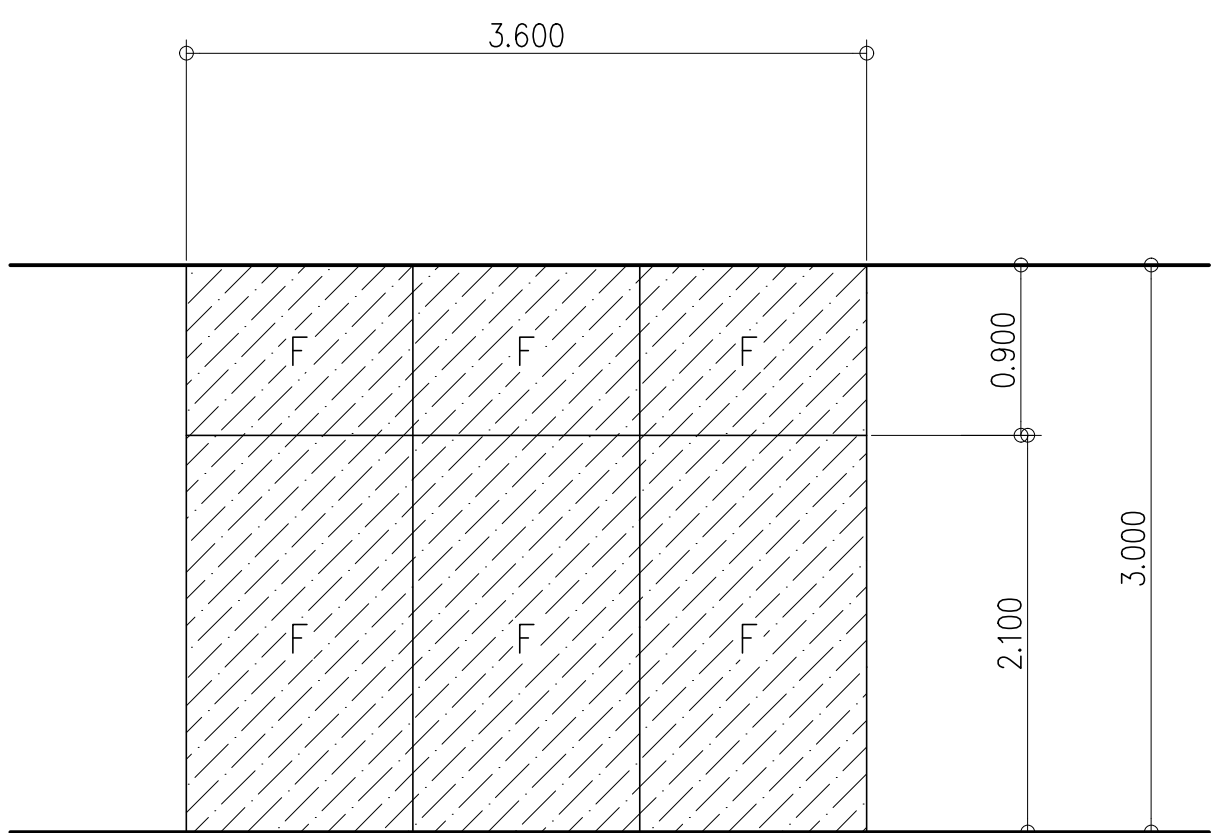

WP-4


10mm THK. REFLECTIVE TEMPERED GLASS

1
A-4


FRAMELESS GLASS WALL PARTITION ELEVATION

SCALE

1 : 40 MTS.

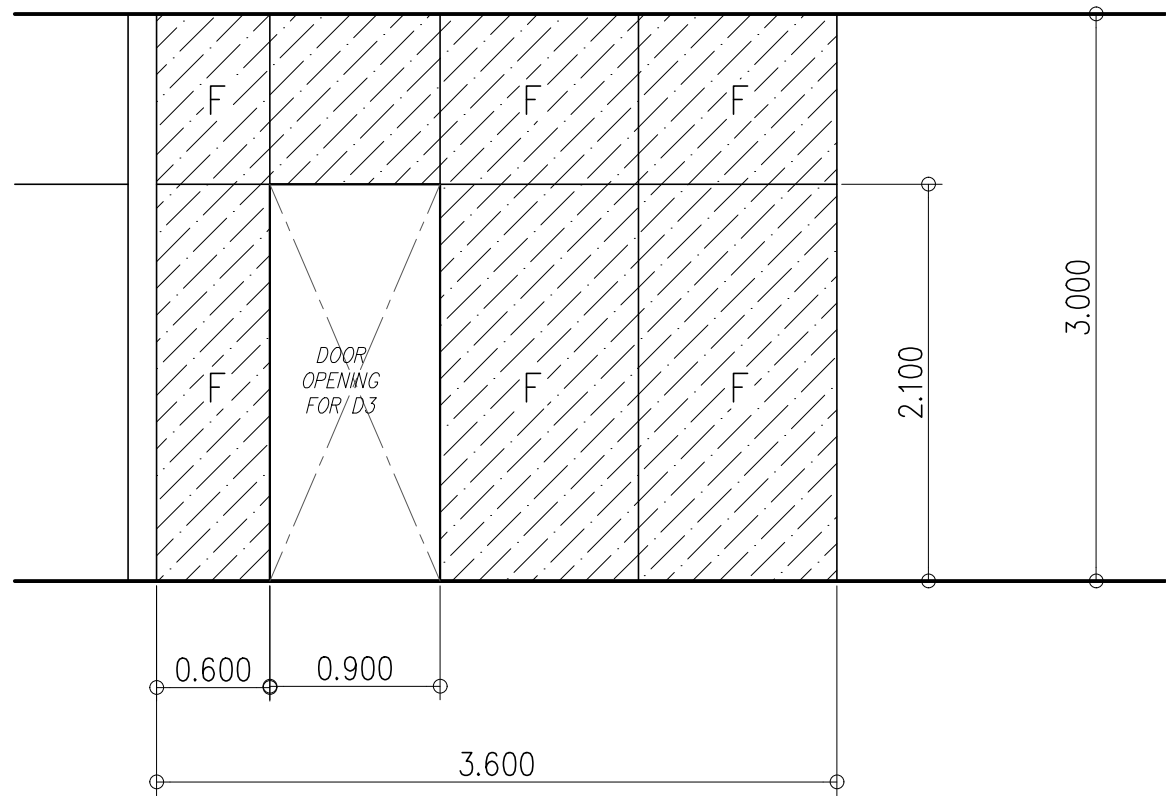

WP-3

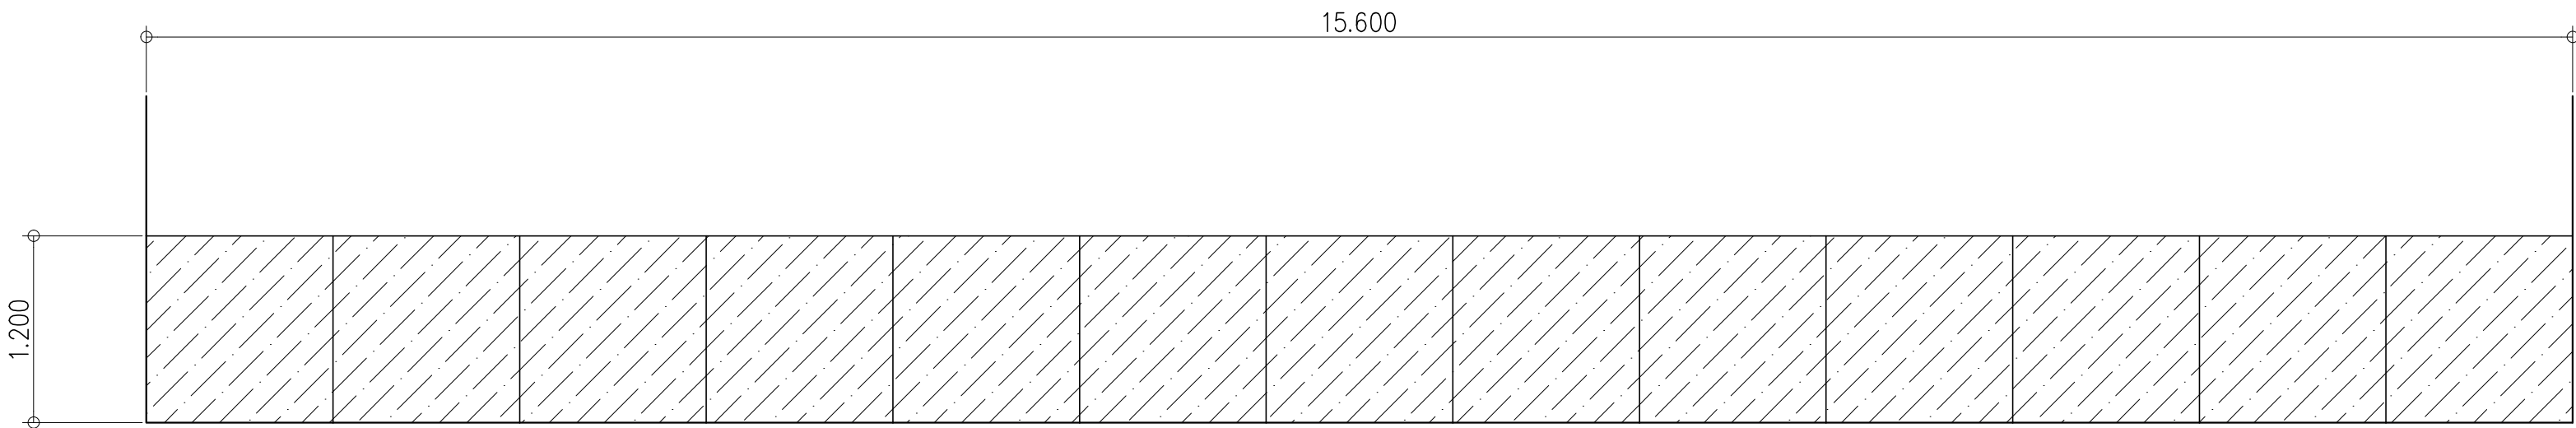

GR-1

1
A-4

FRAMELESS GLASS BALCONY GUARD RAIL/BALUSTRADE

SCALE

1 : 40 MTS.



REPUBLIC OF THE PHILIPPINES
DEPARTMENT OF PUBLIC WORKS AND HIGHWAYS
REGIONAL OFFICE No. IV-A
BATANGAS 2ND DISTRICT ENGINEERING OFFICE
KUMINTANG ILAYA, BATANGAS CITY

PROJECT TITLE / LOCATION :

C.Y. 2025 PROJECT
CONVERGENCE AND SPECIAL SUPPORT PROGRAM,
BASIC INFRASTRUCTURE PROGRAM (BIP),
MULTI-PURPOSE BUILDINGS/FACILITIES TO SUPPORT SOCIAL SERVICES,
CONSTRUCTION OF MULTI-PURPOSE BUILDING
(TINGLOY MUNICIPAL TOURISM AND CULTURAL ARTS BUILDING) ,
AT TINGLOY, BATANGAS

DRAWN & PREPARED BY:

JACINTO T. MACARAIG
ARCHITECT II

DATE :

REVIEWED & SUBMITTED :

GEMMA L. OLAN
CHIEF, PLANNING & DESIGN SECTION

DATE :

RECOMMENDED :

ARIEL V. ARMEDILLA
ASSISTANT DISTRICT ENGINEER

DATE :

APPROVED :

SONIA D. PAGLICAUAN
DISTRICT ENGINEER

DATE :

DESIGN BY :

ARCHITECT OF RECORD

PRC No.

VALIDITY :

PTR No.

DATE ISSUED :

PLACE ISSUED:

TIN :

SHEET CONTENT :

FRAMELESS GLASS WALL
PARTITION ELEVATION
FRAMELESS GLASS BALCONY
ELEVATION

SHEET NO.:

A-6