

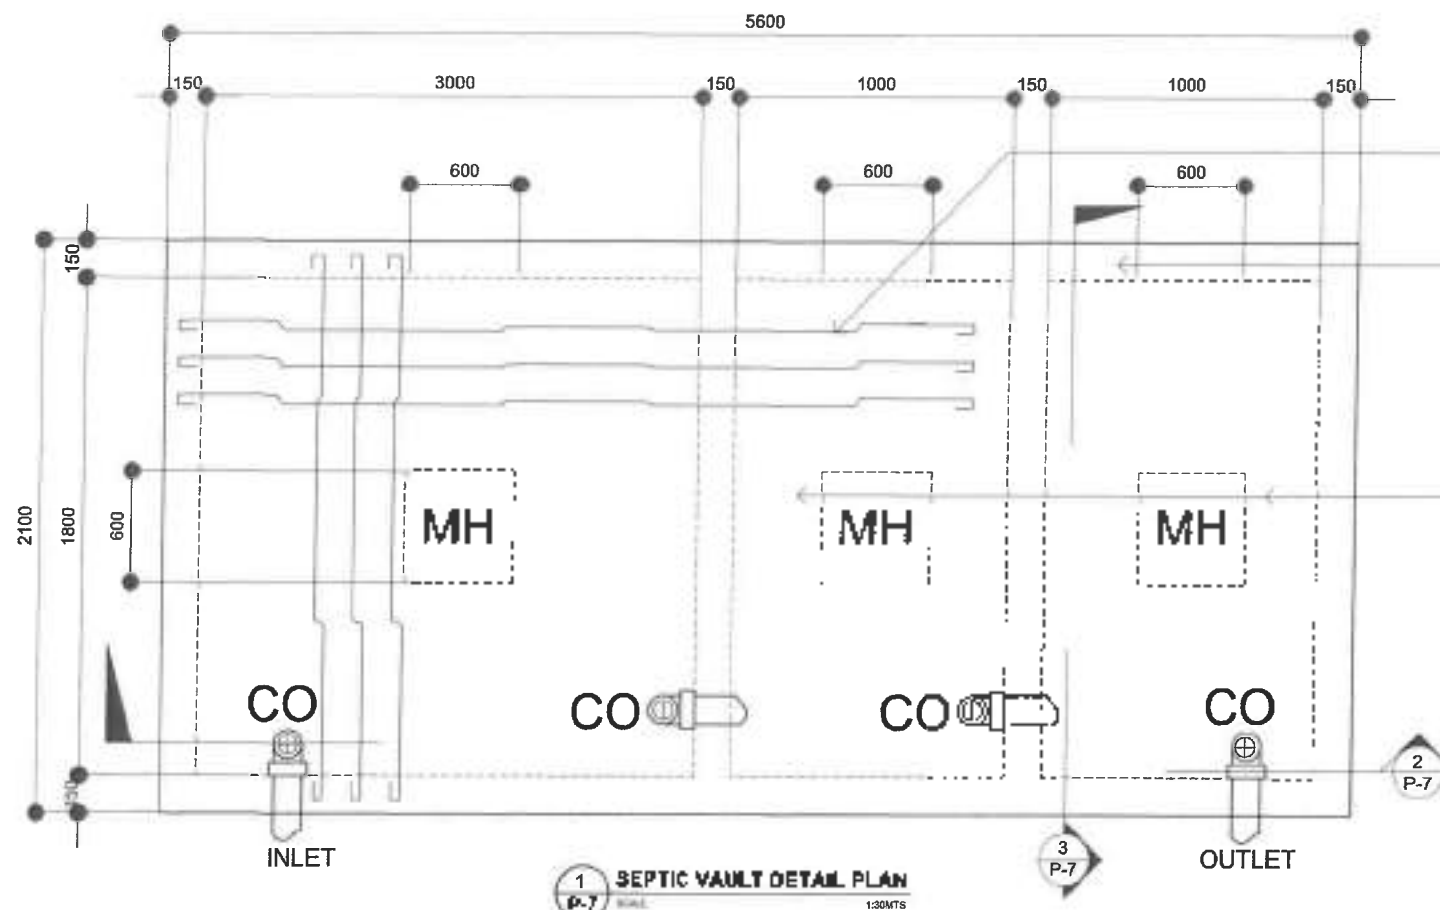


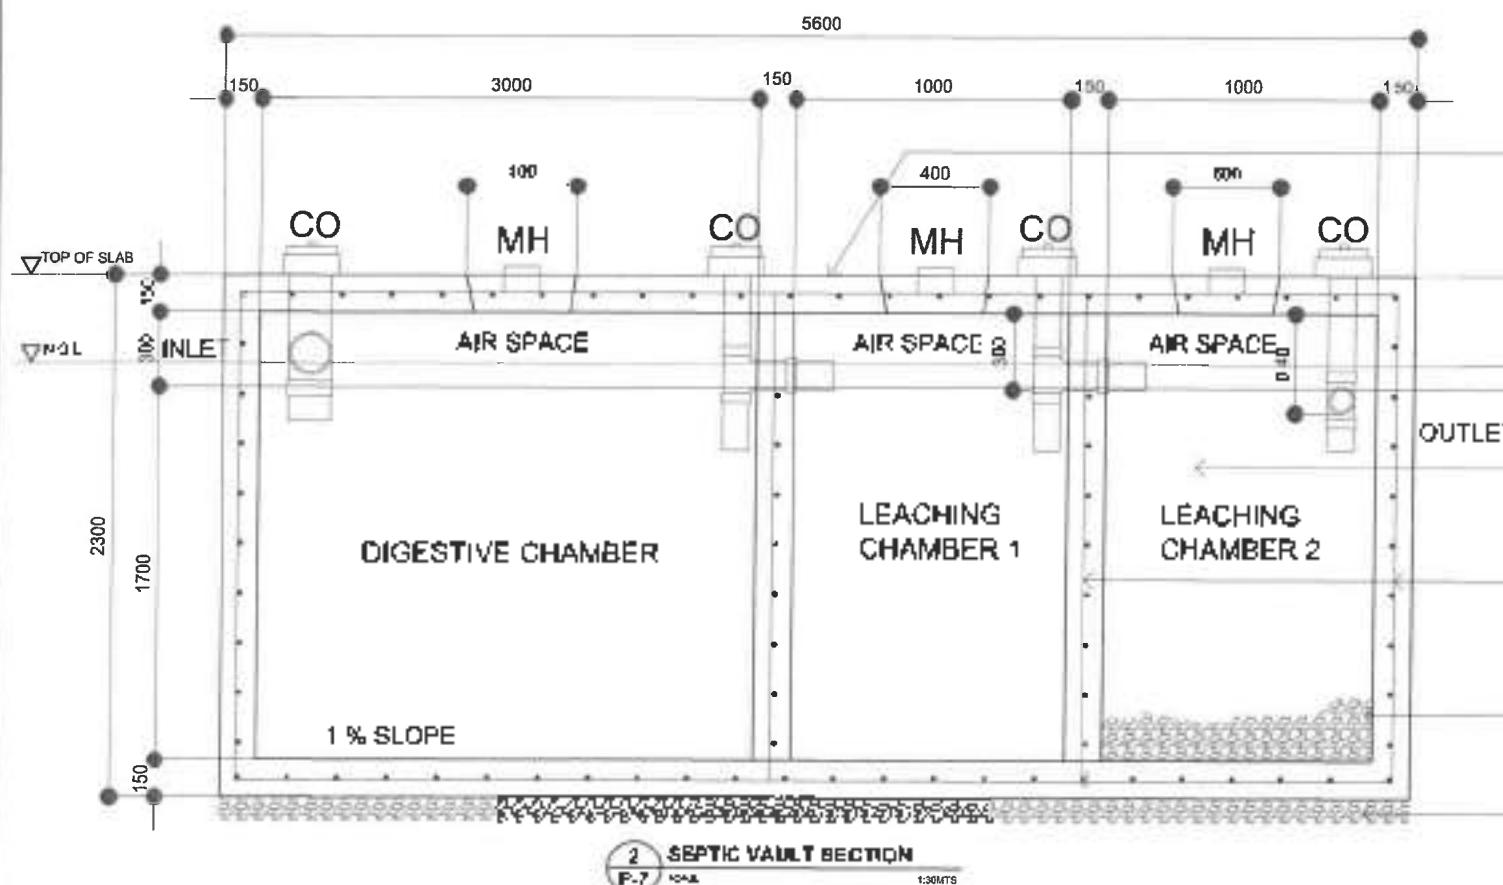

2-10mmØ EXTRA BARS
TOP/BOTTOM ON TWO
PARALLEL SIDE

S-2 150mm THK + FIN. SLAB
w/ 10mm REBARS @300mm
OC BENT UP 2/3 OUT @L/4
FROM FACE SUPPORT
BOTHWAYS

S-1a 150mm THK + FIN. SLAB
w/ 10mm REBARS @300mm
OC BENT UP 2 OUT OF 3 @L/4
FROM FACE SUPPORT
BOTHWAYS

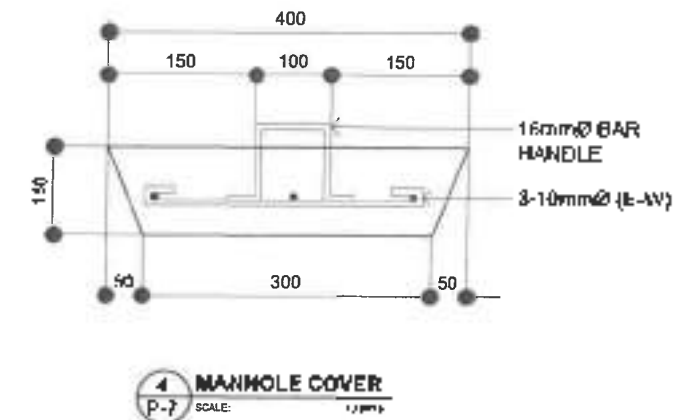


150mm THK FIN. FIN. SLAB
w/ 10mmØ REBARS @ 300mm
OC BENT UP 2 OUT OF 3 AT L/4
FROM FACE SUPPORT
BOTHWAYS

PLASTERED w/ WATERPROOFING
COMPOUND OR APPLY ONE
FACE BITUMEN TAP

WALL REINFORCEMENT
10mmØ VERT. OR HOR. BAR
@ 200mm OC BW

CONCRETE WALL w/ HOT
APPLIED ASPHALT
WATERPROOFING
(INSIDE FACE)

100mm THK GRAVEL
SPRING

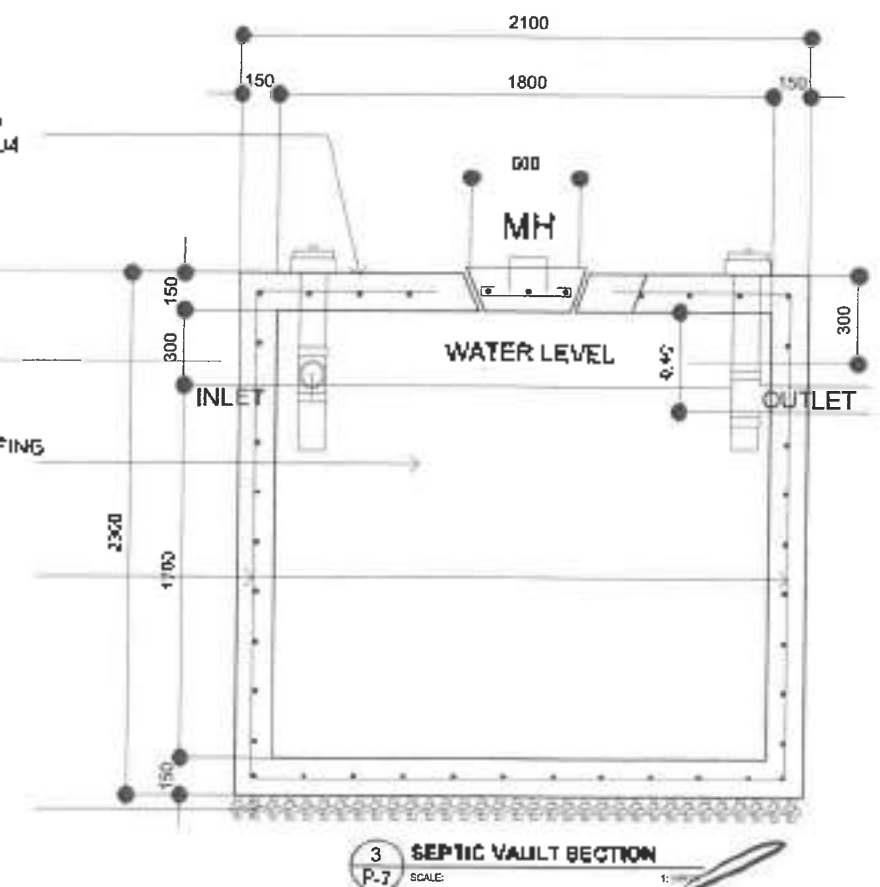

Republic of the Philippines
DEPARTMENT OF PUBLIC WORKS AND HIGHWAYS
Regional Office No. 8
NORTHERN SAMAR FIRST
DISTRICT ENGINEERING OFFICE
Calbayog, Northern Samar

PROJECT NAME & LOCATION
CONSTRUCTION OF MULTIPURPOSE FACILITY,
(COVERED COURT) BARANGAY SAN JOSE
LAVERGAS, NORTHERN SAMAR
Luzon, Northern Samar

SHEET CONTENTS:
DETAIL OF SEPTIC VAULT
(SECTION OF SEPTIC VAULT)
MANHOLE COVER

PREPARED BY
BARTOLOME LUCIANO
NCE-10111
Date

REVIEWED BY
ANDY S. ERENO
NCE-10111
Date

SUBMITTED BY
ANDY S. ERENO
NCE-10111
Date

RECEIVED BY
ANDY S. ERENO
NCE-10111
Date

APPROVED BY
ALVIN A. KINACHO
NCE-10111
Date

SHEET No.
32
42

SCHEDULE OF LOADS

[illegible]


GENERAL NOTES

1. ALL ELECTRICAL WORKS SHALL COMPLY WITH THESE PLANS AND SPECIFICATIONS. THE APPLICABLE PROVISION OF THE LATEST EDITION OF THE PHILIPPINE ELECTRICAL CODE (PEC), THE RULES AND REGULATIONS OF THE LOCAL ENFORCING AUTHORITY AND THE REQUIREMENTS OF THE LOCAL POWER COMPANY
2. THE ELECTRICAL SERVICE POWER SHALL BE 1-PHASE 2-WIRE, 230 AC, 60HZ
3. WIRING METHOD SHALL BE AS FOLLOWS
RIGID STEEL CONDUIT OR POLYVINYL CHLORIDE CONDUIT SCHEDULE 40 SHALL BE USED AS SPECIFIED PLAN
4. ALL WIRES SHALL BE COPPER AND THERMOPLASTIC INSULATED TYPE "THIN" UNLESS OTHERWISE INDICATED IN THE PLAN. THE MINIMUM SIZE WIRE FOR POWER AND LIGHTING CIRCUIT HOMERUNS SHALL BE 3.5mm² AND INSULATED FOR 600VOLTS. LIKE WISE, ALL CONDUCTORS SHALL BE COLOR CODED. SMALLEST RACEWAYS SHALL BE 15mmØ (NOMINAL)
5. ALL OUTLET BOXES SHALL BE GALVANIZED GAGE NO 16 DEEP TYPE.
6. ALL MATERIALS TO BE USED SHALL BE BRAND NEW AND APPROVED FOR THE PARTICULAR LOCATION AND USAGE
7. EQUIPMENT GROUNDING SYSTEM SHALL BE PROVIDED TO THE ELECTRICAL SYSTEM AS PER PHILIPPINE ELECTRICAL CODE REQUIREMENT
8. MOUNTING HEIGHT OF WIRING DEVICES SHALL BE AS FOLLOWS:

a. LIGHT SWITCH	1400mm ABOVE FINISH FLOOR
b. CONVENIENCE OUTLET	400mm ABOVE FINISH FLOOR
c. PANEL BOARD	1800mm ABOVE FINISH FLOOR
9. ALL ELECTRICAL WORKS SHALL BE DONE UNDER THE DIRECT AND IMMEDIATE SUPERVISION OF A DULY REGISTERED ELECTRICAL ENGINEER.


LEGEND:

SYMBOL	DESCRIPTION
	SERVICE ENTRANCE
	SERVICE METER
1Sa	1-GANG SWITCH
2Sab	2-GANG SWITCH
	RACEWAY CONDUIT CONCEALED UNDER FLOOR
	RACEWAY CONDUIT IN CEILING
	LIGHTING AND POWER PANEL/BOARD
	MANUAL TRANSFER SWITCH
	Ckt. Breaker, Rating as Indicated
	15W LED LIGHT BULB w/ 4"x4" Dia. RECEPTACLE w/ E27 Base
	100W LED FLOOD LIGHT
	HomeRun Circuit Direct to Panelboard
	DUPLEX CONVENIENCE OUTLET (WEATHER PROOF)
	JUNCTION BOX
	GENERATOR SET

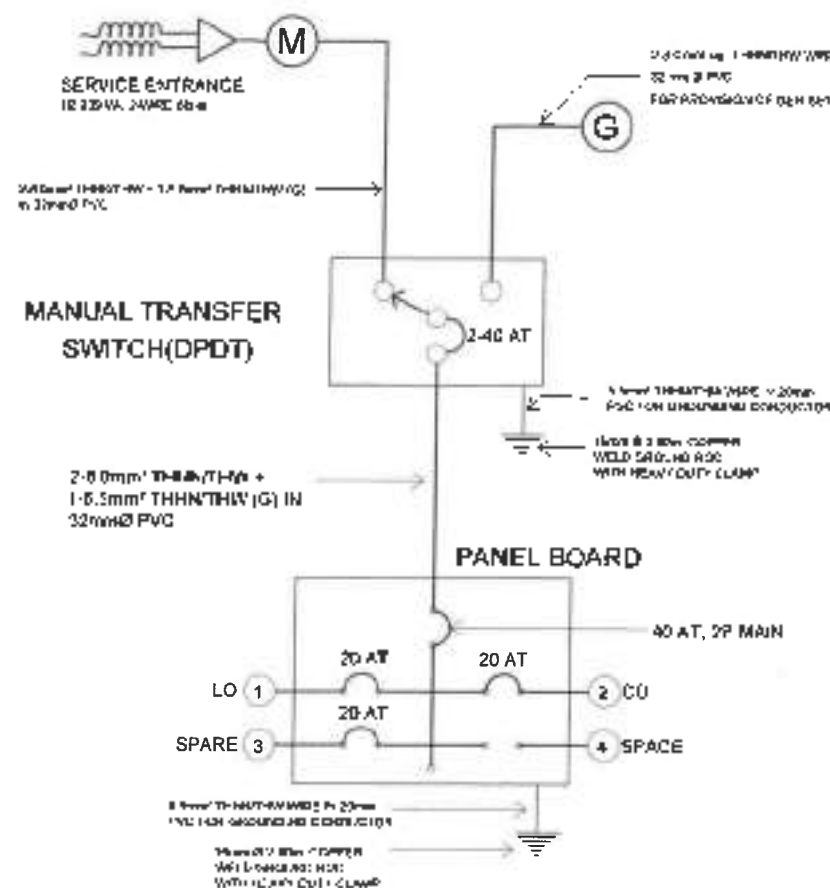


SINGLE LINE DIAGRAM

NOT	TO	SCALE
-----	----	-------

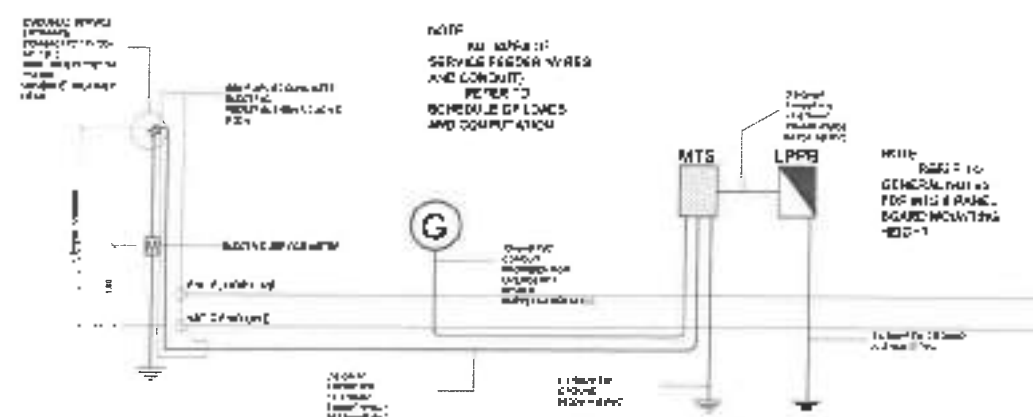


ELECTRICAL RISER DIAGRAM

NOT TO SCALE

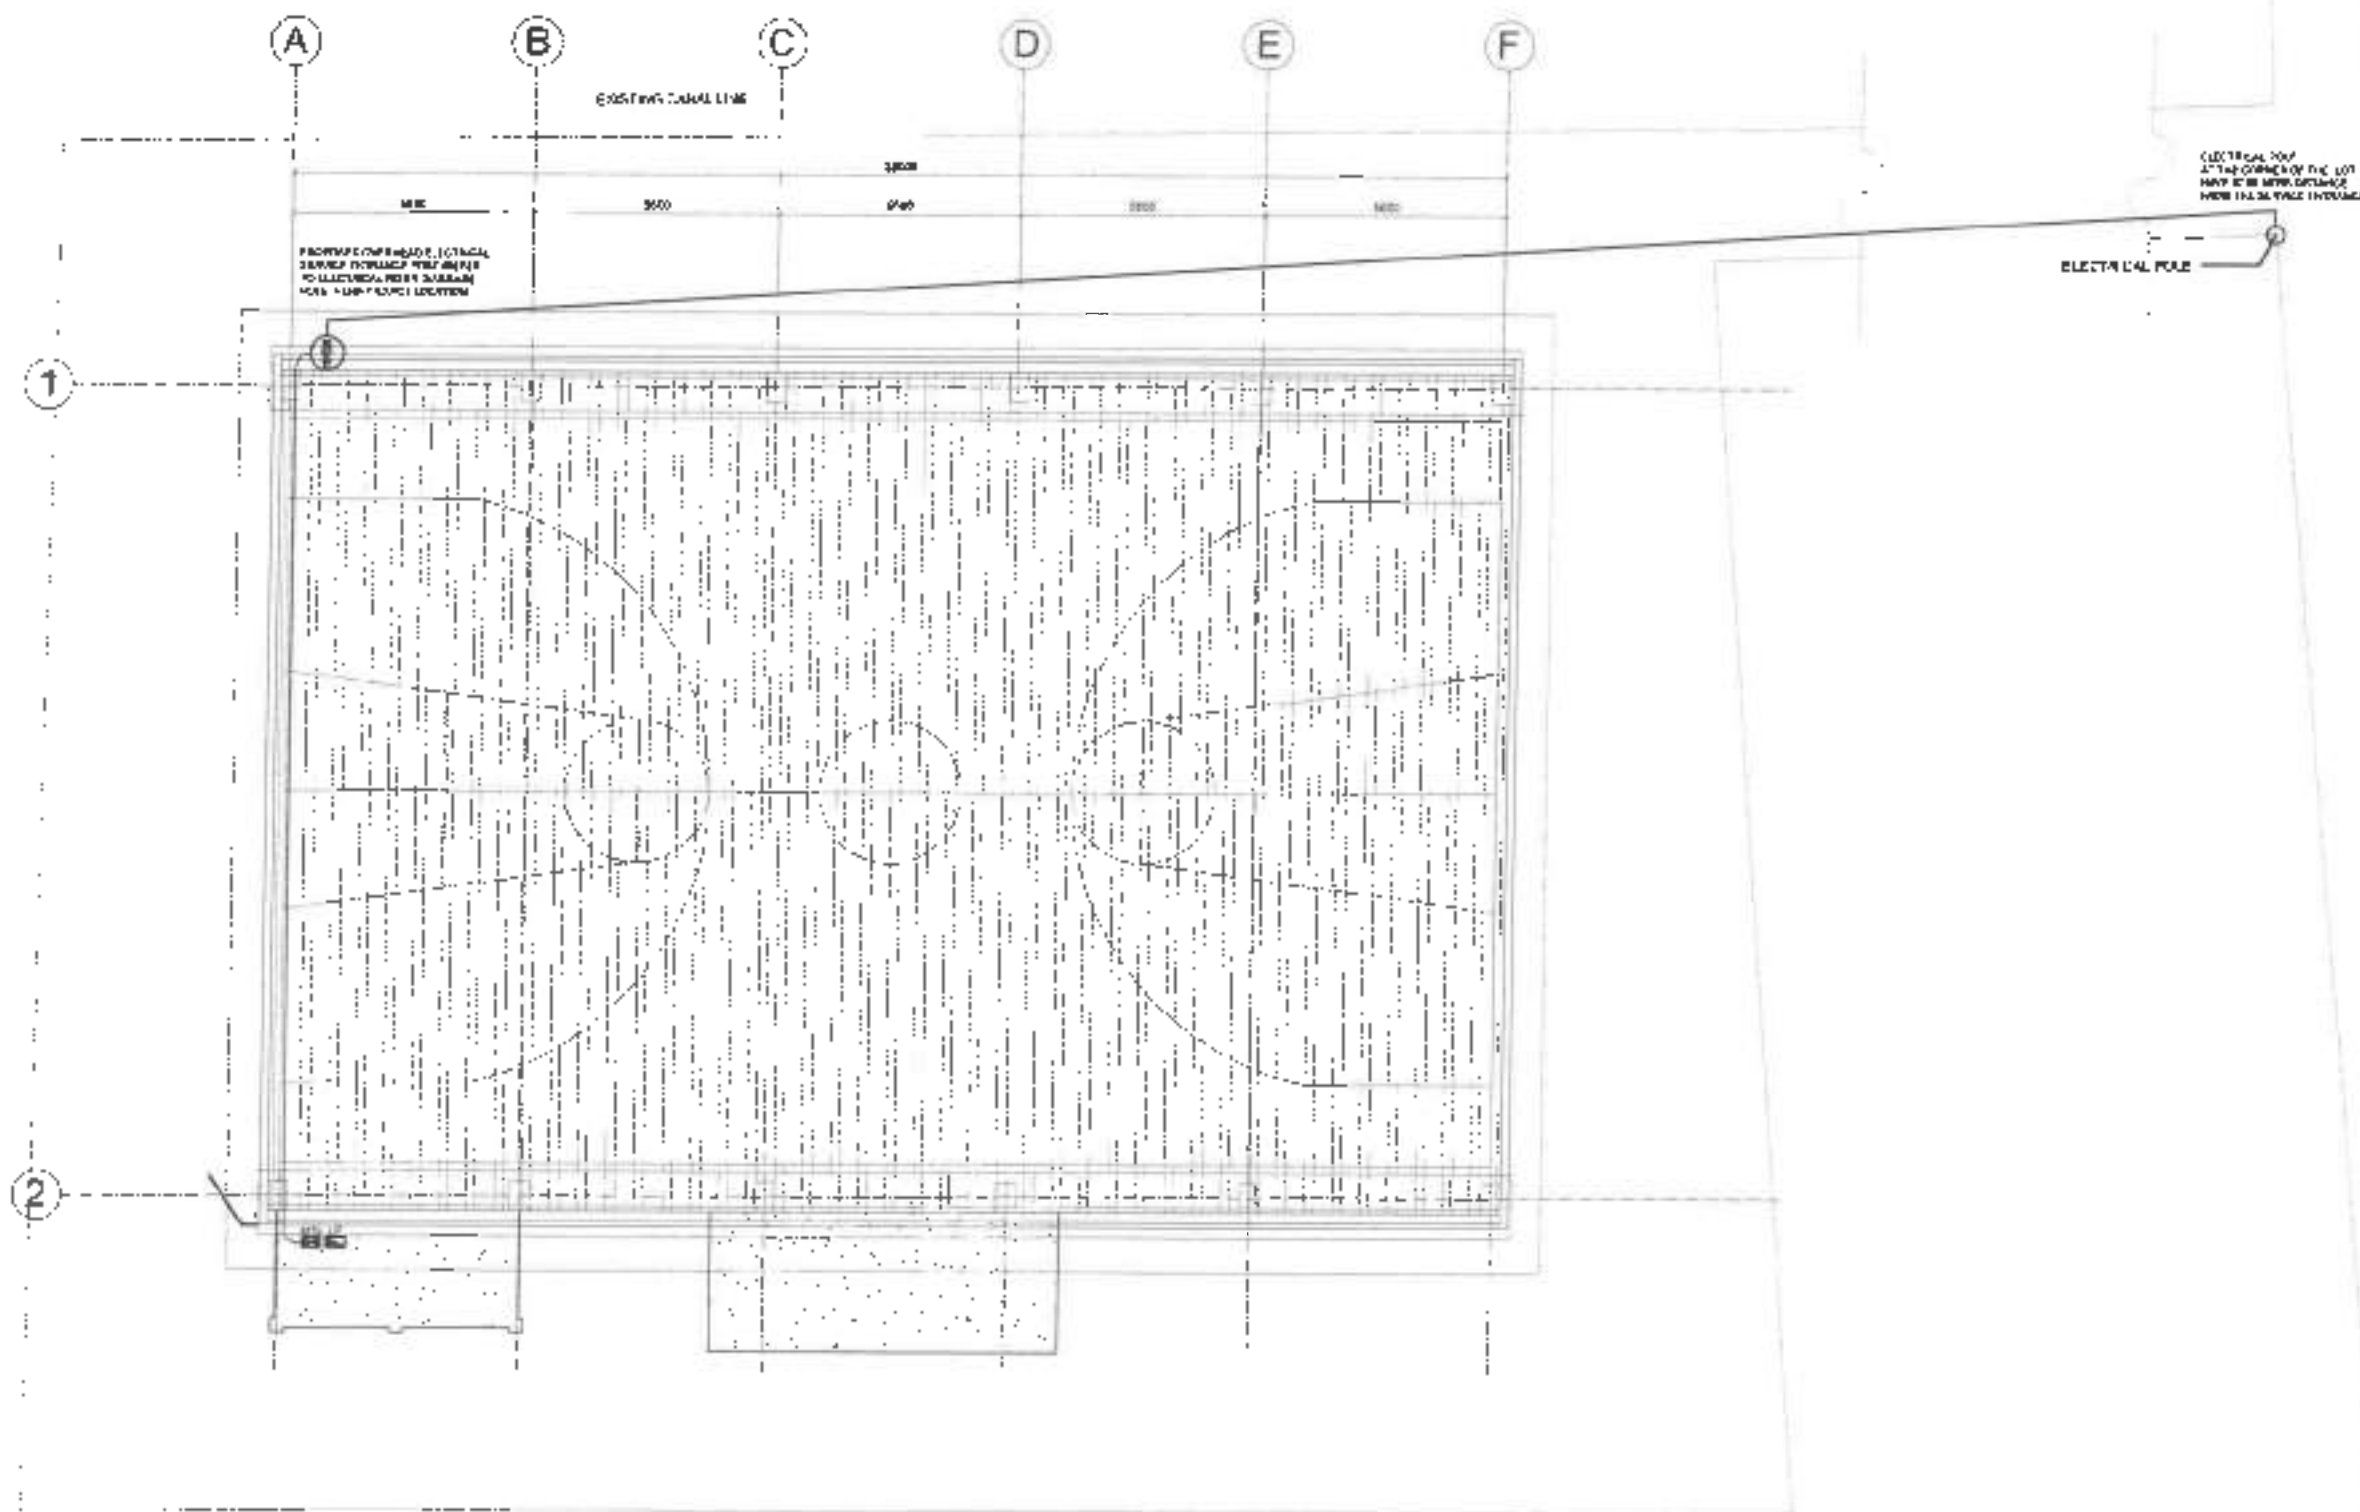

1 SITE DEVELOPMENT PLAN
E-1 SCALE 1:100M

Department of Public Works and Highways Regional Office No. VI NORTHERN SAMAR FIRST DISTRICT ENGINEERING OFFICE Calape, Northern Samar	PROJECT NAME & LOCATION CONSTRUCTION OF MULTIPURPOSE FACILITY, COVERED COURT BARANDAY SAN JOSE LAVERANES, NORTHERN SAMAR	SHEET CONTENTS SITE DEVELOPMENT PLAN	PREPARED: ELYN R. OCAMPO ELECTRONIC SERVICES INC. DESIGNED: MARY JOY L. GORRHO UPVOR	REVIEWED: <i>[Signature]</i> NED DONALD A. BAWAN NED DONALD A. BAWAN NED DONALD A. BAWAN	SUBMITTED: <i>[Signature]</i> ANDY E. ORRHO ANDY E. ORRHO ANDY E. ORRHO	RECOMMENDED: <i>[Signature]</i> VIRMAN C. DIAZ VIRMAN C. DIAZ VIRMAN C. DIAZ	APPROVED: <i>[Signature]</i> ALVIN A. IGACHIO ALVIN A. IGACHIO ALVIN A. IGACHIO	SET No. E-2	SHEET No. 37/42
	DATE: 10/10/2023								

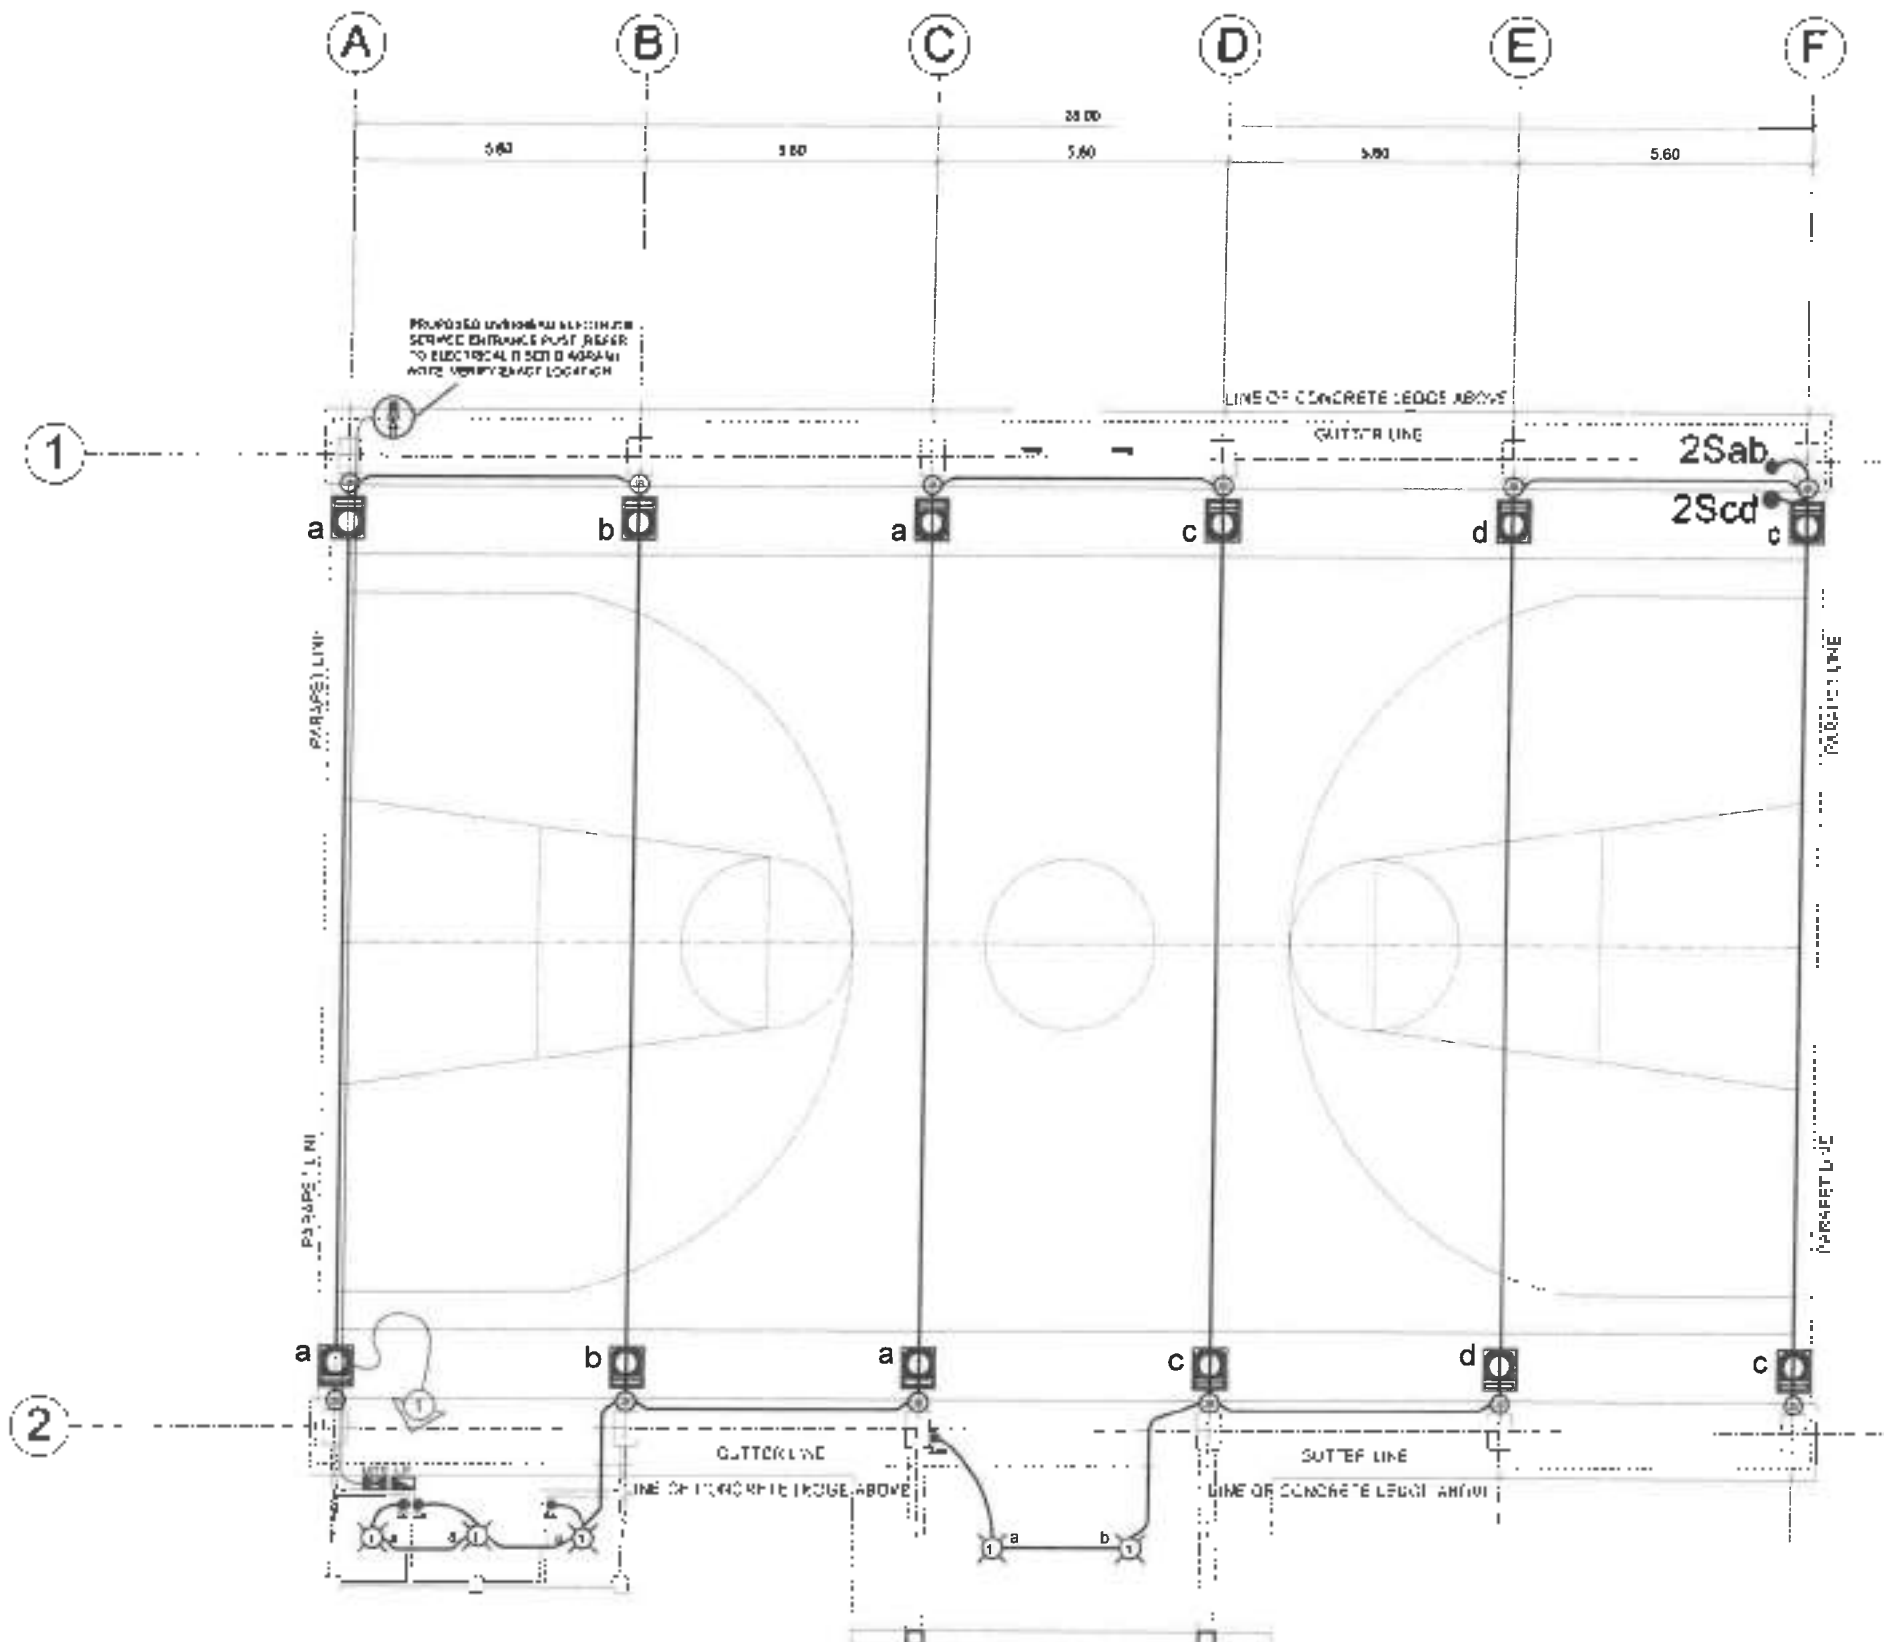

1 LIGHTING OUTLET LAYOUT PLAN
E-2 SCALE 1:100M



Department of Public Works and Highways
Regional Office No. 1
NORTHERN SAMAR FIRST
DISTRICT ENGINEERING OFFICE
Calbayog, Samar

PROJECT NAME & LOCATION
CONSTRUCTION OF MULTI-PURPOSE FACILITY,
COVERED COURT, BARANGAY SAN JOSE,
LAVEZAR, NORTHERN SAMAR
Municipality, Northern Samar

SHEET CONTENTS
LIGHTING LAYOUT PLAN

PREPARED BY
ELIANA E. CAMPO
ELECTRICAL ENGINEER
DESIGNED BY
MARK JOY L. CORRAJO
PROJECT ENGINEER


REVIEWED BY
MARK DONALD R. TAN
DIST. ENG. PLANNING COORDINATOR

SUBMITTED BY
ANDY S. ENERO
DIST. PLANNING COORDINATOR

RECOMMENDED BY
VIVIAN S. BALOG
SITE ENGINEER

APPROVED BY
ALVIN A. KORACKO
DISTRICT ENGINEER

SHEET No.
F-3
SHEET No.
38
42

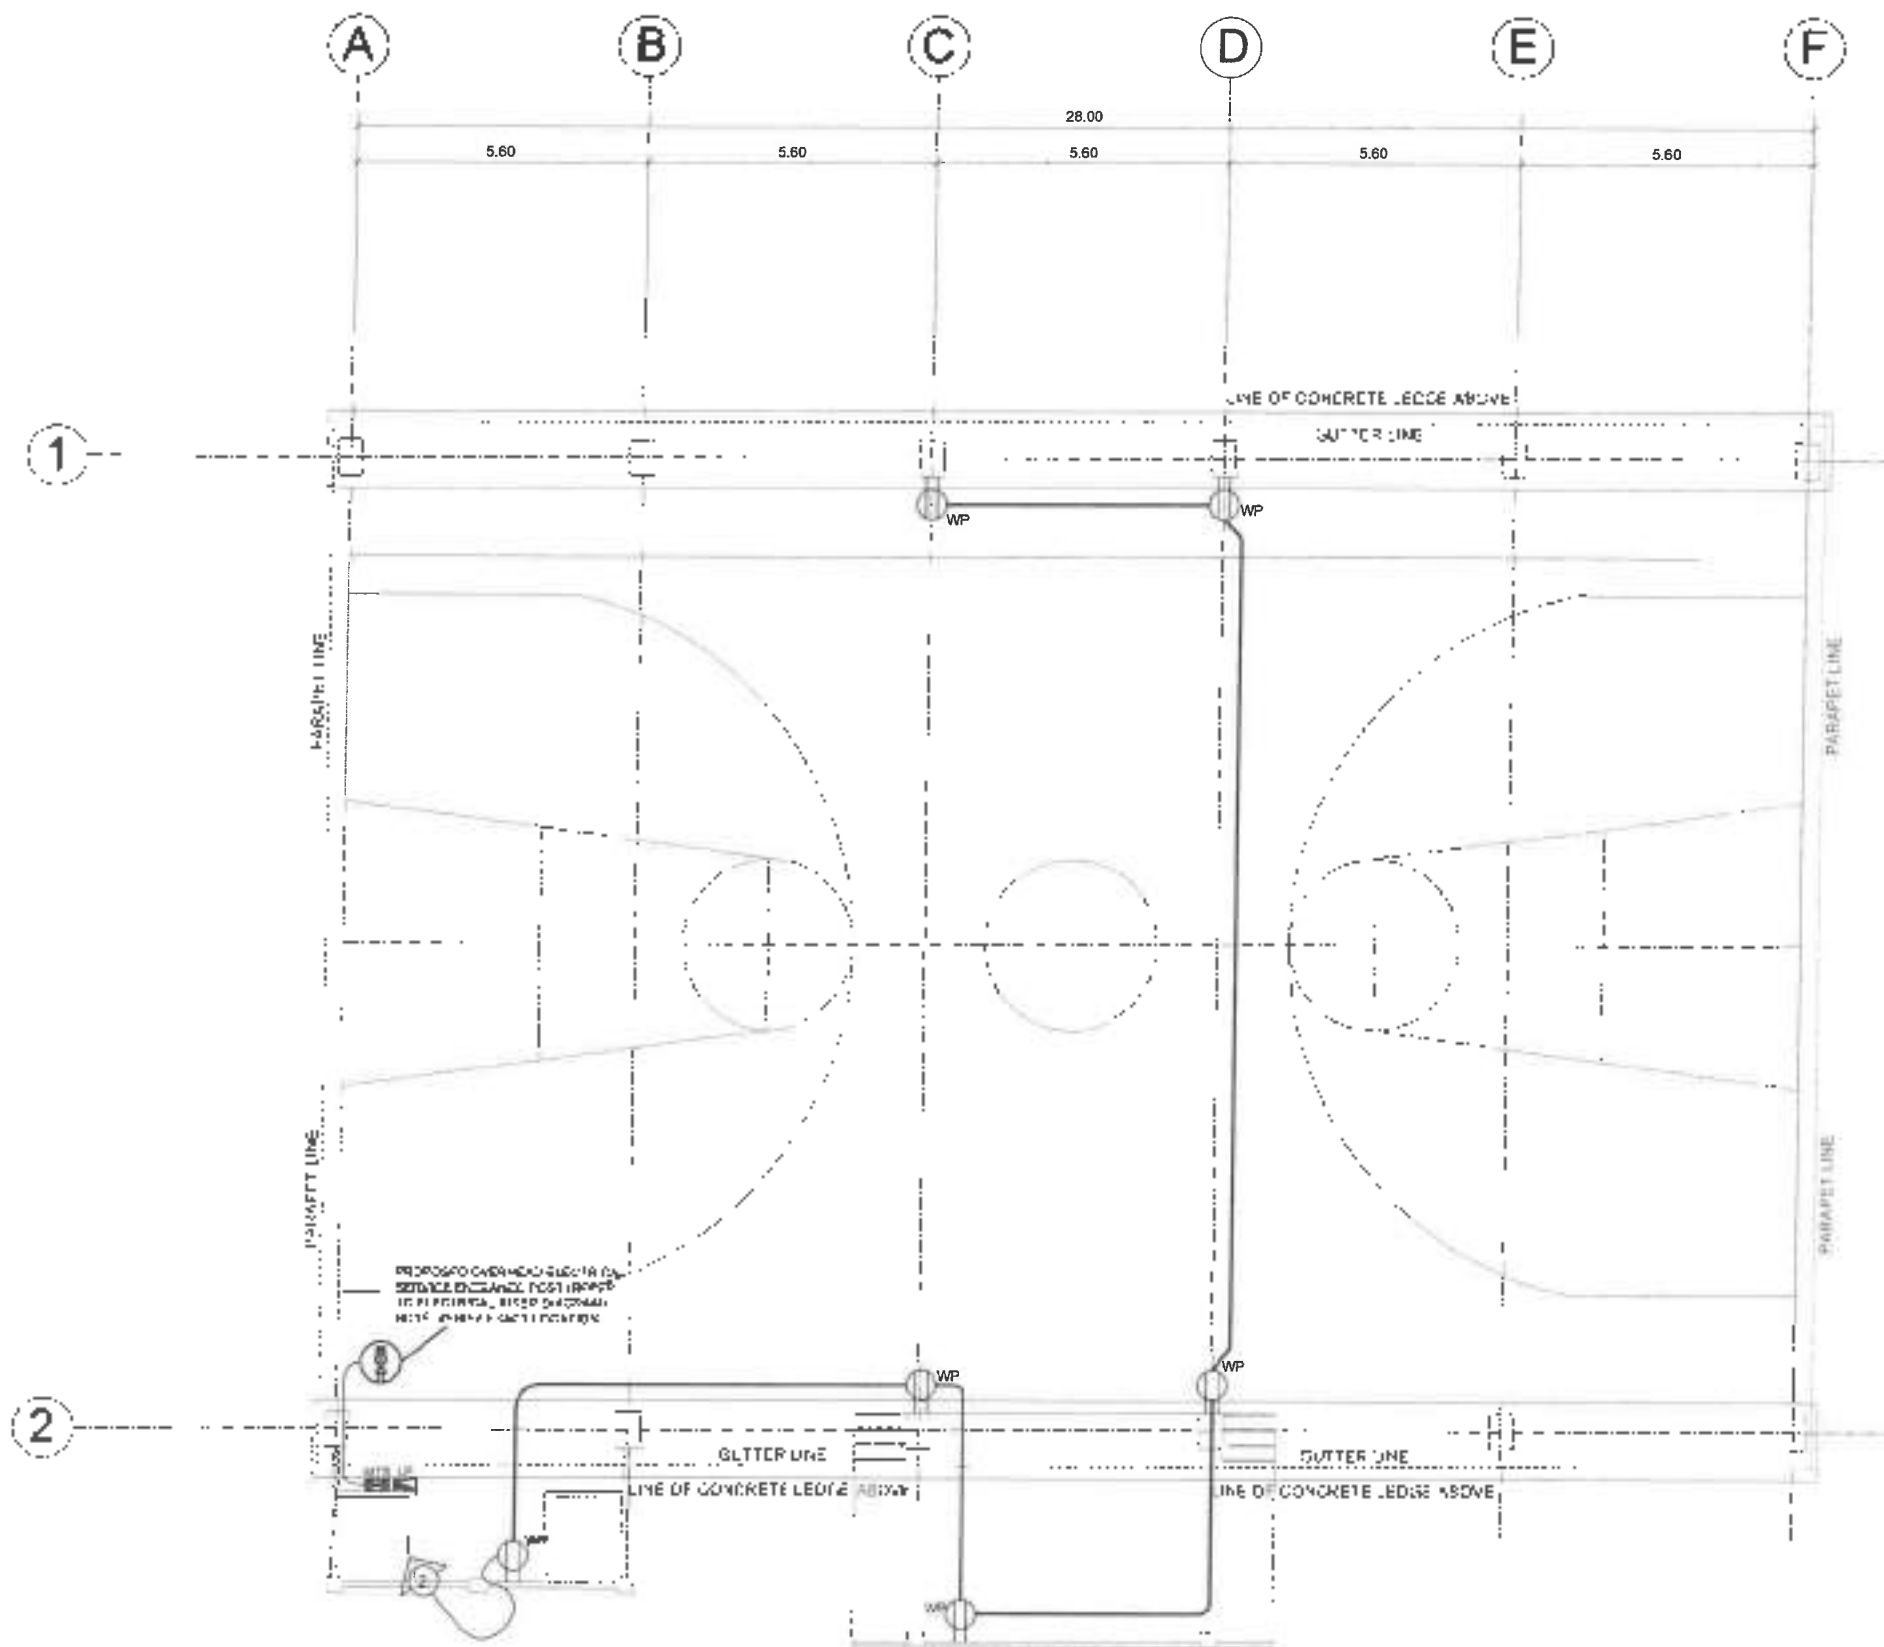


1 CONVENIENCE OUTLET LAYOUT PLAN
E-3 SCALE 1:110M

 DEPARTMENT OF PUBLIC WORKS AND HIGHWAYS REGIONAL OFFICE NO. VII NORTHERN SAMAR FIRST DISTRICT ENGINEERING OFFICE Cebu City, Mindanao, Philippines	PROJECT NAME & LOCATION CONSTRUCTION OF MULTI-PURPOSE FACILITY, (COVERED COURT) BARANGAY SAN JOSE, LAVELANDS, NORTHERN SAMAR LAVELANDS, NORTHERN SAMAR	SHEET CONTENTS: CONVENIENCE OUTLET LAYOUT PLAN	PREPARED: ELVIN A. IGNADO ELECTRICAL ENGINEER DESIGNED: MARY JOY L. DOMINGO ARCHITECT	REVIEWED: ALVIN A. IGNADO NOR DONALD R. BERN JUNIOR ENGINEER	SUBMITTED: ANDY S. ESPINO JUNIOR ENGINEER	RECOMMENDED: ALVIN A. IGNADO JUNIOR ENGINEER	APPROVED: ALVIN A. IGNADO JUNIOR ENGINEER	REV. No. 1 SHEET No. 30 42
--	---	---	--	---	--	---	--	---

LEGENDS:

Materials: (a) Tarpeulin (b) 1/2" Plywood - BackFrame (c) Wire, rebar tie wires as hangers, etc

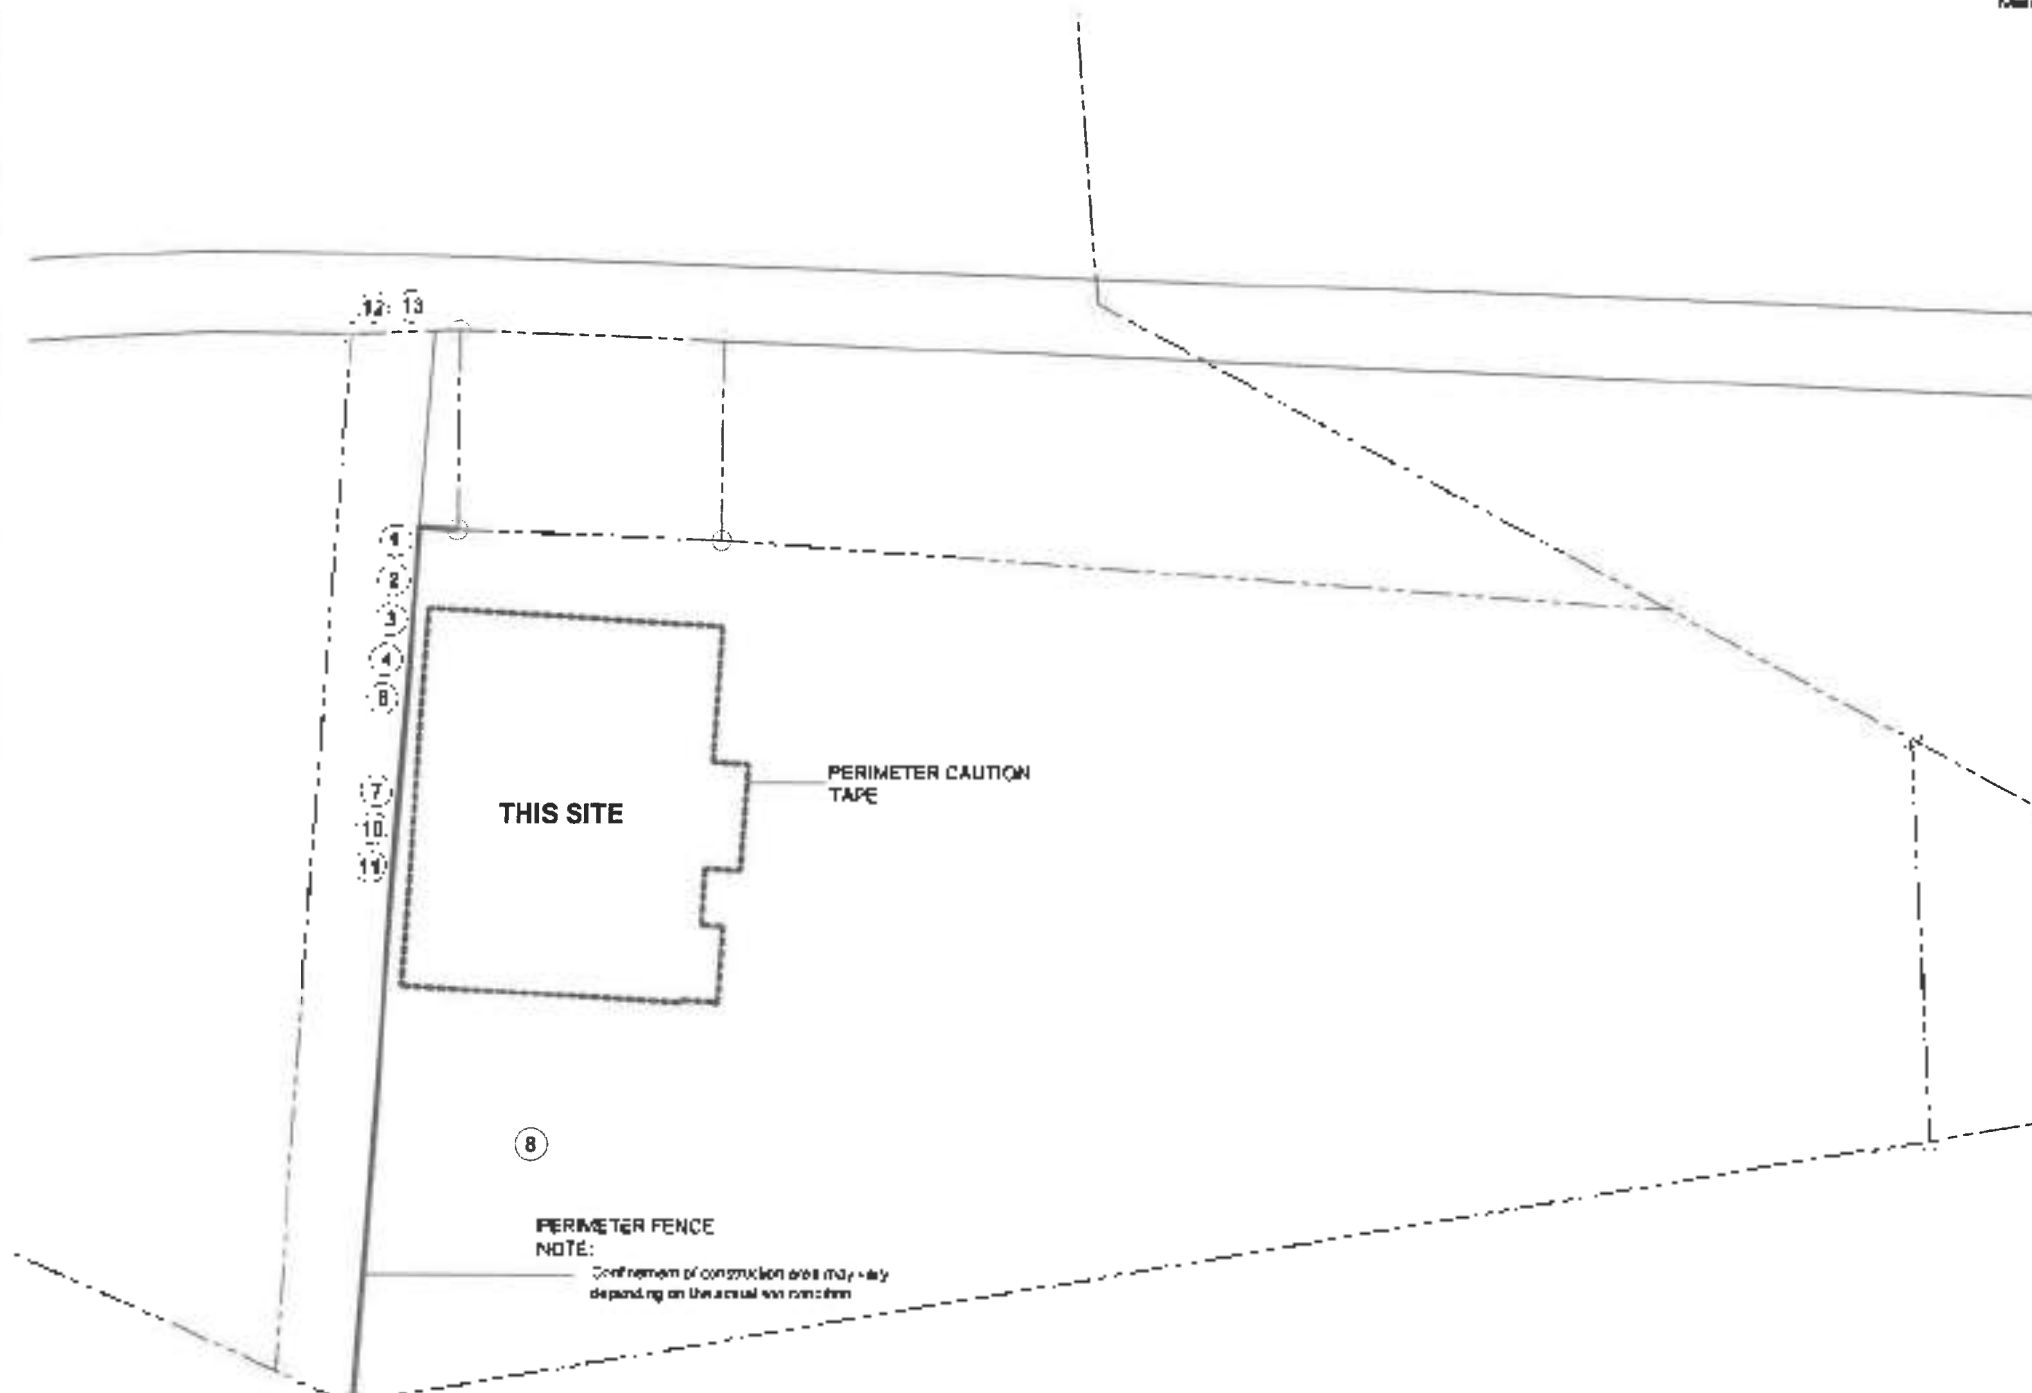

1



Proper PPE Signage
4' width x 6' height

2



Safe
4' width x 4' height

3



 
Safe
3' width x 2' height

4



Safety Harness Required
3' width x 2' height

5



Welding Hot Work Area
3' width x 2' height

6



Authorized Personnel Only
3' width x 2' height

7



Fall Hazard
3' width x 2' height

8



Temporary Materials Storage Area
3' width x 2' height

9



Hard Hat Area
3' width x 2' height

10



Danger Deep Excavation
3' width x 2' height

11



Beware Falling Objects
3' width x 2' height

12



 
Construction Entrance
3' width x 2' height

13




Construction Exit
3' width x 2' height

14



THIS WAY TO EXIT
3' width x 2' height

 15



THIS WAY TO EXIT
3' width x 2' height

1 BARRICADE AND SIGNAGES

PB-1 SCALE: 1:900MTS

Department of Public Works and Highways REGIONAL OFFICE No. VII NORTHERN SAMAR DISTRICT ENGINEERING OFFICE Laloran, Marikina, Samar	PROJECT NAME & LOCATION CONSTRUCTION OF MULTIPURPOSE FACILITY, (COVERED COURT) BARANGAY SAN JOSE, LAVEZAROS, NORTHERN SAMAR	SHEET CONTENTS: BARRICADE AND SIGNAGES	DESIGNED: DESIGNER	REVIEWED: REVIEWER	SUBMITTED: SUBMITTER	APPROVED: APPROVER	APPROVED: APPROVER	SHEET No. PB-1	SHEET No. 41 42
--	--	---	------------------------------------	------------------------------------	--------------------------------------	------------------------------------	------------------------------------	---------------------------	--------------------------------



Commission on Audit
Republic of the Philippines

Project: _____ Cost: _____

Location: _____ Fund Source(s): _____

Implementing Agency: _____

Development Partner: _____

Contract/Supplier: _____

Brief Description of Project: _____

Project Details:

Project Data			Project Status				
Duration	Name	Target Date of Completion	Percentage of Completion	Actual (YTD)	Cost Incurred to Date	Date Completed	Remarks

For particulars or comments about this project, please contact the Regional Office or Office which has jurisdiction over the project.

COA Regional Office (R/O) Office: _____

Address: _____


Contact No.: _____ or from COA Call Center, Dial at 0915-5553957

2400


COA STANDARD PROJECT BILLBOARD

SPECIFICATIONS:

1. TARPAULIN, WHITE, 8 FT X 8 FT
2. RESOLUTION : 70 DPI
3. FONT : HELVETICA
4. FONT SIZE : MAIN INFORMATION - 3"
SUB-INFORMATION - 1"
5. FONT COLOR: BLACK
6. BACKGROUND COLOR: WHITE

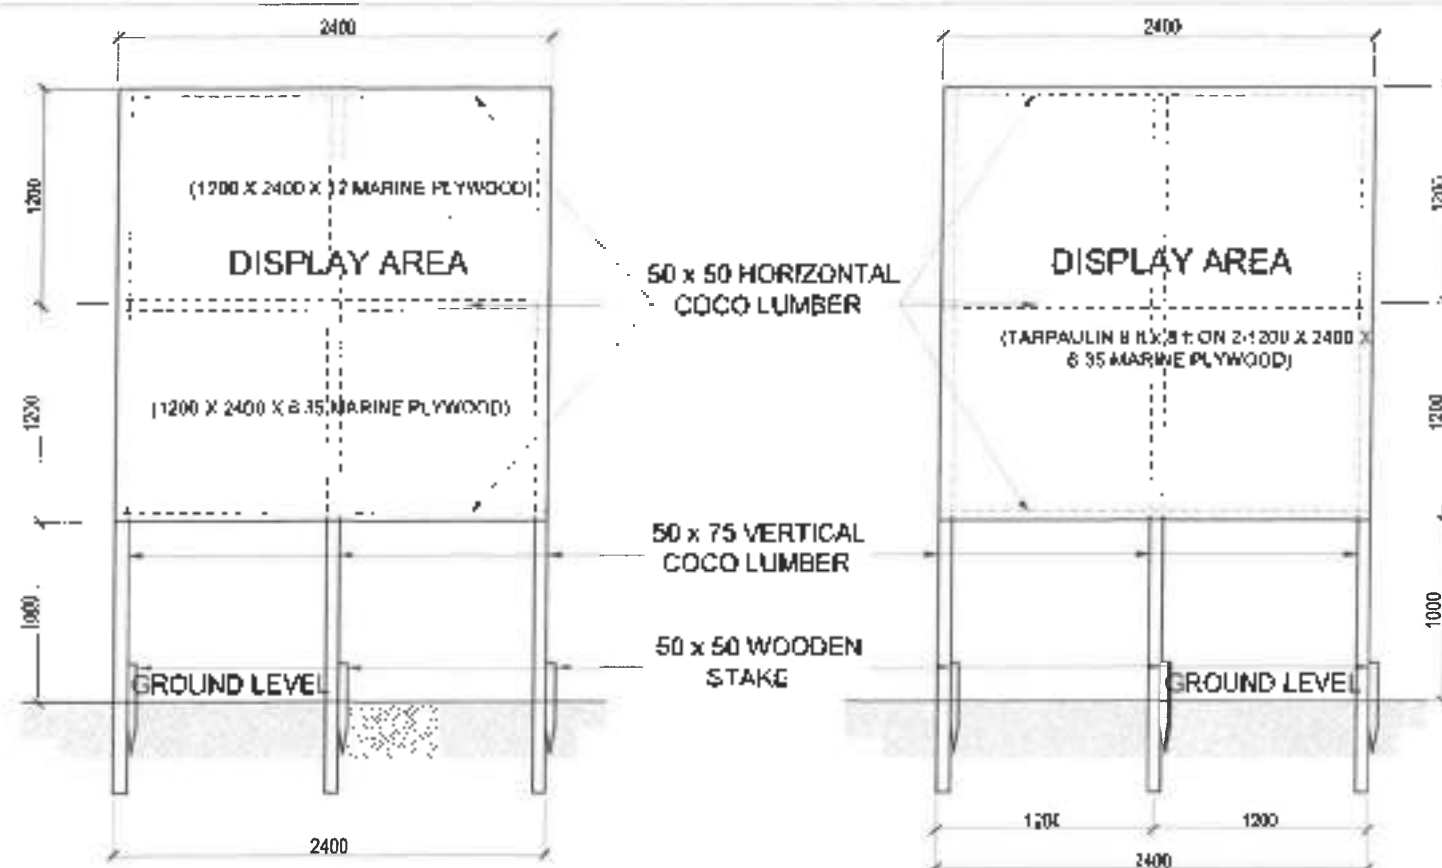


FRONT ELEVATION
(OPTION 1)

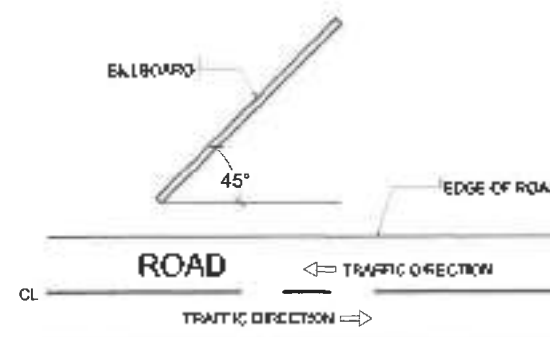

COA BILLBOARD FRAME

(NOT TO SCALE. ALL DIMENSIONS ARE IN METERS)

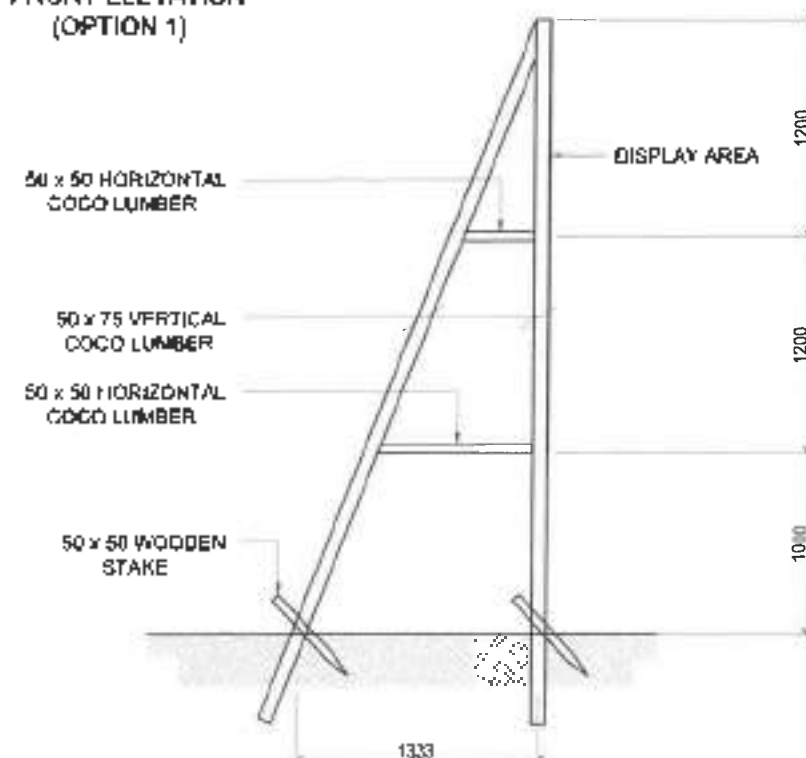

Republic of the Philippines
DEPARTMENT OF PUBLIC WORKS AND HIGHWAYS
REGIONAL OFFICE NO. 1
NORTHERN SAMAR FIRST
DISTRICT ENGINEERING OFFICE
Cebu, Northern Samar

PROJECT NAME & LOCATION

CONSTRUCTION OF MULTIPURPOSE FACILITY,
(COVERED COURT) BARANGAY SAN JOSE,
LAJUZARES, NORTHERN SAMAR
1. National, 2. Provincial, 3. City/Municipal, 4. Local

SHEET CONTENTS

COA Standard Project Billboard

DESIGNED:

BURTON S. BRUNO
CHIEF PLANNER / DESIGN SECTION

REVIEWED:

ANDY S. BRUNO
CHIEF PLANNER / DESIGN SECTION

SUBMITTED:

ANDY S. BRUNO
CHIEF PLANNER / DESIGN SECTION

RECOMMENDED:

VIVIAN S. BRUNO
CHIEF PLANNER / DESIGN SECTION

APPROVED:

ALVIN A. BRUNO
CHIEF PLANNER / DESIGN SECTION

SET No.

PB-3

SHEET No.

42