




REPUBLIC OF THE PHILIPPINES
DEPARTMENT OF PUBLIC WORKS AND HIGHWAYS
ZAMBOANGA CITY 2nd DISTRICT ENGINEERING OFFICE
DIVISORIA, ZAMBOANGA CITY

C.Y. 2025 PROJECT
CONSTRUCTION OF RAINWATER COLLECTION SYSTEM (RWCS),
BUNGUIAO NATIONAL HIGH SCHOOL, BRGY. BUNGUIAO,
ZAMBOANGA CITY

SUBMITTED:



CAROLYN M. ORBECIDO
CHIEF, PLANNING AND DESIGN SECTION
DATE: 4/21/25

RECOMMENDED:

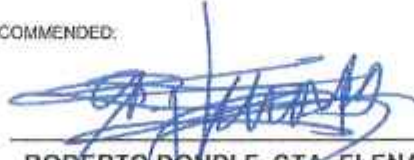
ROBERTO DONDI F. STA. ELENA
ASSISTANT DISTRICT ENGINEER
DATE: 4/22/25

APPROVED:



PILAR C. RIVERA
DISTRICT ENGINEER
DATE: 4/22/25

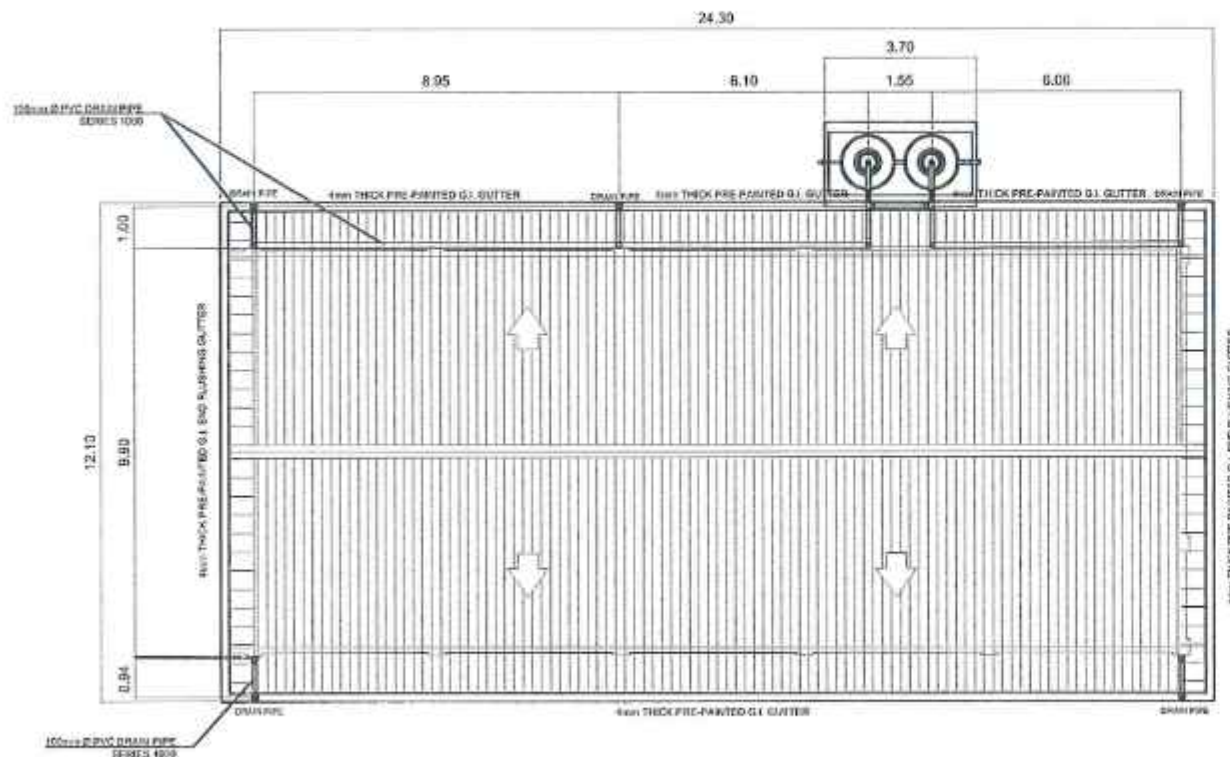

2 STOREY - 4 CLASSROOM SCHOOL BUILDING
ROOF PLAN



RIGHT SIDE ELEVATION
SCALE 1:100

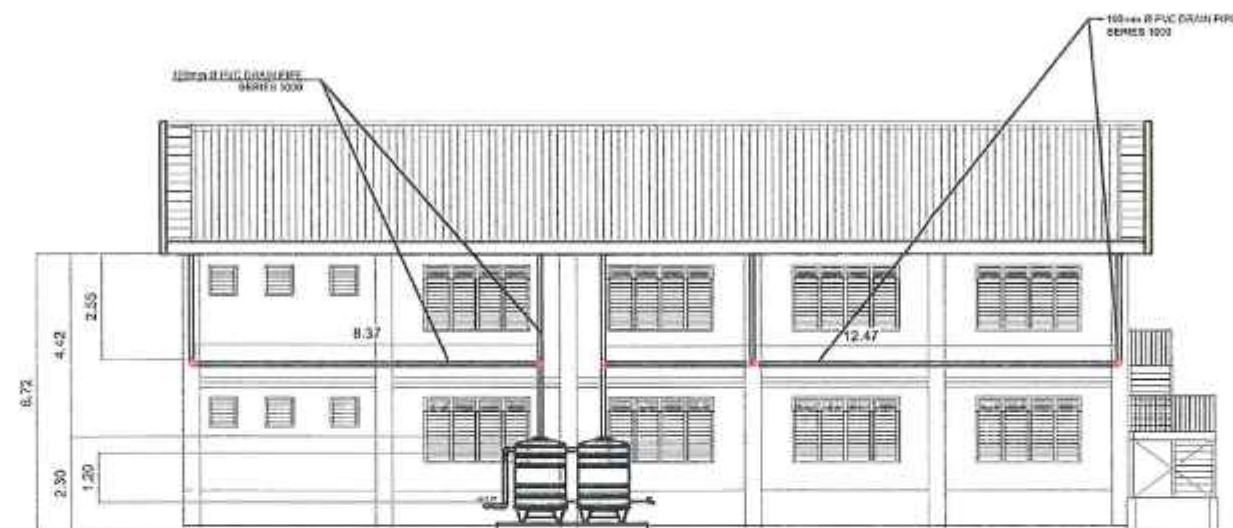

REAR ELEVATION
SCALE 1:100



REPUBLIC OF THE PHILIPPINES
DEPARTMENT OF PUBLIC WORKS AND HIGHWAYS
ZAMBOANGA CITY 2ND DISTRICT ENGINEERING OFFICE
DIVISORIA, ZAMBOANGA CITY

PROJECT NAME AND LOCATION :
CONSTRUCTION OF RAINWATER COLLECTION
SYSTEM (RWCS), BUNGUAD NATIONAL HIGH
SCHOOL, BRGY. BUNGUAD, ZAMBOANGA CITY

SHEET CONTENT :
ROOF PLAN
RIGHT SIDE ELEVATION
REAR ELEVATION

DRAFTED :
CHRISTINE MARIE R. VALEROZO
ARCHITECT II
PREPARED :
MA. DANIE V. MAGSAYANI
ENGINEER - II


REVIEWED BY :
PROFESSIONAL MASTER PLUMBER

SUBMITTED :
CAROLYN M. ORBECIDO
CHIEF PLUMBER AND DESIGN SECTION
4/21/25


RECOMMENDED :
ROBERTO D. DUNGLA, SCA-ELINA
ASSISTANT DISTRICT ENGINEER
4/22/25

APPROVED :
PILAR C. RIVERA
DISTRICT ENGINEER
4/22/25

SET NO: 1
2
SHEET NO: RWC-1
02
P. 1

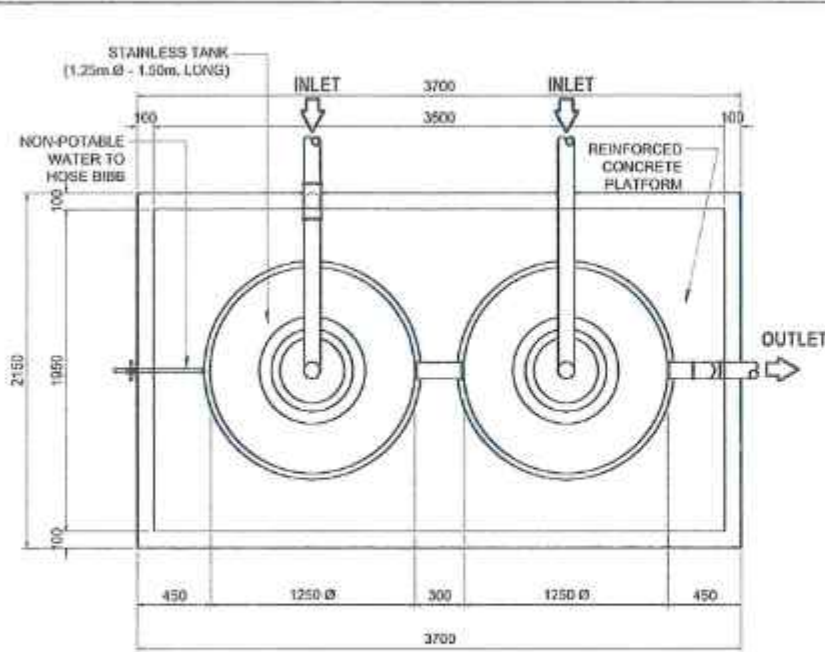

PLAN

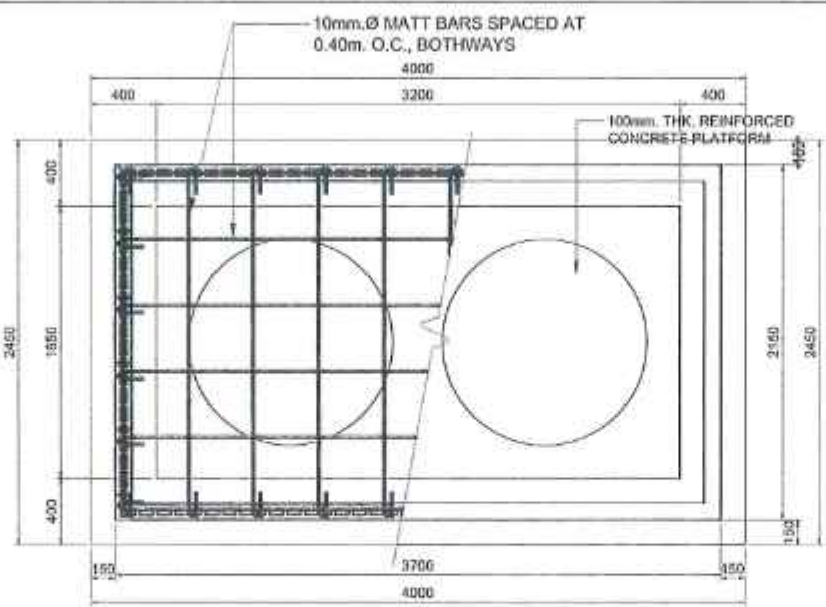


FOUNDATION PLAN




LEGEND:
 NATIONAL HIGHWAY
 ROUTE TO SCHOOL
 RIVER


LOCATION PLAN
 NOT TO SCALE

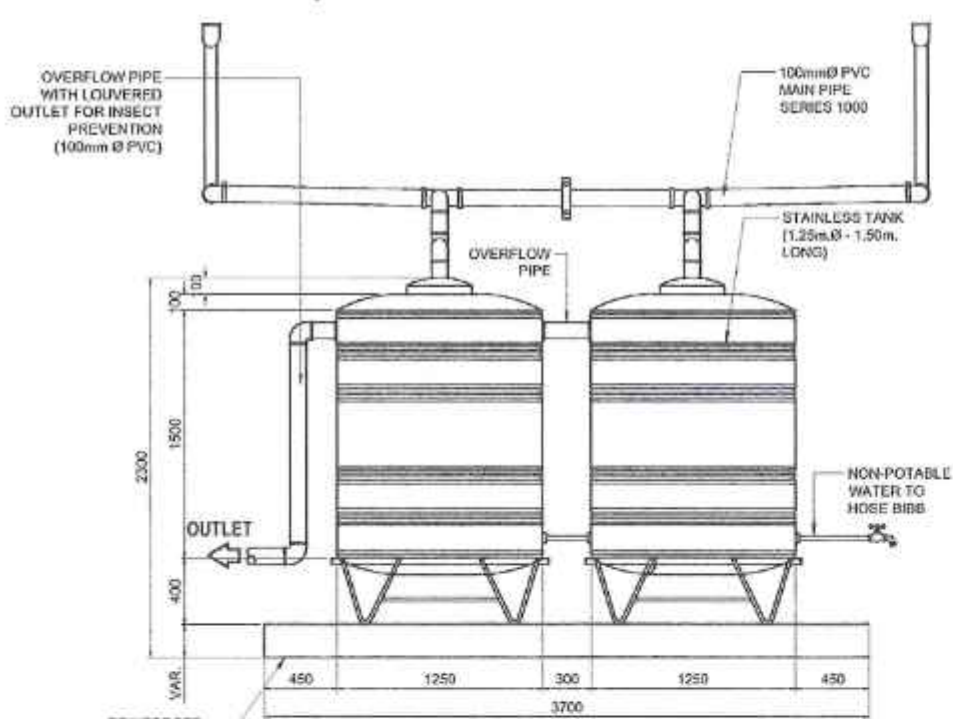


FRONT ELEVATION

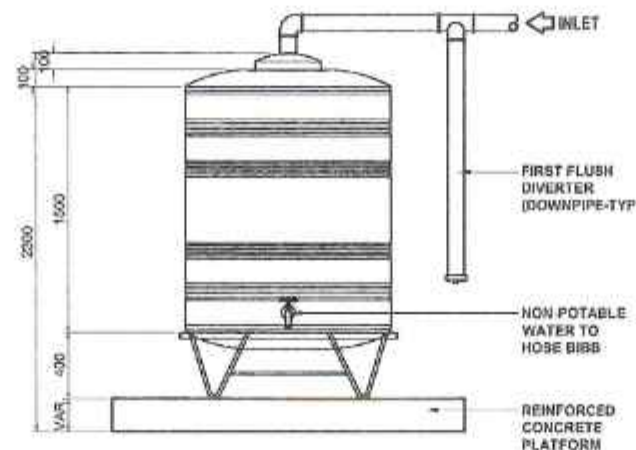


LEFT-SIDE ELEVATION

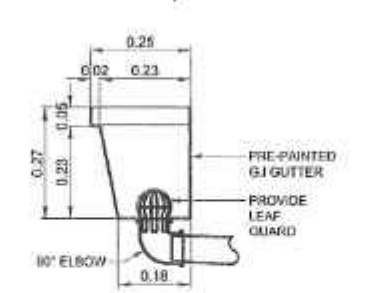

GUTTER BLOW-UP DETAIL
 SCALE: 1:10 MTRS.

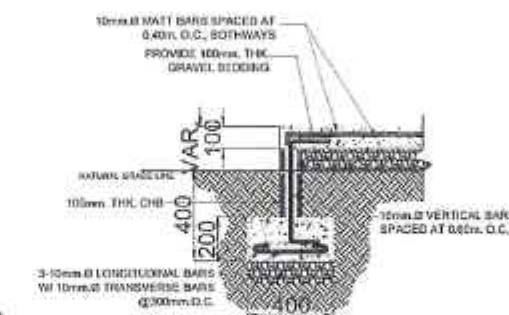

WALL FOOTING SECTION DETAIL
 SCALE: PROVIDE 100mm THK. GRAVEL BEDDING

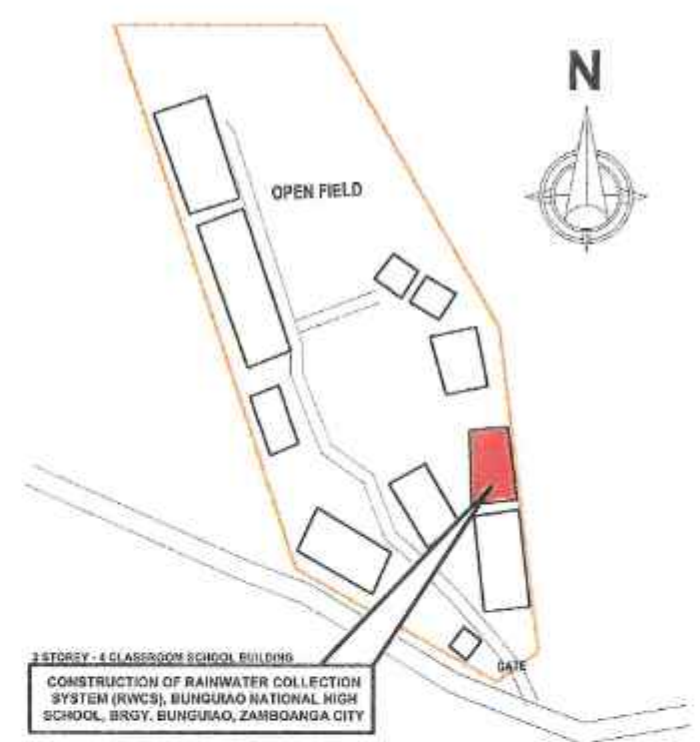

3 STOREY - 4 CLASSROOM SCHOOL BUILDING
 CONSTRUCTION OF RAINWATER COLLECTION SYSTEM (RWCS), BUNGUO NATIONAL HIGH SCHOOL, BRGY. BUNGUO, ZAMBOANGA CITY

SITE DEVELOPMENT PLAN
 NOT TO SCALE

RAIN WATER COLLECTION SYSTEM DETAIL
 SCALE: 1:25 MTRS.

REPUBLIC OF THE PHILIPPINES DEPARTMENT OF PUBLIC WORKS AND HIGHWAYS ZAMBOANGA CITY 2ND DISTRICT ENGINEERING OFFICE DIVISORIA, ZAMBOANGA CITY	PROJECT NAME AND LOCATION: CONSTRUCTION OF RAINWATER COLLECTION SYSTEM (RWCS), BUNGUO NATIONAL HIGH SCHOOL, BRGY. BUNGUO, ZAMBOANGA CITY	SHEET CONTENT: RAINWATER COLLECTOR DETAIL	DRAFTED: CHRISTY MARIE R. VALEROSO ARCHITECT II PREPARED: MA. LANIE V. ABBAYANI ENGINEER - II	REVIEWED BY: PROFESSIONAL MASTER PLUMBER	SUBMITTED: CAROLYN L. ORBECIDO CHIEF PLUMBING AND CORKING SECTION 1/21/25	RECOMMENDED: ROBERTO DONDI F. STA. ELENA ASSISTANT DISTRICT ENGINEER 4/22/25	APPROVED: PILAR C. RIVERA DISTRICT ENGINEER 4/23/25	SET NO: 2 2	SHEET NO: RWC-2 02
---	---	--	--	---	--	---	--	-------------------	--------------------------



REPUBLIC OF THE PHILIPPINES
DEPARTMENT OF PUBLIC WORKS AND HIGHWAYS
ZAMBOANGA CITY 2nd DISTRICT ENGINEERING OFFICE
DIVISORIA, ZAMBOANGA CITY

C.Y. 2025 PROJECT
CONSTRUCTION OF RAINWATER COLLECTION SYSTEM (RWCS),
CALABASA ELEMENTARY SCHOOL, ZAMBOANGA CITY

SUBMITTED:



CAROLYN M. ORBECIDO
CHIEF, PLANNING AND DESIGN SECTION
DATE: 4/21/25

RECOMMENDED:


ROBERTO DONDI F. STA. ELENA
ASSISTANT DISTRICT ENGINEER
DATE: 4/22/25

APPROVED:


PILAR C. RIVERA
DISTRICT ENGINEER
DATE: 4/22/25

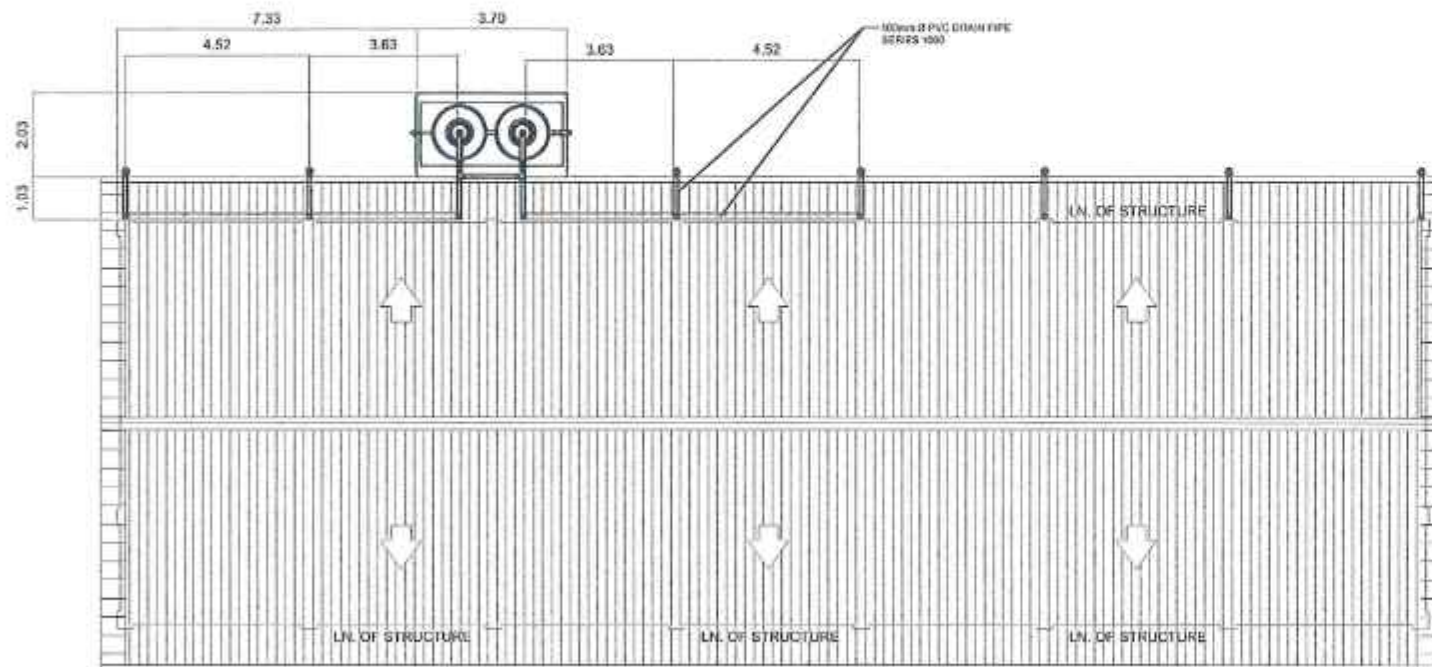


2 STOREY - 4 CLASSROOM SCHOOL BUILDING

ROOF PLAN
SCALE 1:100 M.



RIGHT SIDE ELEVATION
SCALE 1:100 M.

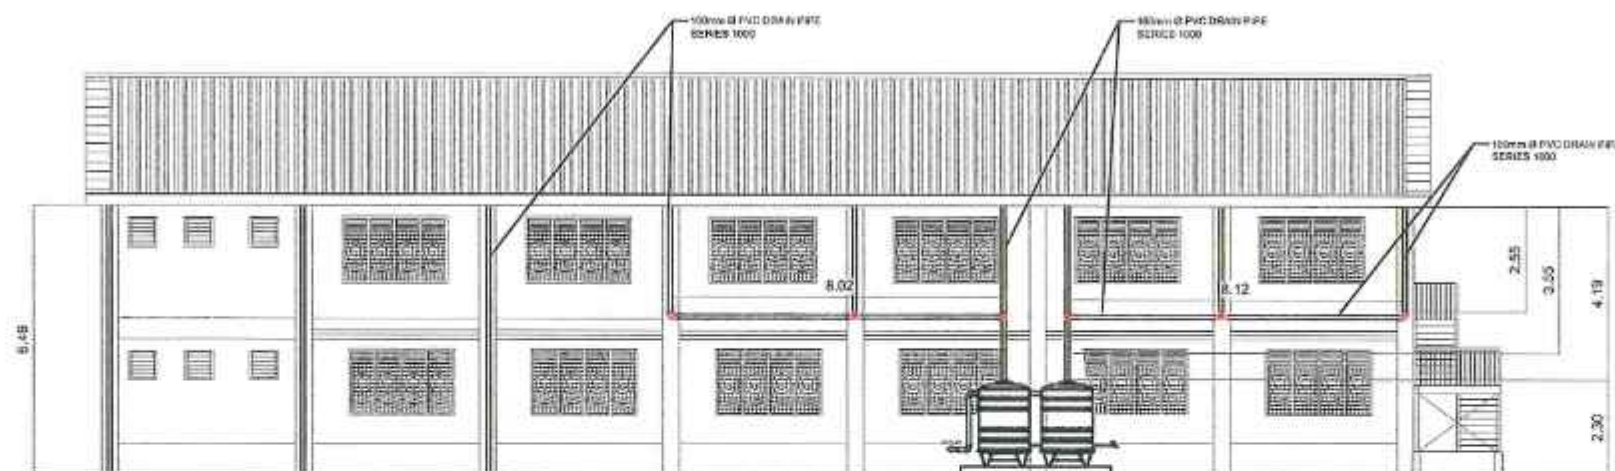

REAR ELEVATION
SCALE 1:100 M.



REPUBLIC OF THE PHILIPPINES
DEPARTMENT OF PUBLIC WORKS AND HIGHWAYS
ZAMBOANGA CITY 2ND DISTRICT ENGINEERING OFFICE
DIVISORIA, ZAMBOANGA CITY

PROJECT NAME AND LOCATION :
CONSTRUCTION OF RAINWATER COLLECTION
SYSTEM (RWCS), CALABASA ELEMENTARY
SCHOOL, ZAMBOANGA CITY

SHEET CONTENT :
ROOF PLAN
RIGHT SIDE ELEVATION
REAR ELEVATION

DRAFTED :
CHRISTY MARIE R. VALEROZO
ARCHITECT II
PREPARED :
MA. LANIE V. ALBAYANI
ENGINEER - II

REVIEWED BY :
PROFESSIONAL RAINBOW PLUMBER








SUBMITTED :
CAROLYN M. ORBECIDO
CHIEF PLUMBER AND SECTION DESIGNER
4/22/28

RECOMMENDED :
ROBERTO DOROTI, SYA ELENA
ASSISTANT DISTRICT ENGINEER
4/22/28

APPROVED :
PIELAR C. RIVERA
DISTRICT ENGINEER
4/22/28

SET NO.:
1
2

SHEET NO.:
RWC-1
02

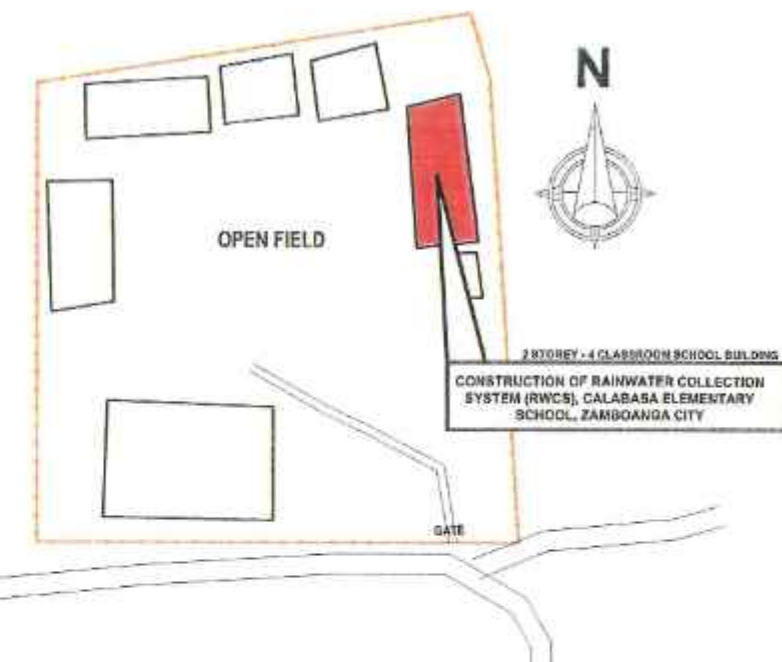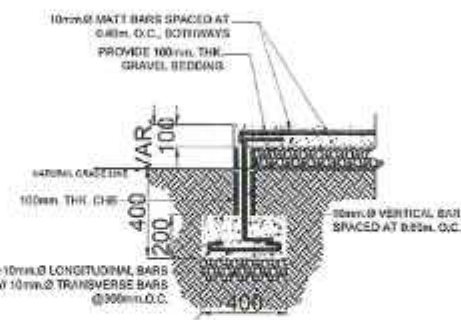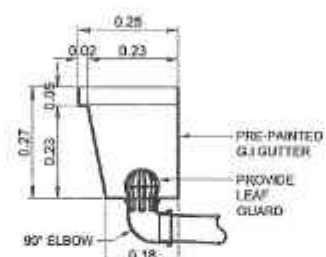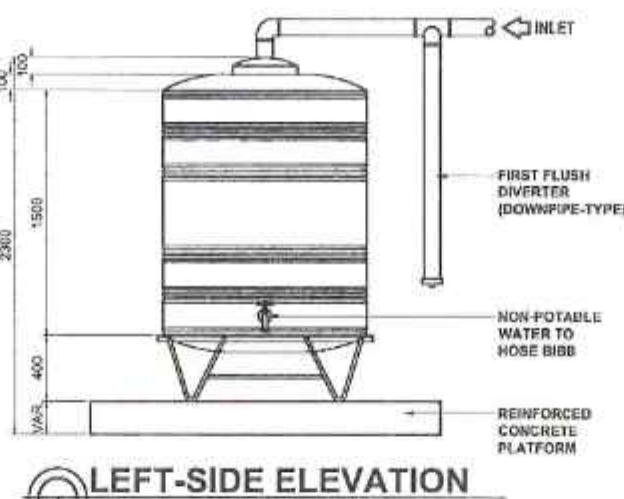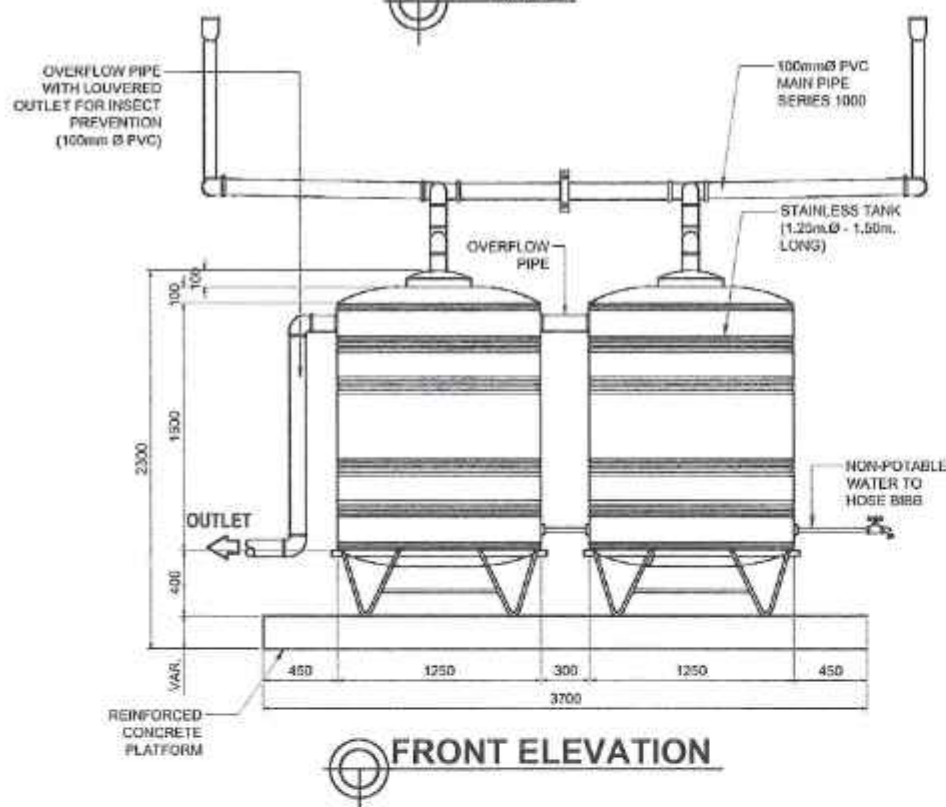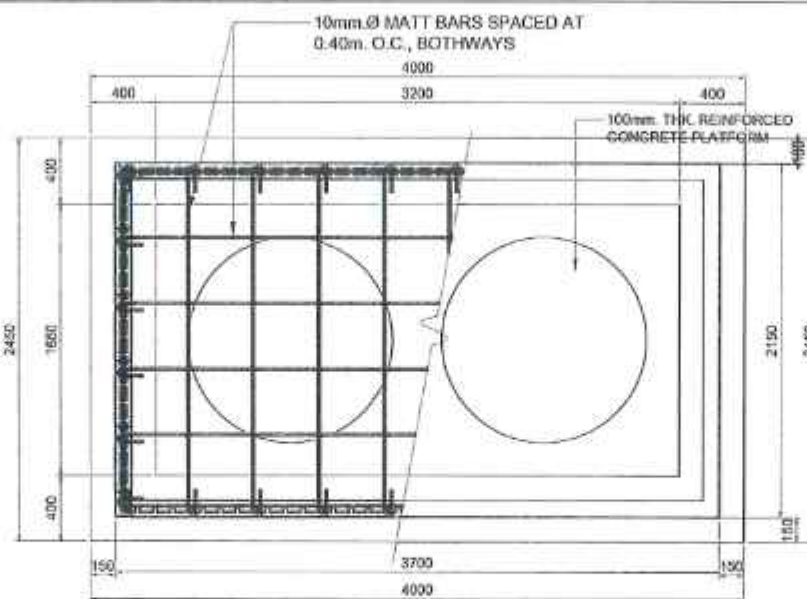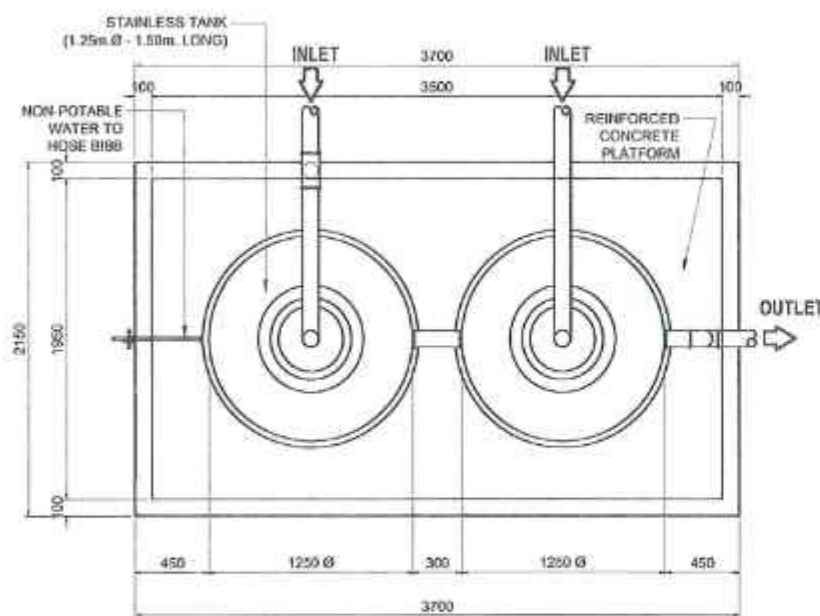

RAIN WATER COLLECTION SYSTEM DETAIL

WALL FOOTING SECTION DETAIL

SITE DEVELOPMENT PLAN



REPUBLIC OF THE PHILIPPINES
DEPARTMENT OF PUBLIC WORKS AND HIGHWAYS
ZAMBOANGA CITY 2ND DISTRICT ENGINEERING OFFICE
DIVISORIA, ZAMBOANGA CITY

PROJECT NAME AND LOCATION:
CONSTRUCTION OF RAINWATER COLLECTION SYSTEM (RWCS), CALABASA ELEMENTARY SCHOOL, ZAMBOANGA CITY

SHEET CONTENT:
RAIN WATER COLLECTOR DETAIL

DRAFTED:
CHRISTY MARIE R. VALERQZO
ARCHITECT II

PREPARED:
MA. LANIE WAGBAYANI
ENGINEER - I

REVIEWED BY:
PROFESSIONAL MASTER PLUMBER

SUBMITTED:
CAROLYN M. ORBECIDO
CITY PLANNING AND DESIGN SECTION
4/21/25

RECOMMENDED:
ROBERTO DOMIN F. STA. ELENA
ASSISTANT DISTRICT ENGINEER
4/22/25

APPROVED:
PILAR C. RIVERA
DISTRICT ENGINEER
4/22/25

BET NO:
2
2


SHEET NO:
RWC-2
02



REPUBLIC OF THE PHILIPPINES
DEPARTMENT OF PUBLIC WORKS AND HIGHWAYS
ZAMBOANGA CITY DISTRICT ENGINEERING OFFICE
DIVISORIA, ZAMBOANGA CITY

C.Y. 2025 PROJECT
CONSTRUCTION OF RAINWATER COLLECTION SYSTEM (RWCS),
CURUAN CENTRAL SCHOOL, BRGY. CURUAN, ZAMBOANGA CITY

SUBMITTED:

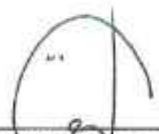

CAROLYN M. ORBECIDO
CHIEF, PLANNING AND DESIGN SECTION
DATE: 4/21/25

RECOMMENDED:


ROBERTO DONDI F. STA. ELENA
ASSISTANT DISTRICT ENGINEER
DATE: 4/22/25

APPROVED:



PILAR C. RIVERA
DISTRICT ENGINEER
DATE: 4/22/25

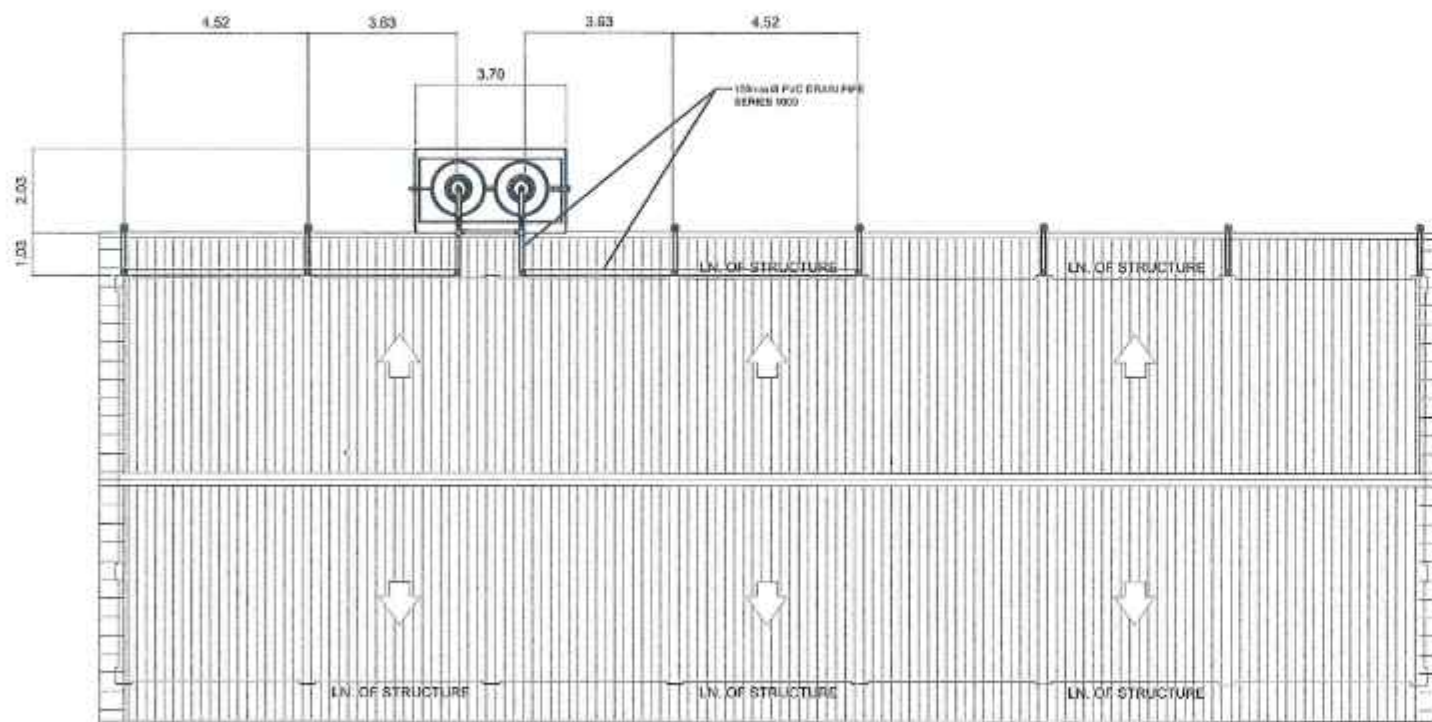

2 STOREY - 4 CLASSROOM SCHOOL BUILDING
ROOF PLAN



RIGHT SIDE ELEVATION
SCALE 1:100

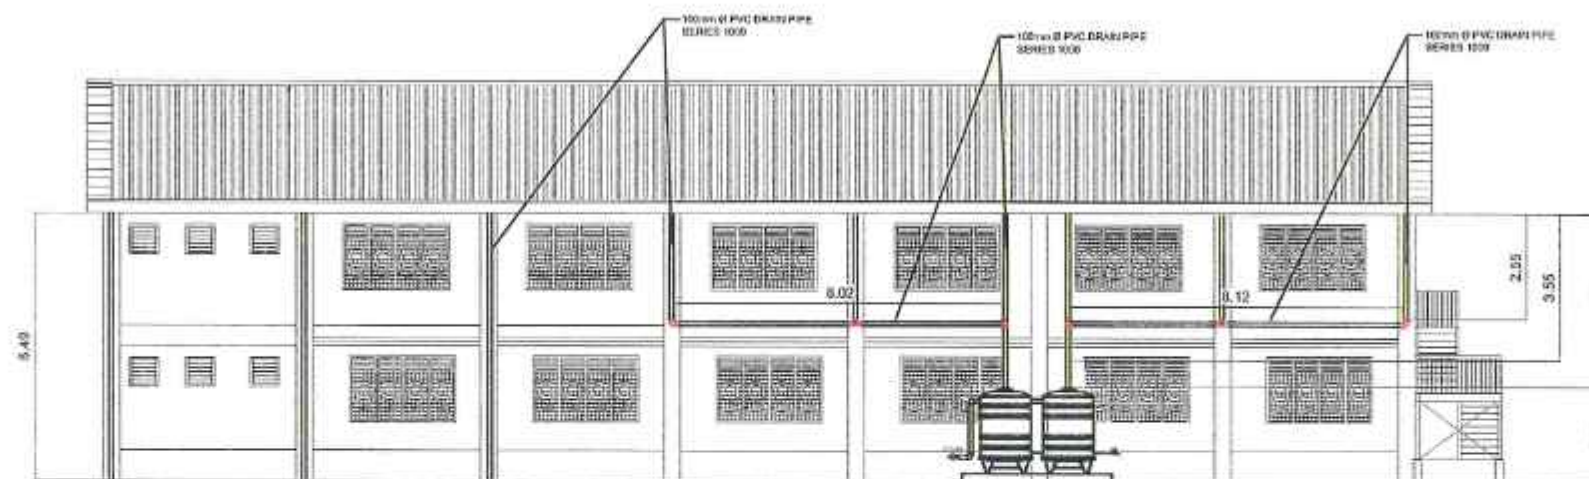

REAR ELEVATION
SCALE 1:100



REPUBLIC OF THE PHILIPPINES
DEPARTMENT OF PUBLIC WORKS AND HIGHWAYS
ZAMBOANGA CITY 2ND DISTRICT ENGINEERING OFFICE
DIVISORIA, ZAMBOANGA CITY

PROJECT NAME AND LOCATION :
CONSTRUCTION OF RAINWATER COLLECTION
SYSTEM (RWCS), CURUJAN CENTRAL SCHOOL,
BRGY. CURUJAN, ZAMBOANGA CITY

SHEET CONTENT :
ROOF PLAN
RIGHT SIDE ELEVATION
REAR ELEVATION

DRAFTED :
CHRISTY MARIE R. VALEROZO
ARCHITECT II
PREPARED :
MA. LANIE V. AGAYANI
ENGINEER - II

REVIEWED BY :
PROFESSIONAL MASTER PLUMBER


SUBMITTED :
CAROLYN M. ORBECIDO
CHIEF ENGINEER AND DESIGN SECTION
4/21/25

RECOMMENDED :
ROBERTO DOMIT, STA. ELENA
ASSISTANT DISTRICT ENGINEER
4/21/25


APPROVED :
PILAR C. RIVERA
DISTRICT ENGINEER
4/22/25

SET NO. 1
2


SHEET NO. RWC-1
02
P.1

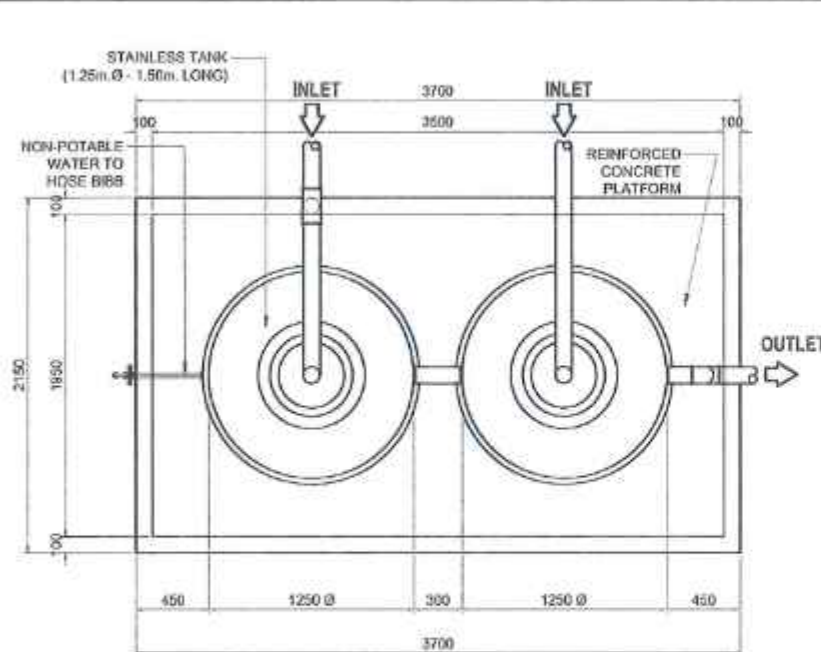


PLAN

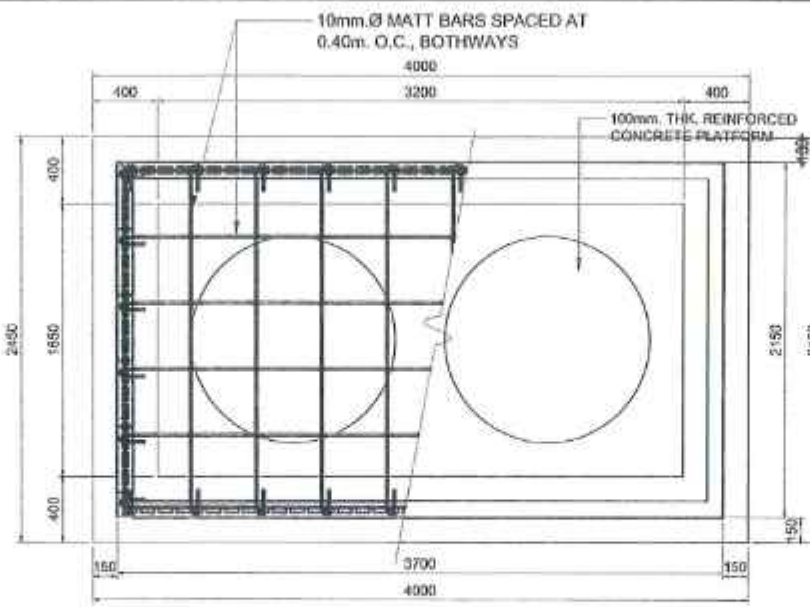


FOUNDATION PLAN

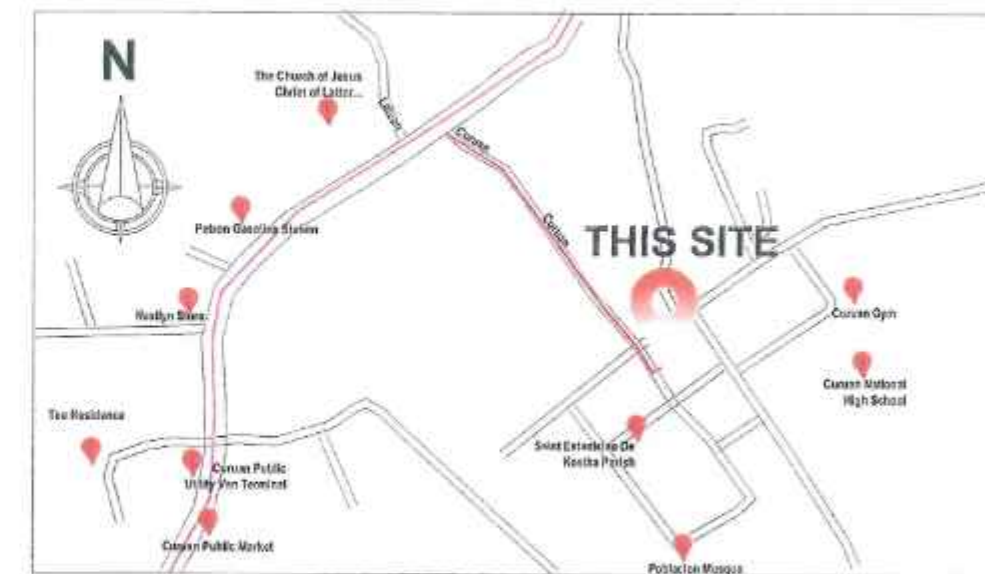


LOCATION PLAN

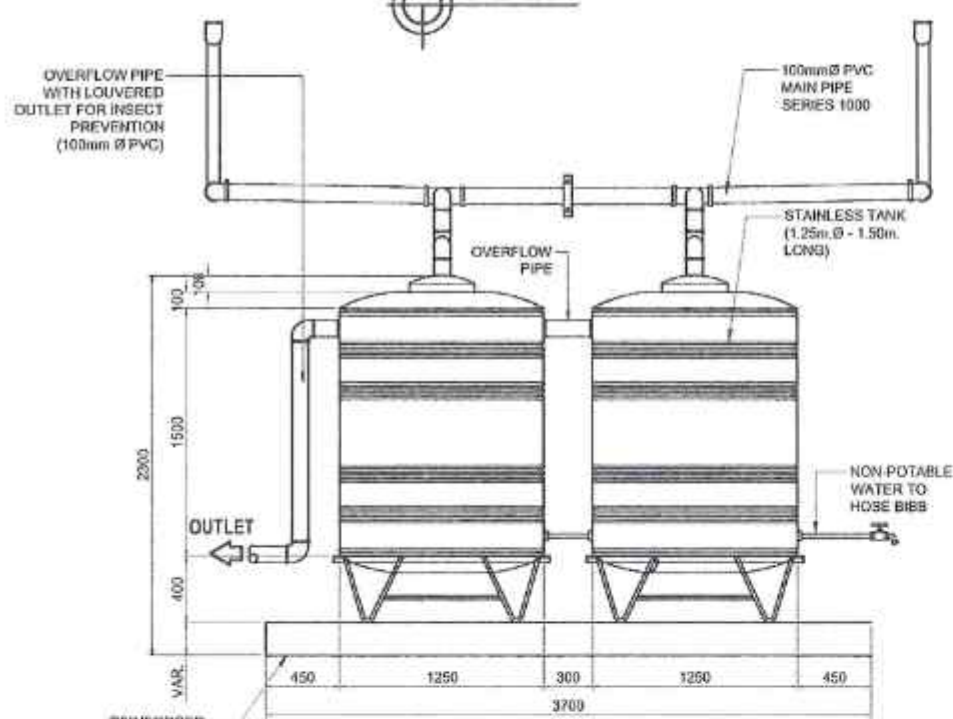


FRONT ELEVATION

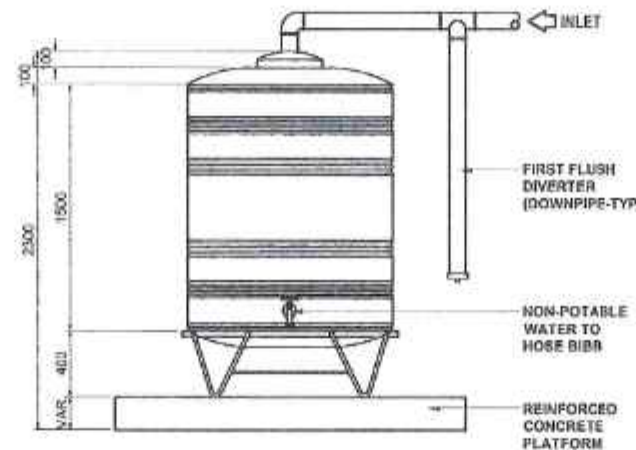


LEFT-SIDE ELEVATION

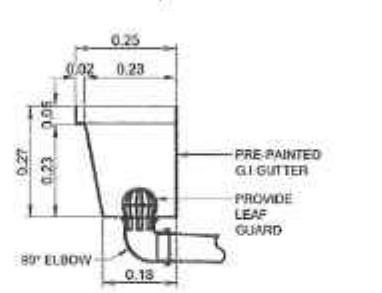

GUTTER BLOW-UP DETAIL

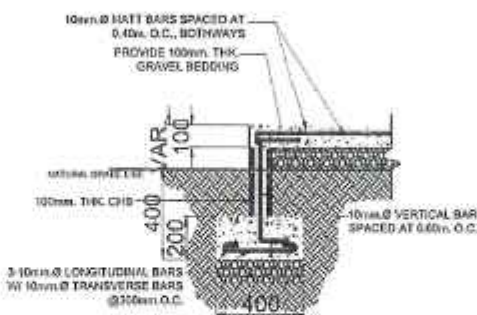

WALL FOOTING SECTION DETAIL

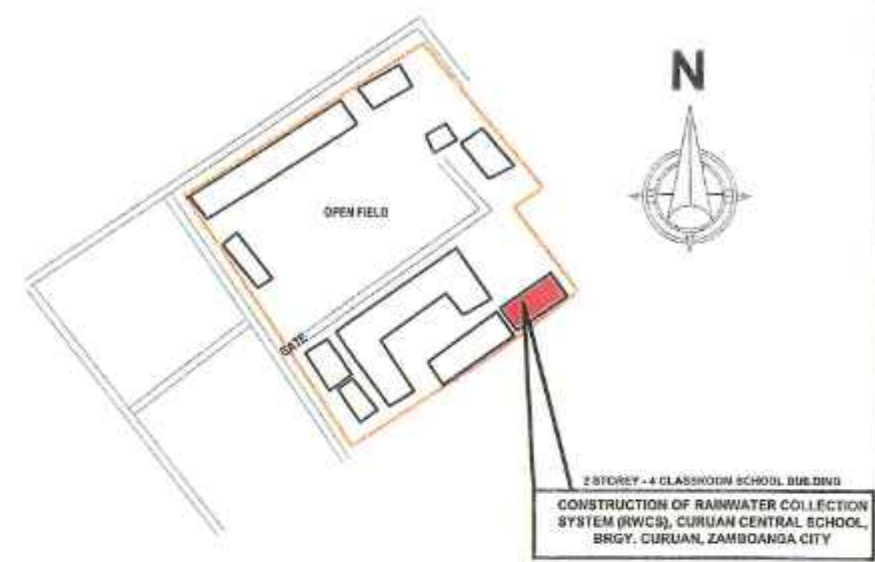

SITE DEVELOPMENT PLAN

RAIN WATER COLLECTION SYSTEM DETAIL

REPUBLIC OF THE PHILIPPINES DEPARTMENT OF PUBLIC WORKS AND HIGHWAYS ZAMBOANGA CITY 2ND DISTRICT ENGINEERING OFFICE DIMSORIA, ZAMBOANGA CITY	PROJECT NAME AND LOCATION : CONSTRUCTION OF RAINWATER COLLECTION SYSTEM (RWCS), CURUAN CENTRAL SCHOOL, BRGY. CURUAN, ZAMBOANGA CITY	SHEET CONTENT : RAINWATER COLLECTOR DETAIL	DRAFTED : CHRISTY MARIE R. VALEROSO ARCHITECT II PREPARED : MA. LANIE VIACRAYANI ENGINEER - II	REVIEWED BY : PROFESSIONAL MASTER PLUMBER	SUBMITTED : CAROLYN M. ORDECIDO CHIEF PLUMBER/MECHANICAL 4/21/20	RECOMMENDED : AGUSTO DOMESTICA ELENA ASISTANT ELECTRICAL ENGINEER 4/22/20	APPROVED : PILAR C. RIVERA DISTRICT ENGINEER 4/22/20	SET NO. : 2	SHEET NO. : RWC-2 02
--	---	--	--	---	--	---	--	---------------------------	--




REPUBLIC OF THE PHILIPPINES
DEPARTMENT OF PUBLIC WORKS AND HIGHWAYS
ZAMBOANGA CITY 2nd DISTRICT ENGINEERING OFFICE
DIVISORIA, ZAMBOANGA CITY

C.Y. 2025 PROJECT
**CONSTRUCTION OF RAINWATER COLLECTION SYSTEM (RWCS),
DON GREGORIO EVANGELISTA MEMORIAL SCHOOL, BRGY. STA.
CATALINA, ZAMBOANGA CITY**

SUBMITTED:



CAROLYN M. ORBECIDO
CHIEF, PLANNING AND DESIGN SECTION
DATE: 4/4/25

RECOMMENDED:

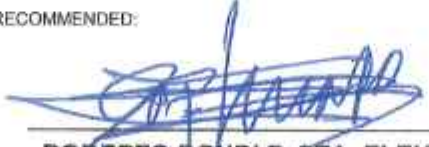
ROBERTO DONDI E. STA. ELENA
ASSISTANT DISTRICT ENGINEER
DATE: 4/22/25

APPROVED:



PILAR C. RIVERA
DISTRICT ENGINEER
DATE: 4/22/25

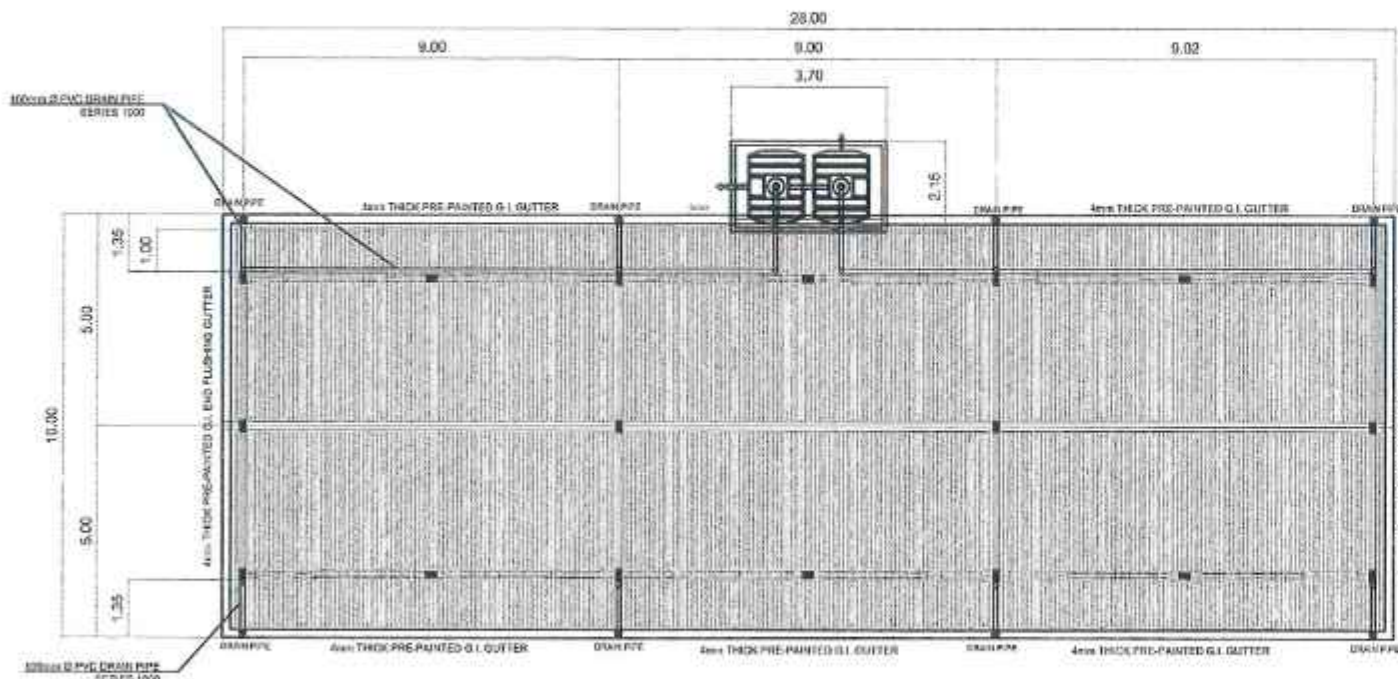

1 STOREY - 3 CLASSROOM SCHOOL BUILDING
ROOF PLAN



RIGHT SIDE ELEVATION
SCALE 1:50 M.

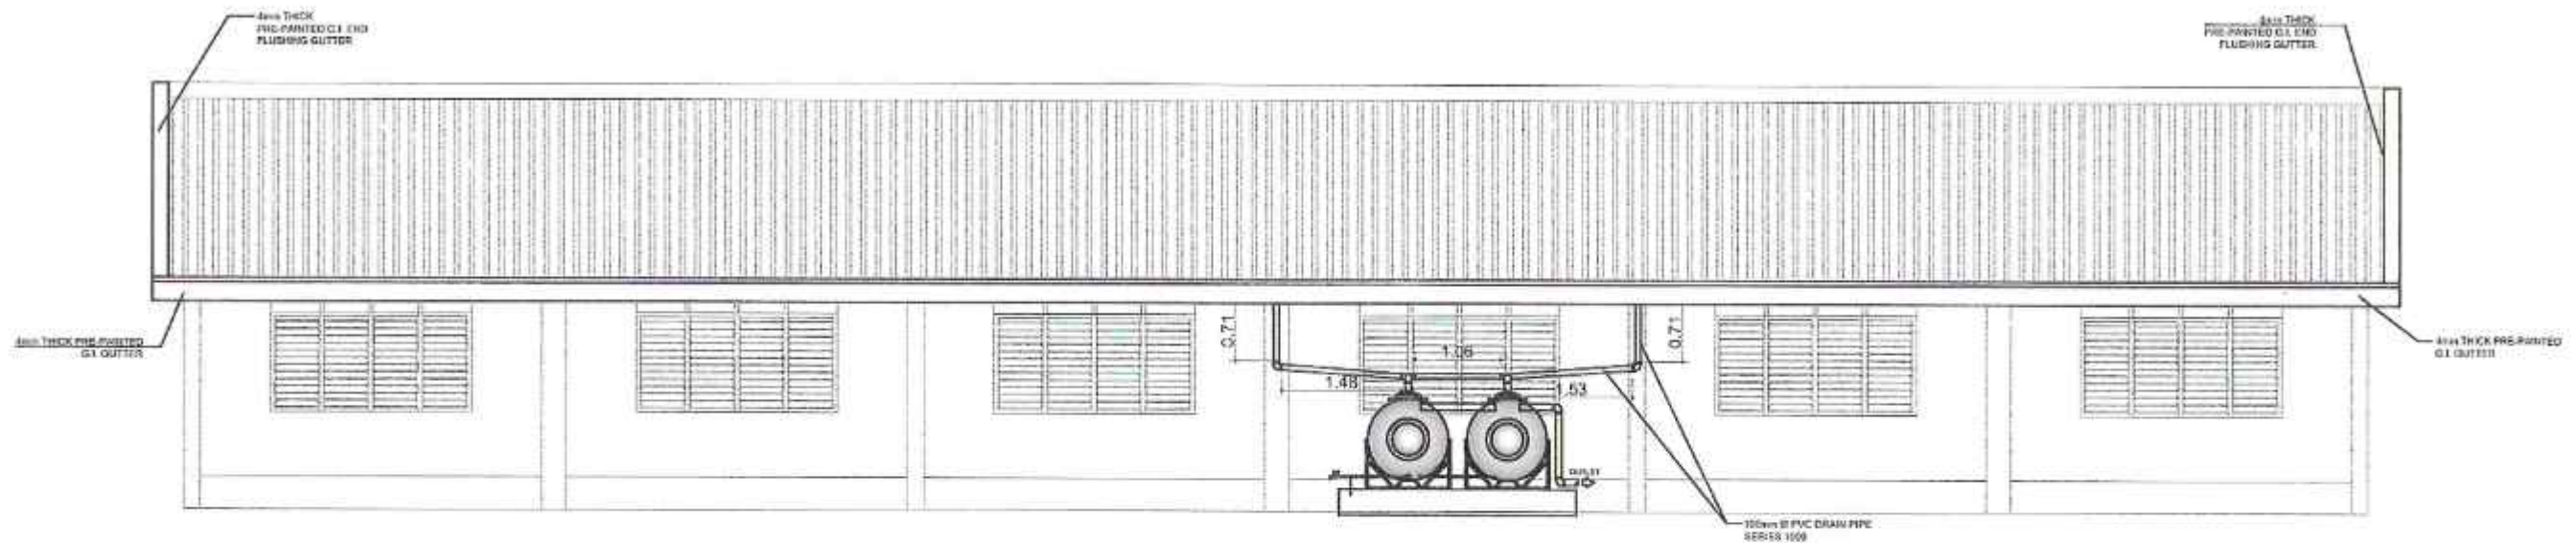

REAR ELEVATION
SCALE 1:50 M.



REPUBLIC OF THE PHILIPPINES
DEPARTMENT OF PUBLIC WORKS AND HIGHWAYS
ZAMBOANGA CITY 2ND DISTRICT ENGINEERING OFFICE
DIVISORIA, ZAMBOANGA CITY

PROJECT NAME AND LOCATION :
CONSTRUCTION OF RAINWATER COLLECTION
SYSTEM (RWCS), DON GREGORIO EVANGELISTA
MEMORIAL SCHOOL, BRGY. STA. CATALINA,
ZAMBOANGA CITY

SHEET CONTENT :
ROOF PLAN
RIGHT SIDE ELEVATION
REAR ELEVATION

DRAFTED :
CHRISTY MARIE R. VALERIANO
ARCHITECT II
PREPARED :
MA. LANIE V. AGBAYANI
ENGINEER - II


REVIEWED BY :
PROFESSIONAL WATER PLUMBER

SUBMITTED :
CAROLYN M. ORBECIDO
CHIEF PLANNING AND DESIGN SECTION
4/22/25


RECOMMENDED :
ROBERTO DONDIE STA. ELENA
ASSISTANT DISTRICT ENGINEER
4/22/25

APPROVED :
PILAR C. RIVERA
DISTRICT ENGINEER
4/22/25


SET NO.:
1
2
SHEET NO.:
RWC-1
02

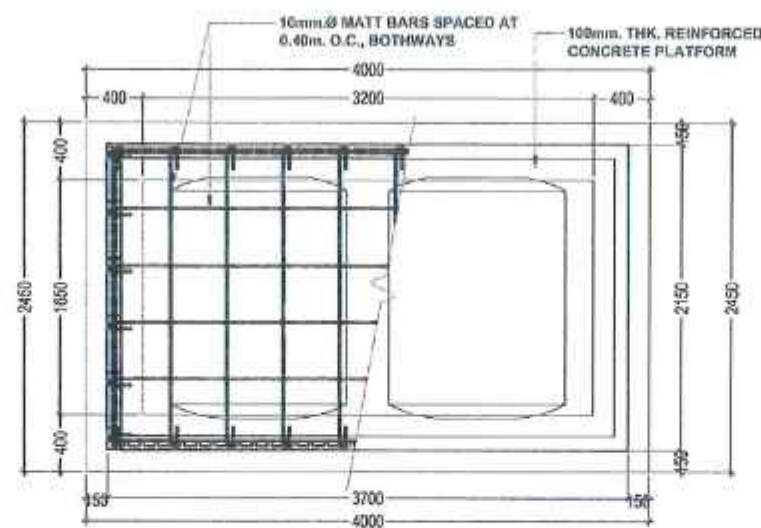 FOUNDATION PLAN


LOCATION PLAN

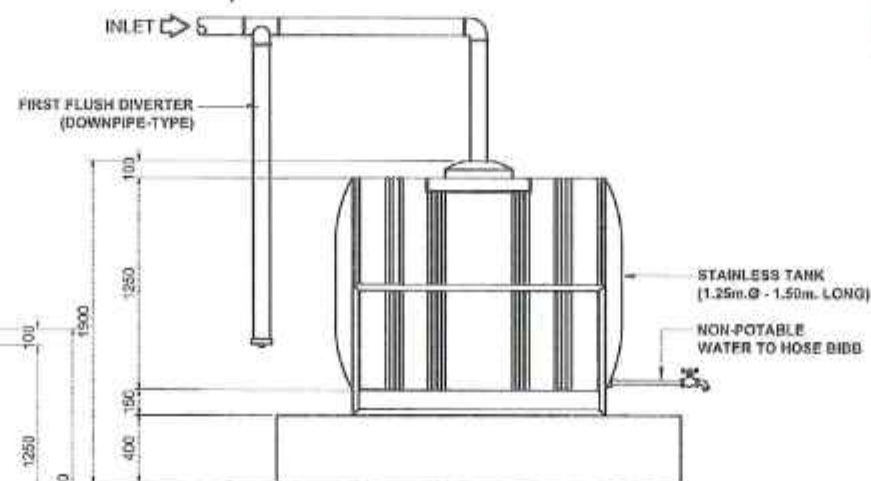


 LEFT-SIDE ELEVATION

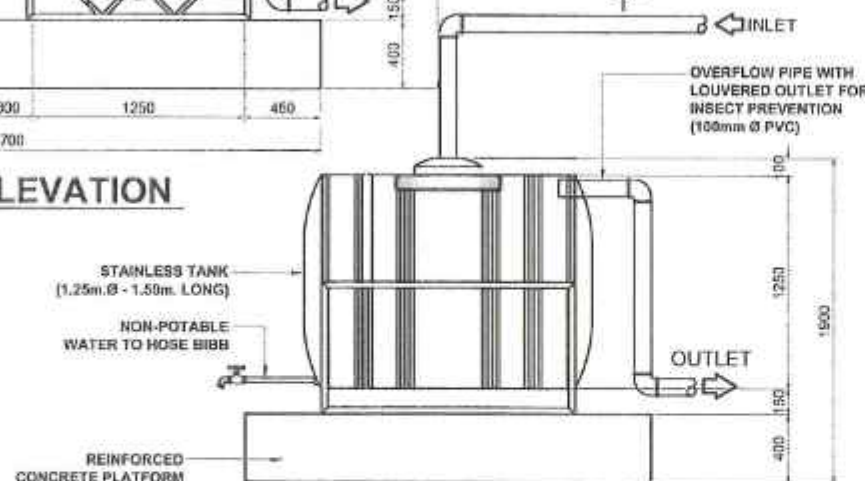


ATION

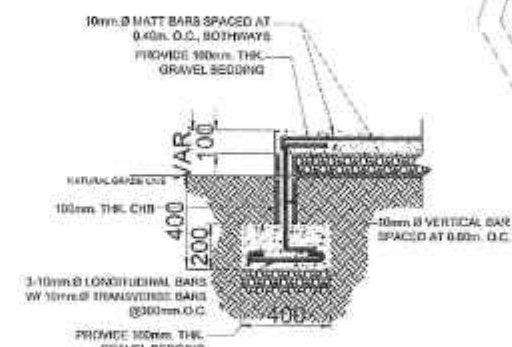

WALL FOOTING SECTION DETAIL

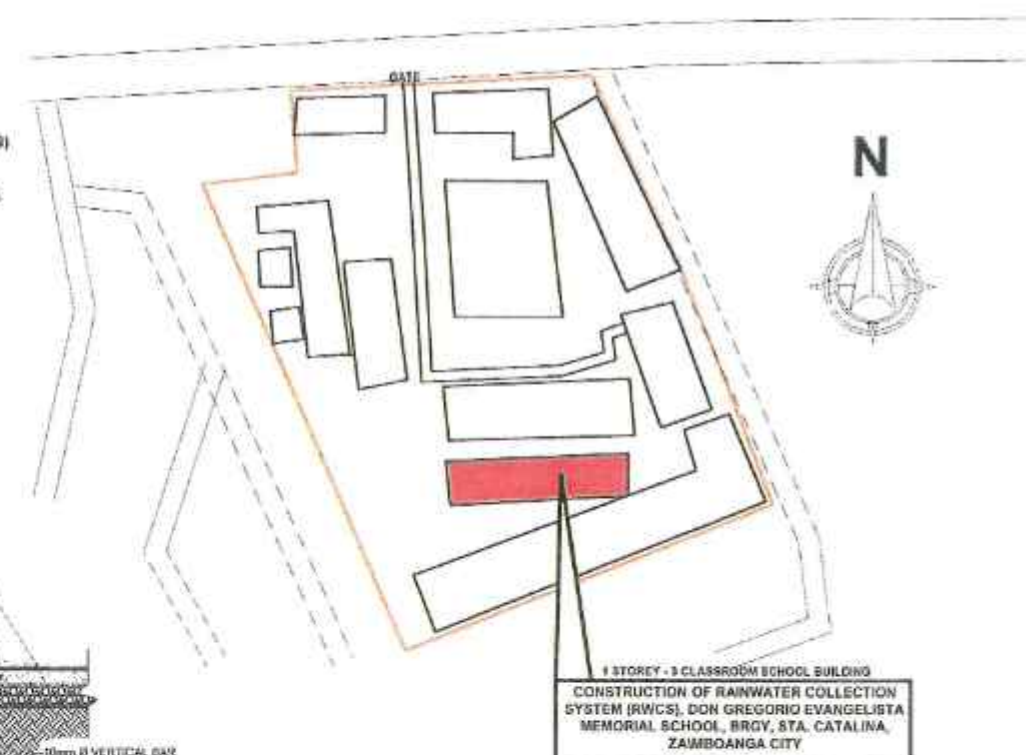

 SITE DEVELOPMENT PLAN

 



REPUBLIC OF THE PHILIPPINES
DEPARTMENT OF PUBLIC WORKS AND HIGHWAYS
ZAMBOANGA CITY 2ND DISTRICT ENGINEERING OFFICE
DIVISORIA, ZAMBOANGA CITY

C.Y. 2025 PROJECT
CONSTRUCTION OF RAINWATER COLLECTION SYSTEM (RWCS),
LUMBAYAO ELEMENTARY SCHOOL, ZAMBOANGA CITY

SUBMITTED:



CAROLYN M. ORBECIDO
CHIEF, PLANNING AND DESIGN SECTION
DATE: 4/21/25

RECOMMENDED:


ROBERTO DONDI F. STA. ELENA
ASSISTANT DISTRICT ENGINEER
DATE: 4/22/25

APPROVED:



PILAR C. RIVERA
DISTRICT ENGINEER
DATE: 4/22/25

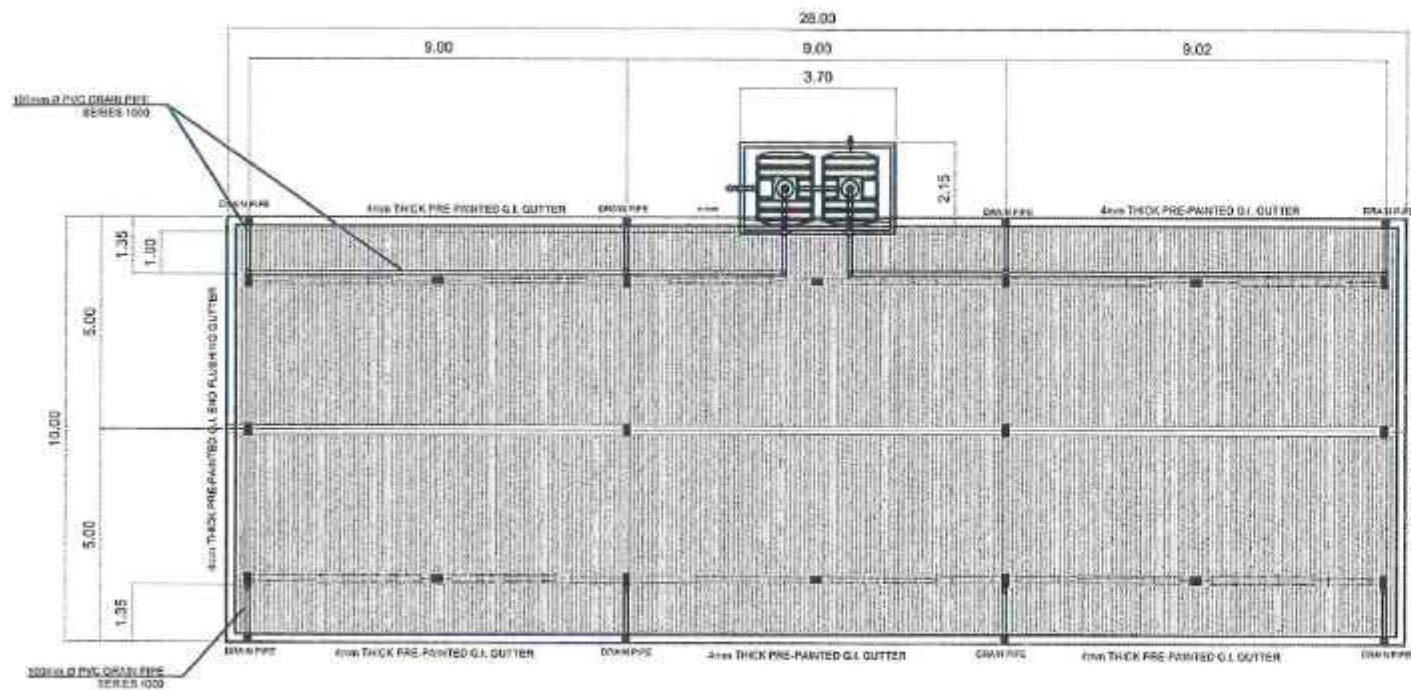

1 STOREY - 3 CLASSROOM SCHOOL BUILDING
ROOF PLAN
SCALE 1:100 M.




RIGHT SIDE ELEVATION
SCALE 1:50 M.

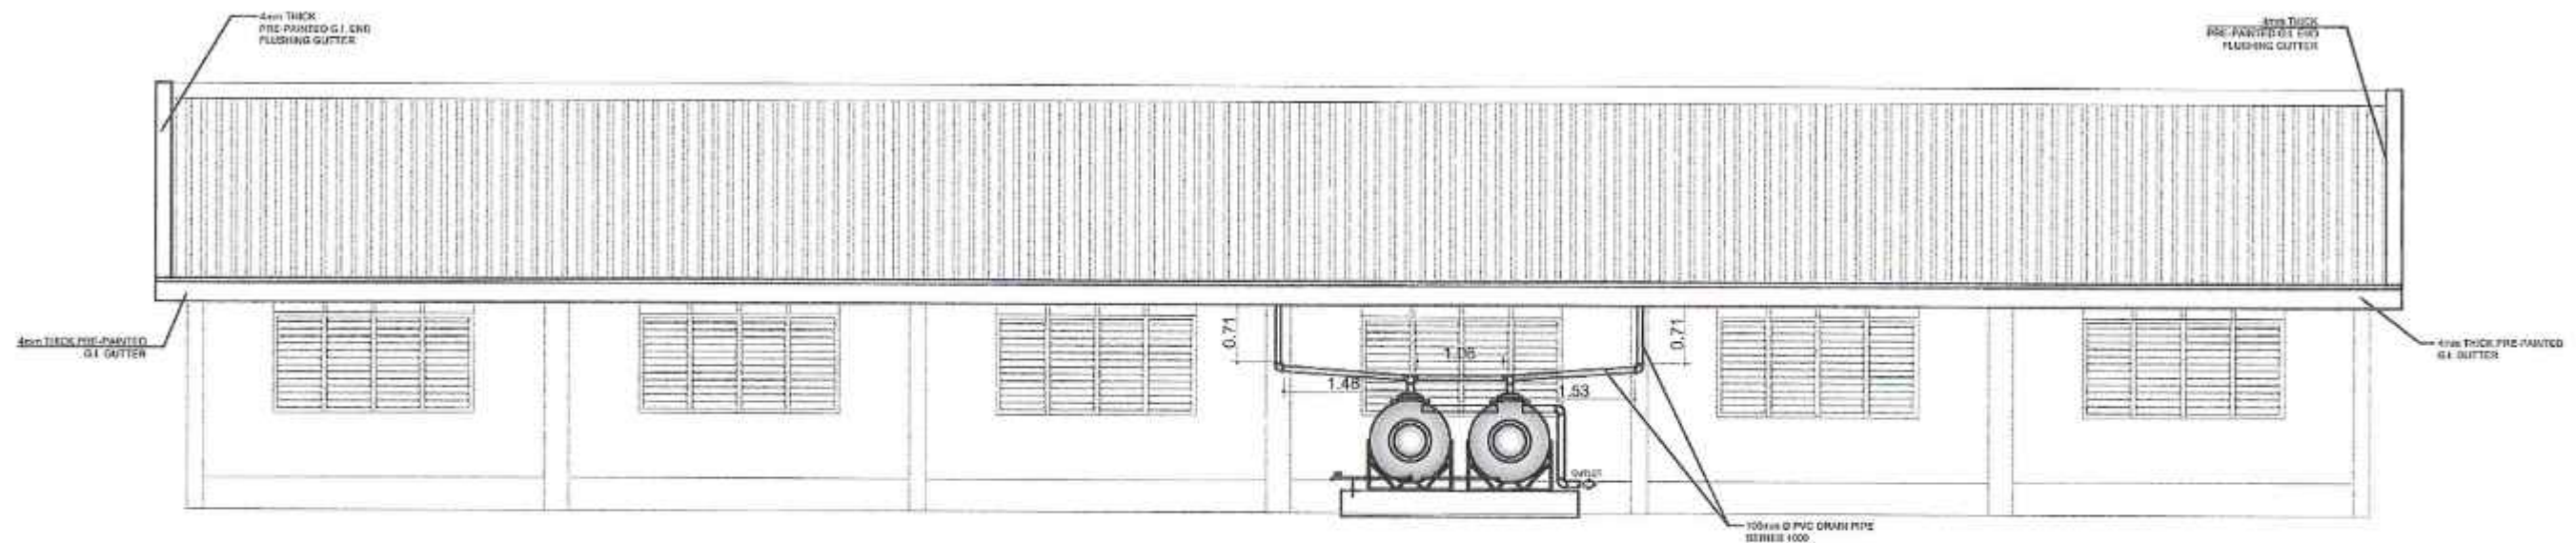

REAR ELEVATION
SCALE 1:50 M.

 REPUBLIC OF THE PHILIPPINES DEPARTMENT OF PUBLIC WORKS AND HIGHWAYS ZAMBOANGA CITY 2ND DISTRICT ENGINEERING OFFICE DIVISORIA, ZAMBOANGA CITY	PROJECT NAME AND LOCATION : CONSTRUCTION OF RAINWATER COLLECTION SYSTEM (RWCS), LUMBAYAO ELEMENTARY SCHOOL, ZAMBOANGA CITY	SHEET CONTENT : ROOF PLAN RIGHT SIDE ELEVATION REAR ELEVATION	DRAFTED : CHRISTY MARIE R. VALERO ARCHITECT II PREPARED : MA. LANIE V. AGBAYANI ENGINEER - II	REVIEWED BY : PROFESSIONAL MASTER PLUMBER	SUBMITTED : CAROLYN M. ORBECIDO CHIEF PLANNING AND DESIGN SECTION 4/23/25	RECOMMENDED : ROBERTO DONDIL F. STA. ELENA ASSISTANT DISTRICT ENGINEER 4/23/25	APPROVED : PILAR C. RIVERA DISTRICT ENGINEER 4/23/25	SET NO: 1 2	SHEET NO: RWC-1 02
--	--	---	---	---	---	--	--	-------------------------------	--------------------------------------

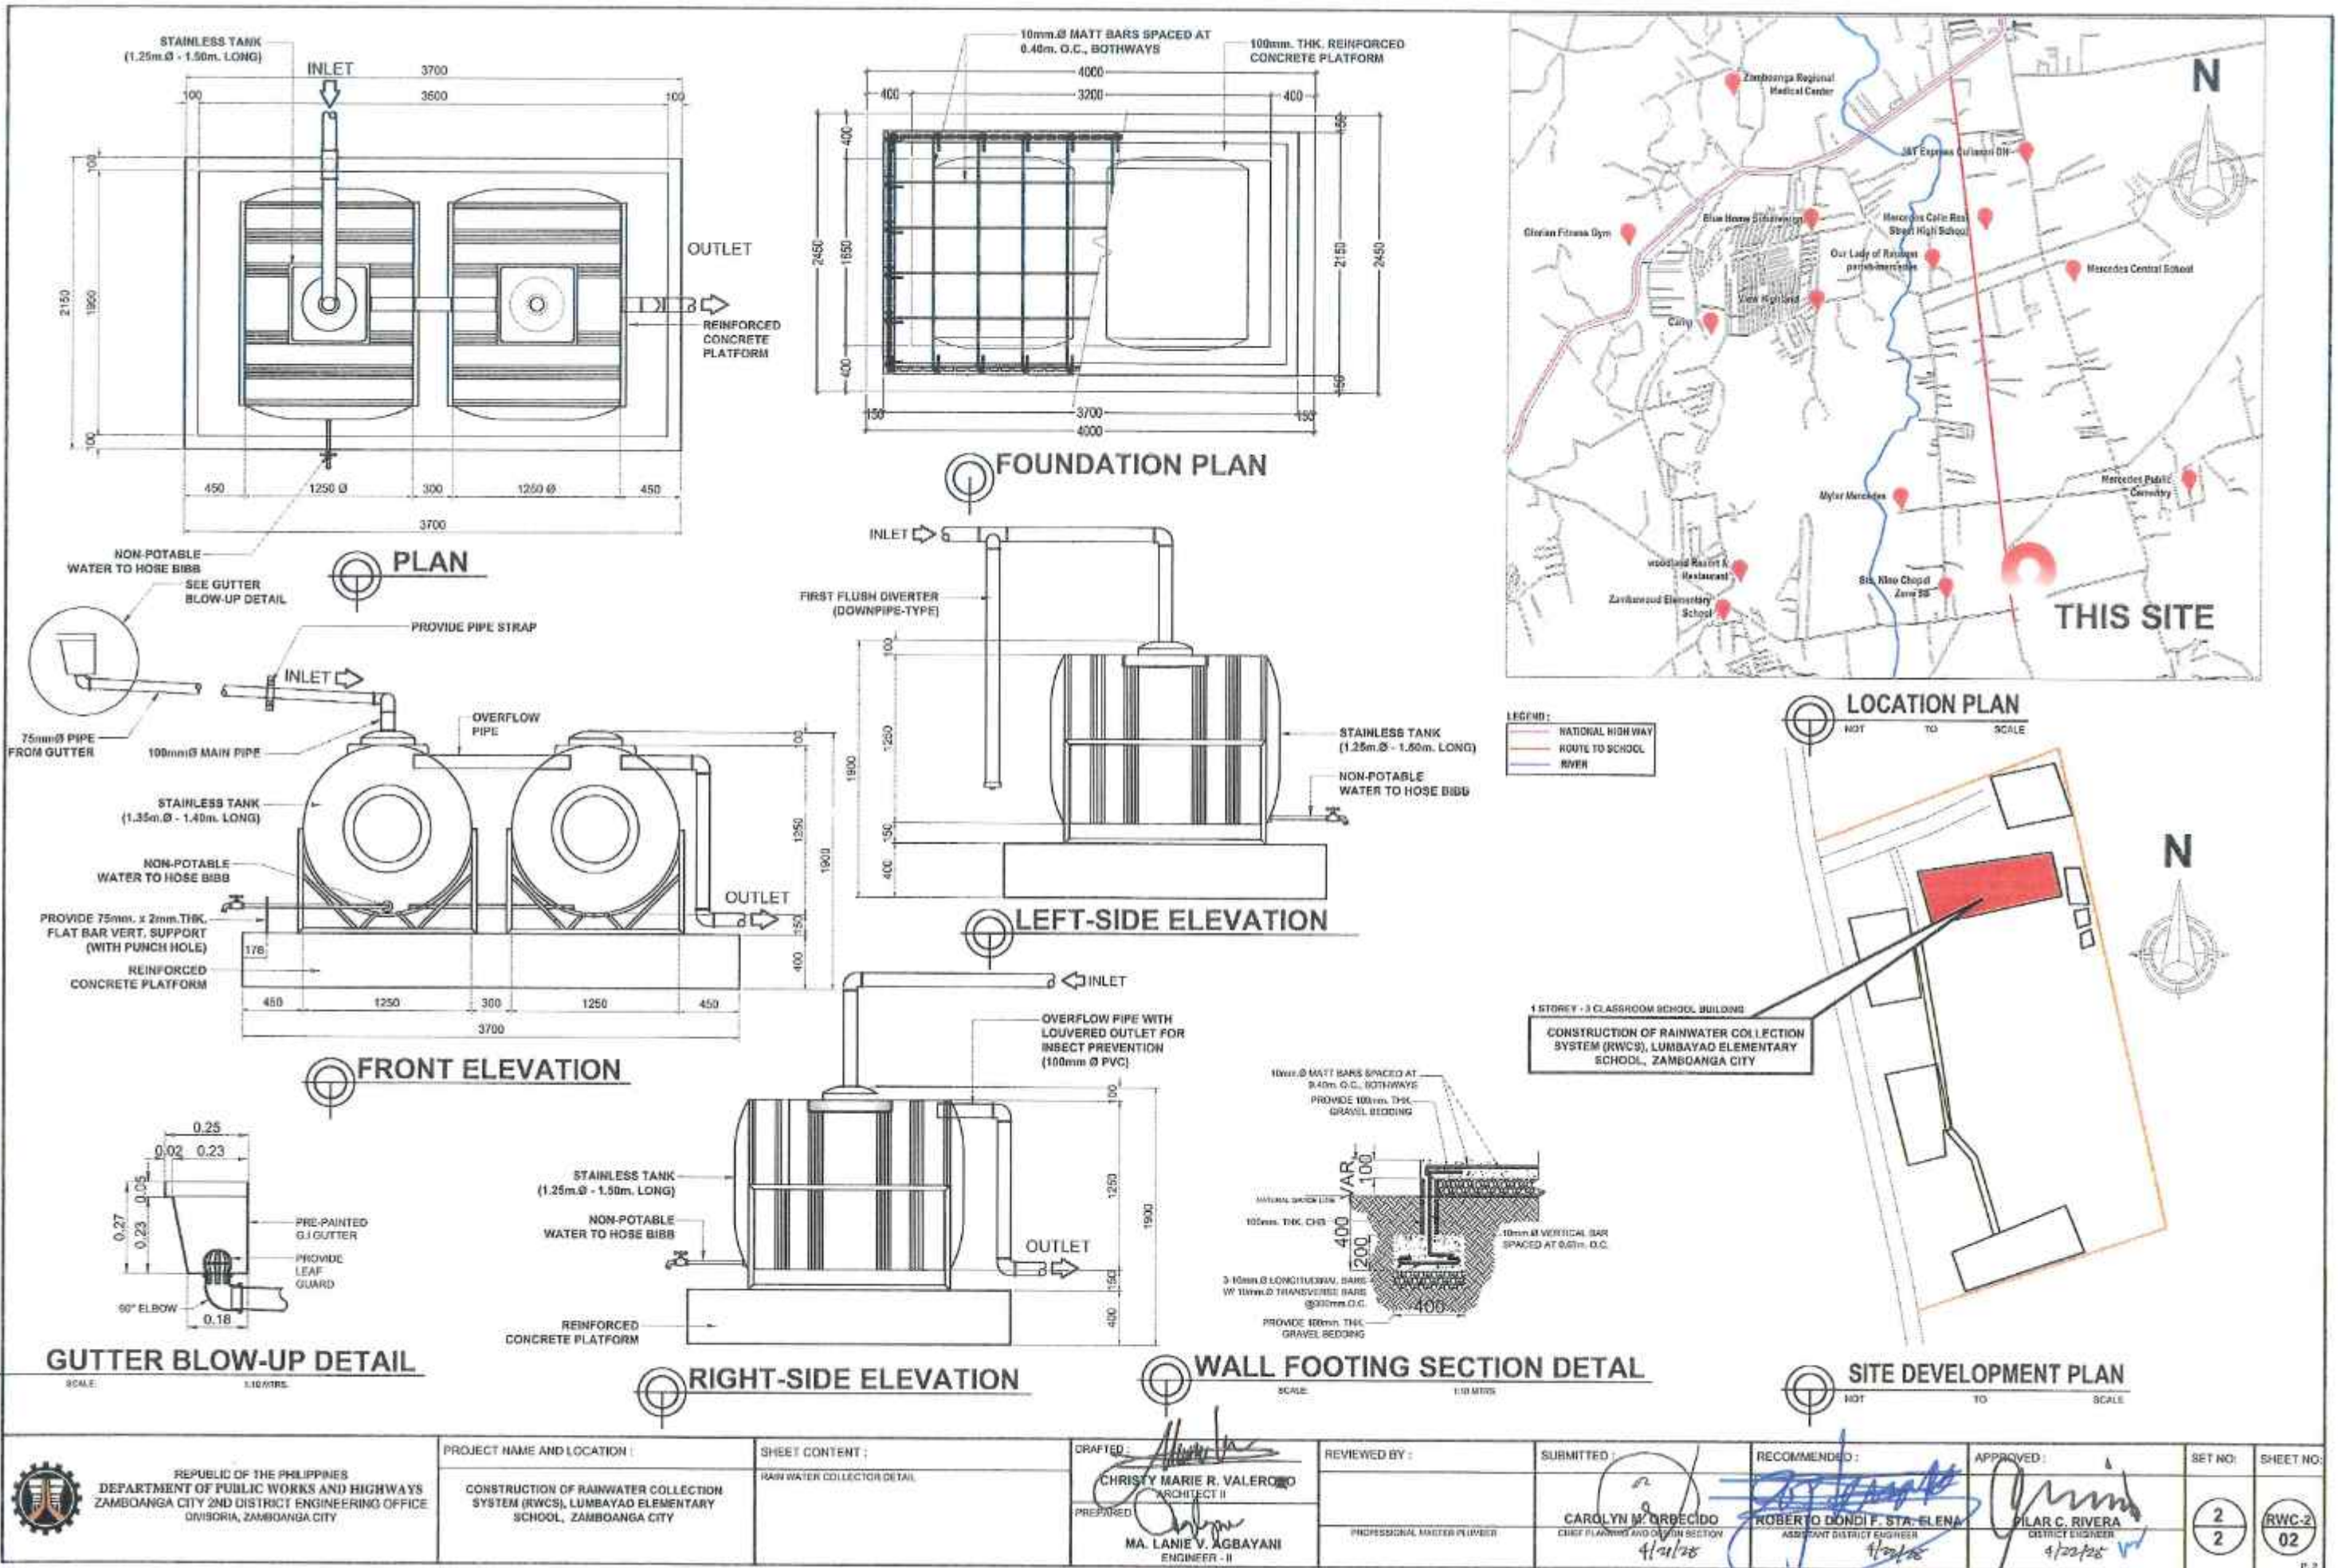



REPUBLIC OF THE PHILIPPINES
DEPARTMENT OF PUBLIC WORKS AND HIGHWAYS
ZAMBOANGA CITY 2ND DISTRICT ENGINEERING OFFICE
DIVISORIA, ZAMBOANGA CITY

C.Y. 2025 PROJECT
CONSTRUCTION OF RAINWATER COLLECTION SYSTEM (RWCS),
MERCEDES CENTRAL SCHOOL, BRGY. MERCEDES,
ZAMBOANGA CITY

SUBMITTED:



CAROLYN M. ORBECIDO
CHIEF, PLANNING AND DESIGN SECTION
DATE: 4/21/25

RECOMMENDED:



ROBERTO DONDI F. STA. ELENA
ASSISTANT DISTRICT ENGINEER
DATE: 4/25/25

APPROVED:



PILAR C. RIVERA
DISTRICT ENGINEER
DATE: 4/22/25

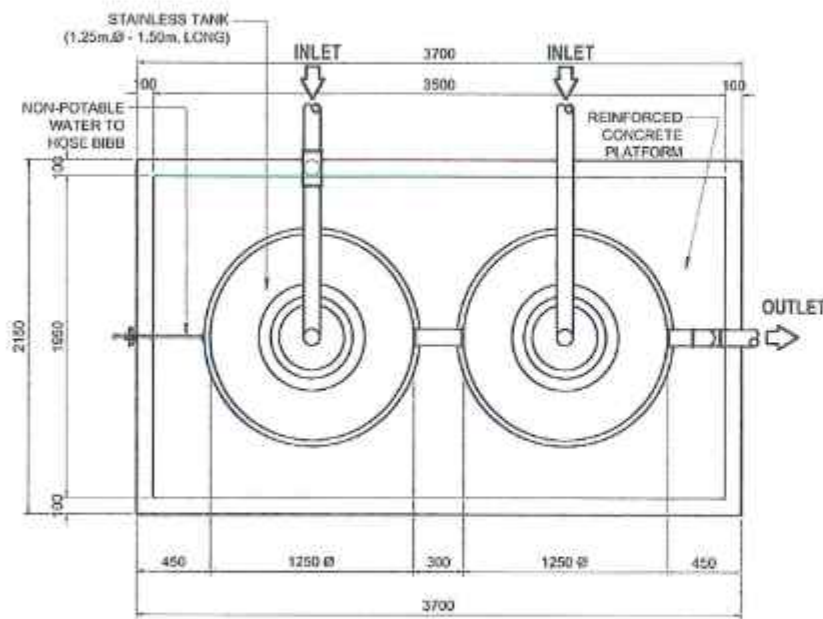


PLAN

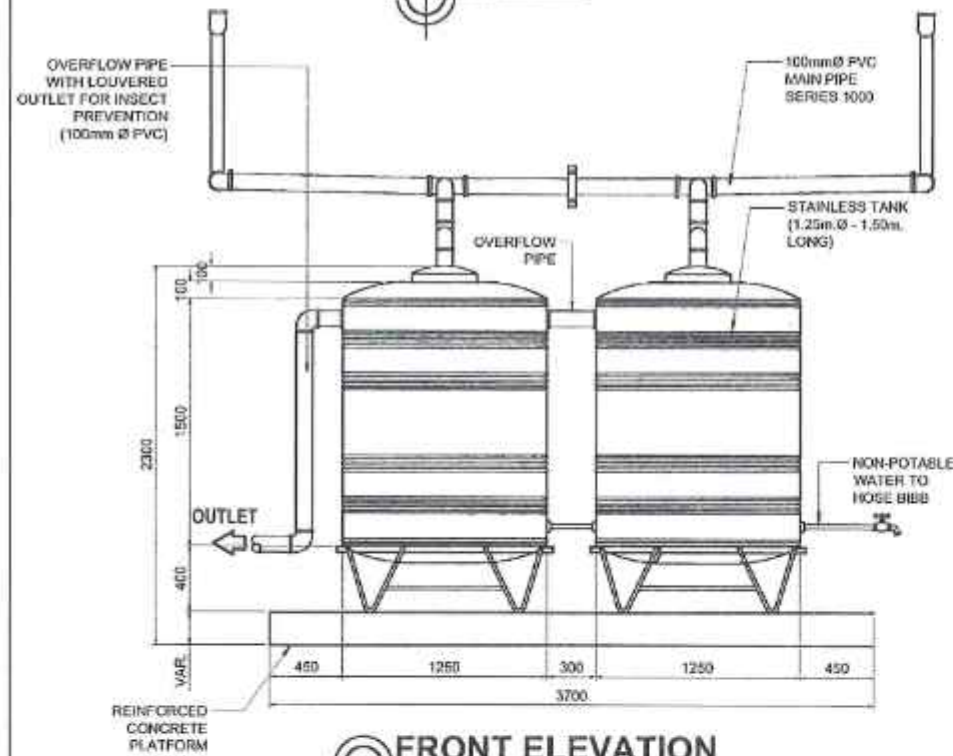


FRONT ELEVATION

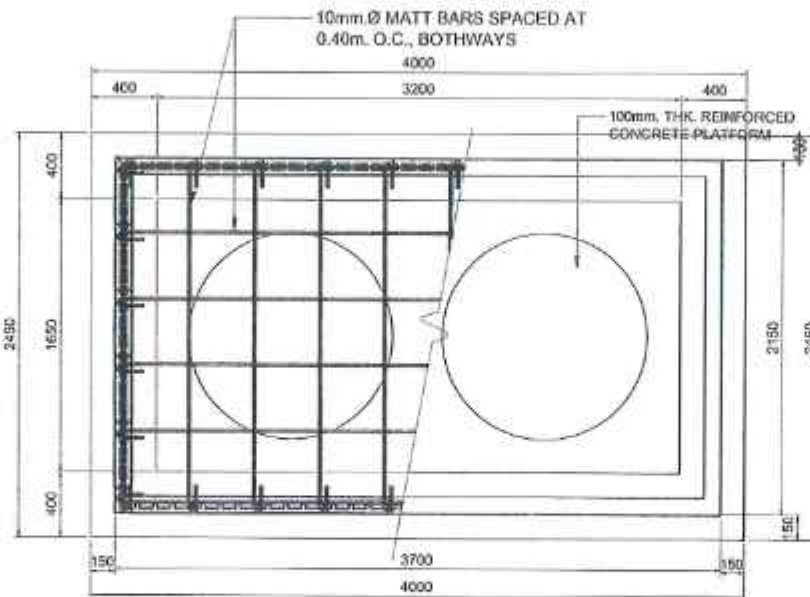


FOUNDATION PLAN

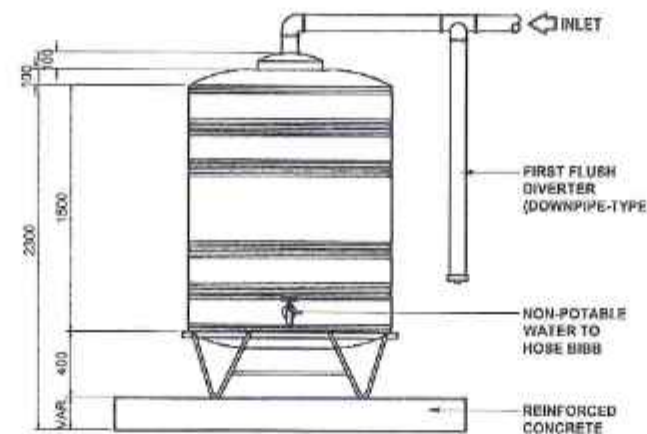


LEFT-SIDE ELEVATION

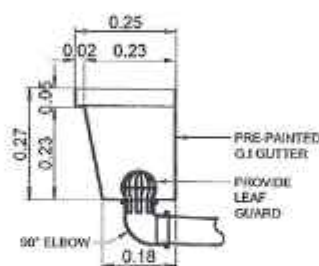


GUTTER BLOW-UP DETAIL

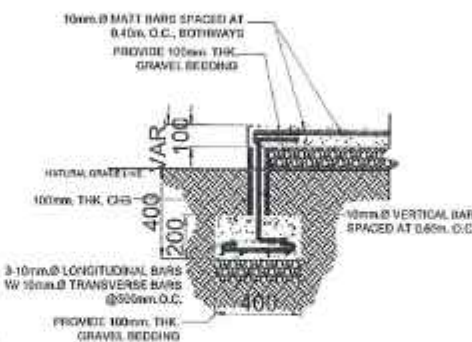

WALL FOOTING SECTION DETAIL

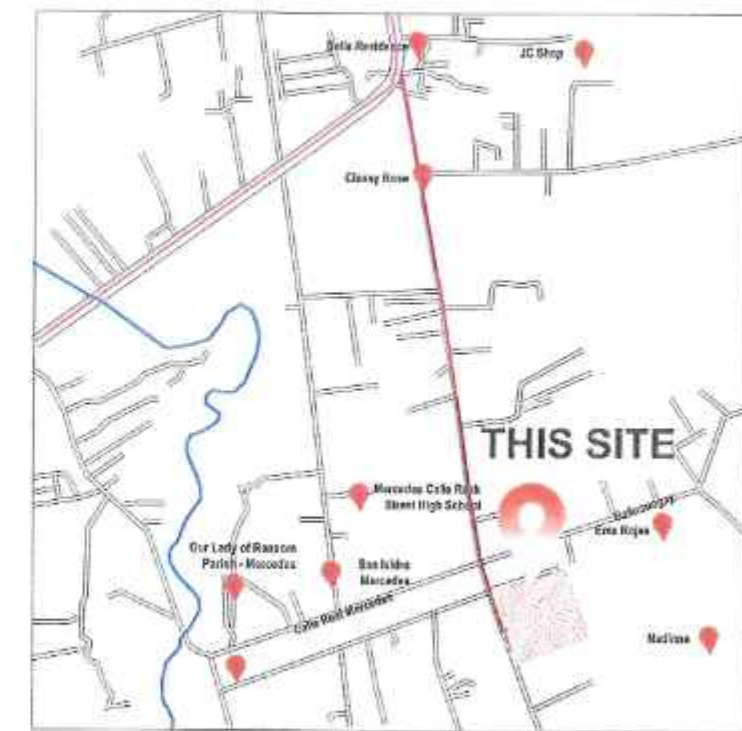

LOCATION PLAN

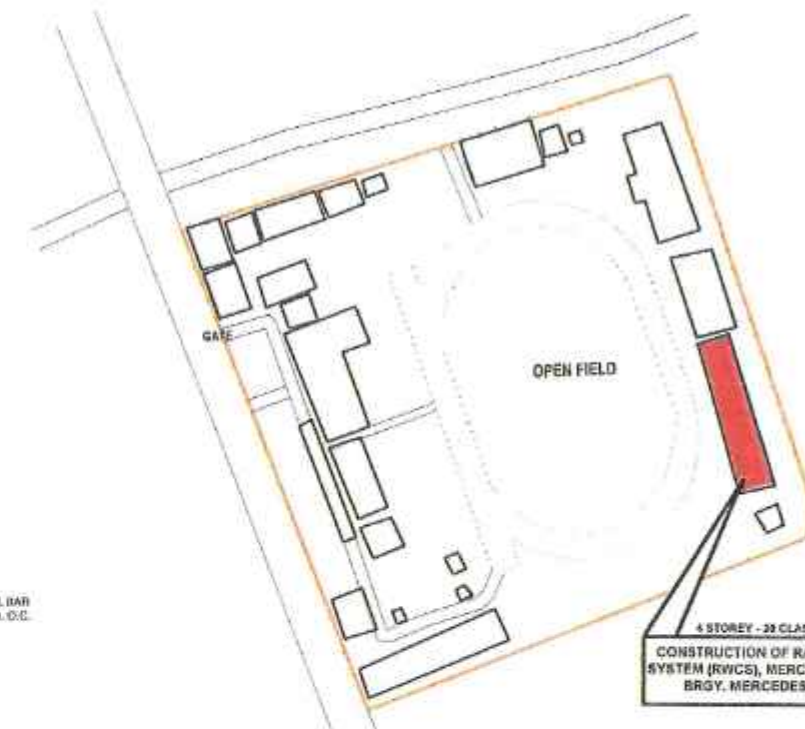

SITE DEVELOPMENT PLAN

RAIN WATER COLLECTION SYSTEM DETAIL



REPUBLIC OF THE PHILIPPINES
DEPARTMENT OF PUBLIC WORKS AND HIGHWAYS
ZAMBOANGA CITY 2ND DISTRICT ENGINEERING OFFICE
DIVISORIA, ZAMBOANGA CITY

C.Y. 2025 PROJECT
CONSTRUCTION OF RAINWATER COLLECTION SYSTEM (RWCS),
TAGUITI ELEMENTARY SCHOOL, BRGY. TAGUITI, ZAMBOANGA
CITY

SUBMITTED:



CAROLYN M. ORBECIDO
CHIEF, PLANNING AND DESIGN SECTION
DATE: 4/21/25

RECOMMENDED:


ROBERTO DONDI E. STA. ELENA
ASSISTANT DISTRICT ENGINEER
DATE: 4/21/25


APPROVED:


PILAR C. RIVERA
DISTRICT ENGINEER
DATE: 4/21/25

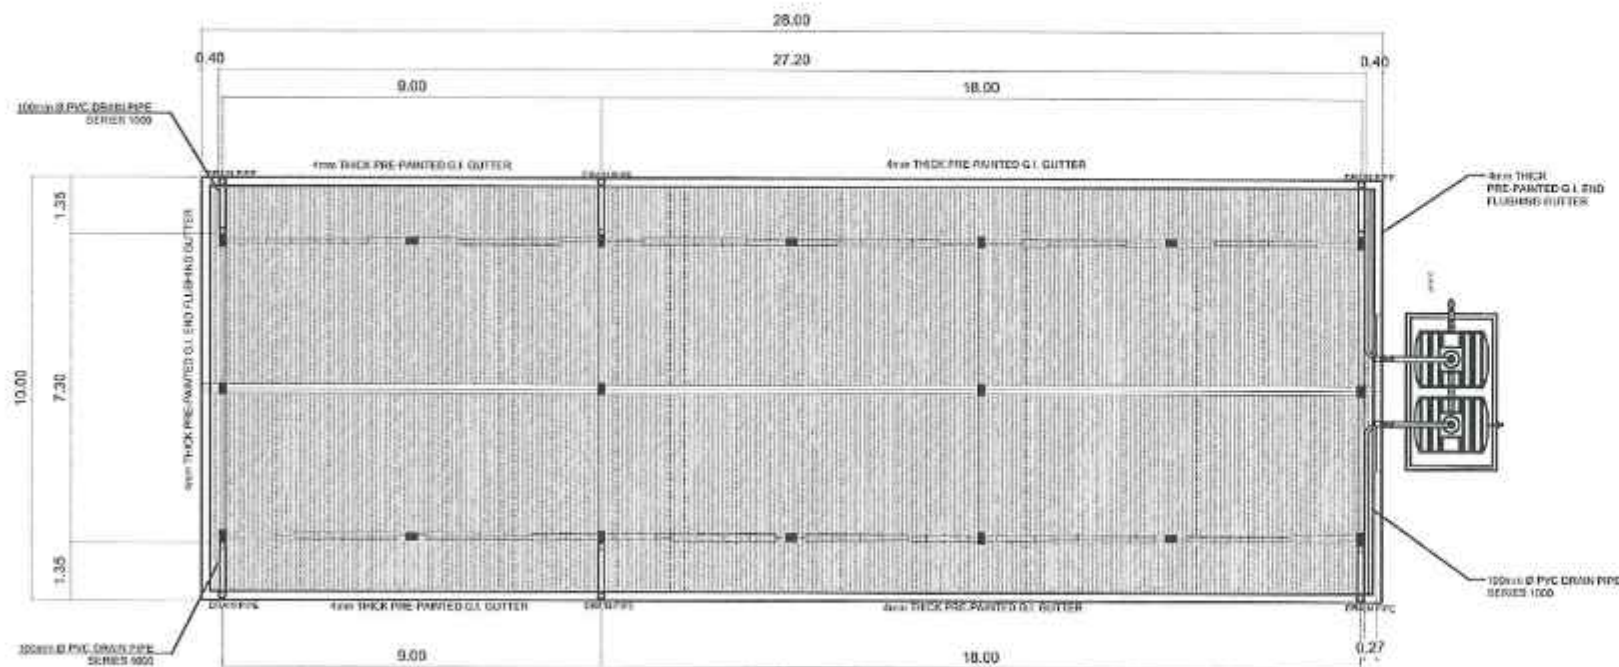


1 STOREY - 3 CLASSROOM SCHOOL BUILDING
ROOF PLAN

SCALE 1:100 M.

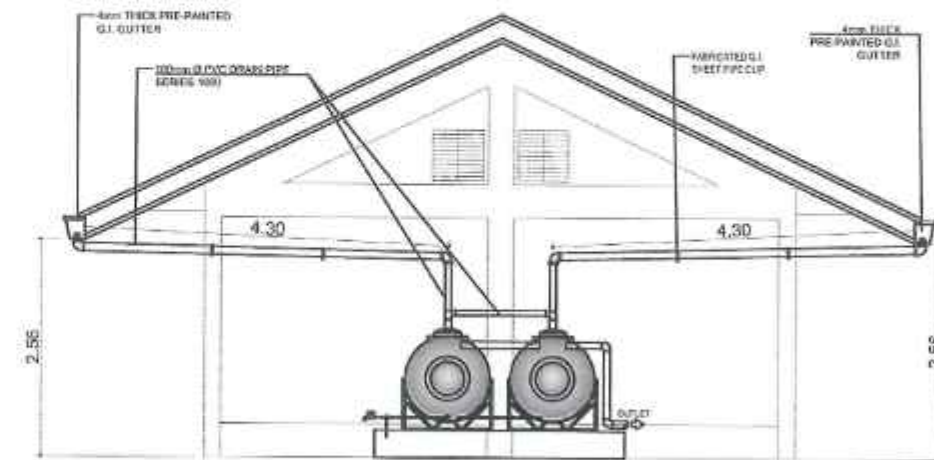

RIGHT SIDE ELEVATION




SCALE 1:50 M.

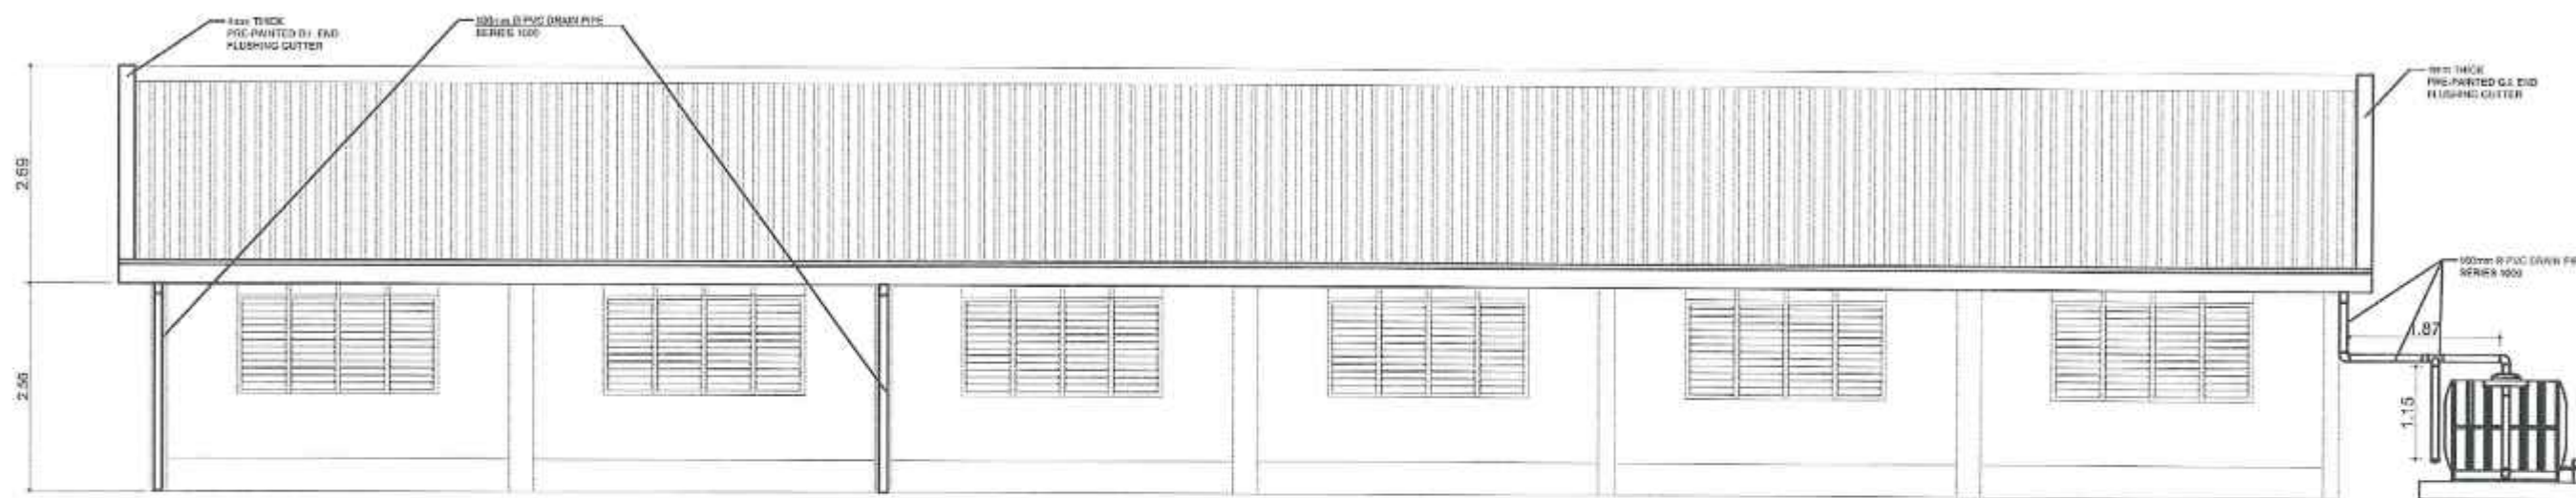



REAR ELEVATION

SCALE 1:50 M.


 REPUBLIC OF THE PHILIPPINES DEPARTMENT OF PUBLIC WORKS AND HIGHWAYS ZAMBOANGA CITY 2ND DISTRICT ENGINEERING OFFICE DIVISORIA, ZAMBOANGA CITY	PROJECT NAME AND LOCATION : CONSTRUCTION OF RAINWATER COLLECTION SYSTEM (RWCS), TAGUITI ELEMENTARY SCHOOL, BRGY. TAGUITI, ZAMBOANGA CITY	SHEET CONTENT : ROOF PLAN RIGHT SIDE ELEVATION REAR ELEVATION	DRAFTED : CHRISTY MARIE R. VALEROSO ARCHITECT II PREPARED : MA. LAMEN, AGBAYANI ENGINEER - II	REVIEWED BY : PROFESSIONAL MASTER PLUMBER	SUBMITTED : CAROLYN M. ONDECIDO CITY PLANNING AND DESIGN SECTION 4/21/25	RECOMMENDED : ROBERTO DONDY F. STA. ELENA ASSISTANT DISTRICT ENGINEER 4/22/25	APPROVED : PILAR C. RIVERA DISTRICT ENGINEER 4/22/25	SET NO. : 1 2	SHEET NO. : RWC-1 02
---	--	---	---	---	--	---	--	---------------------------------	--

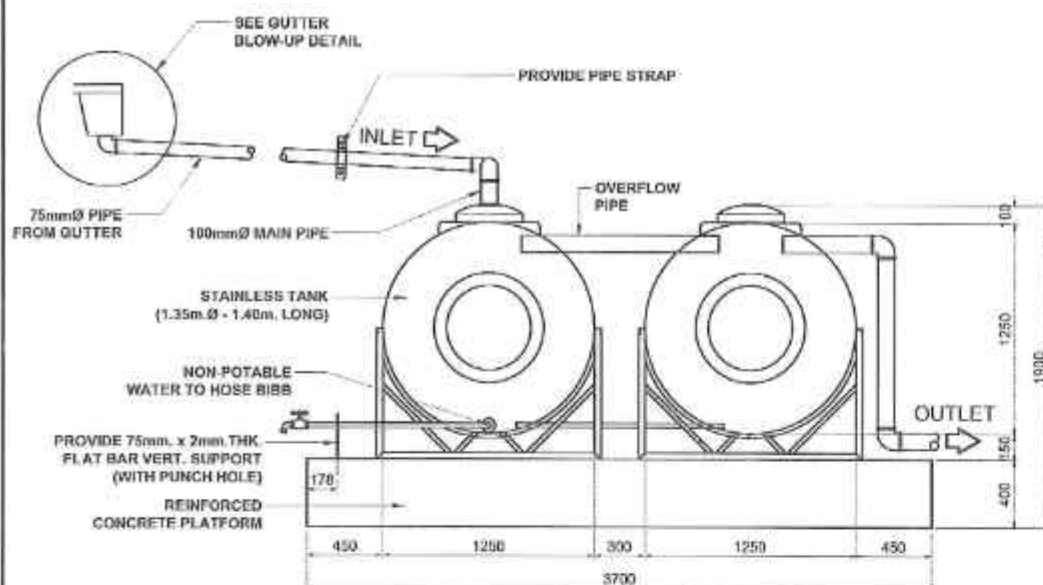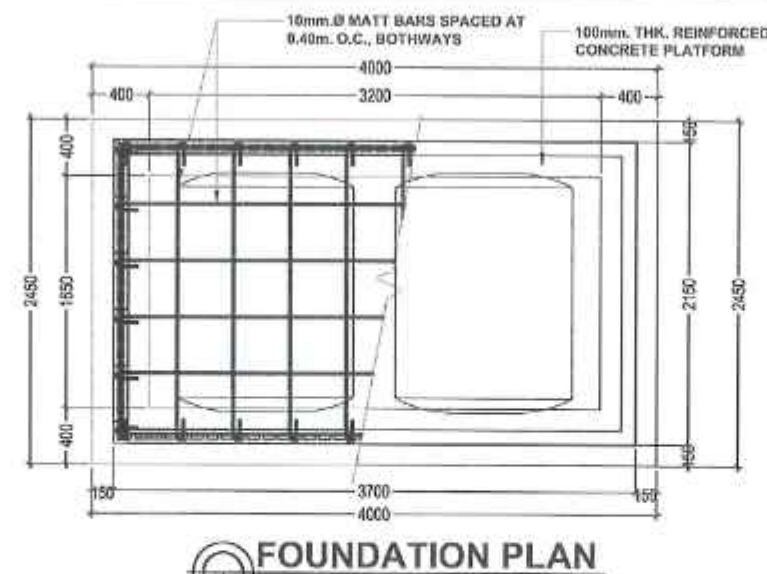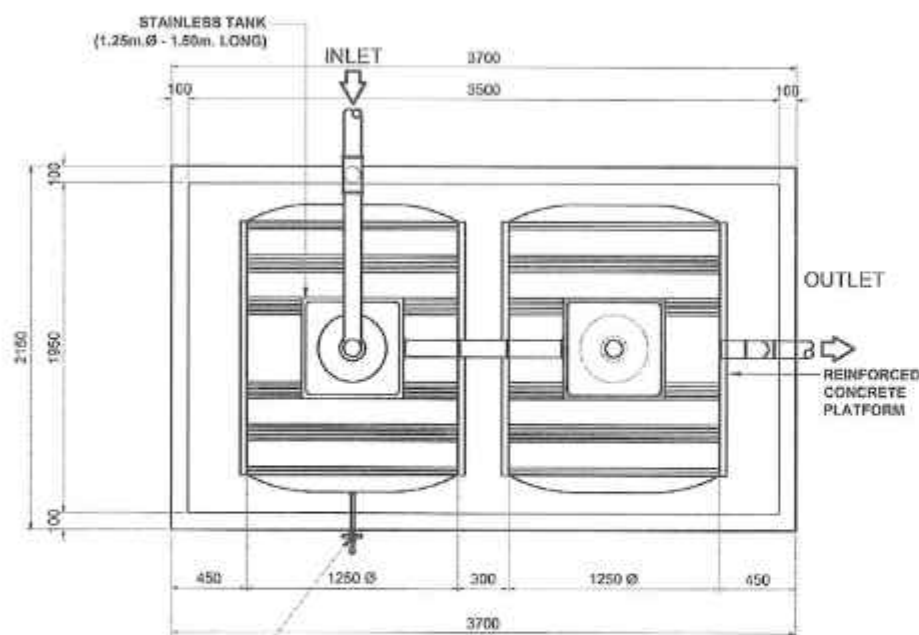


RAIN WATER COLLECTION SYSTEM DETAIL

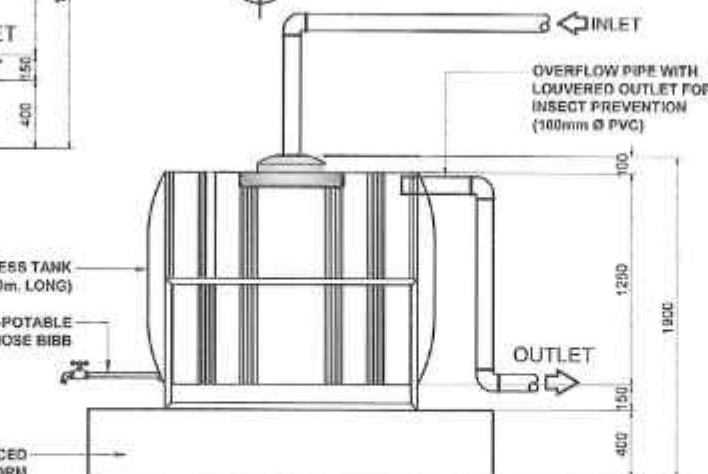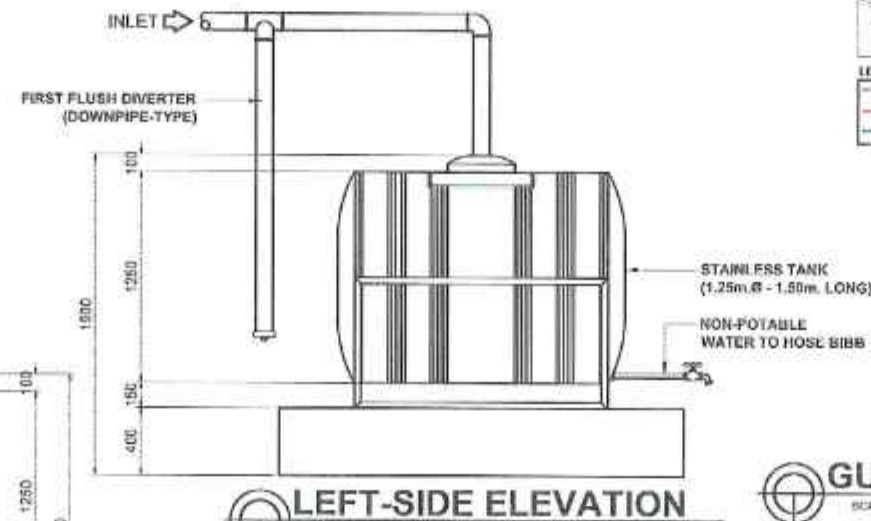


RIGHT-SIDE ELEVATION

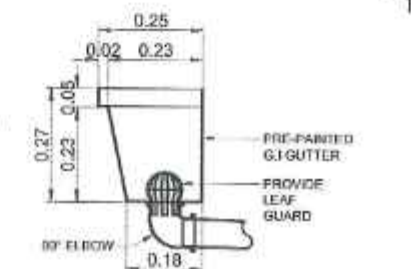

GUTTER BLOW-UP DETAIL

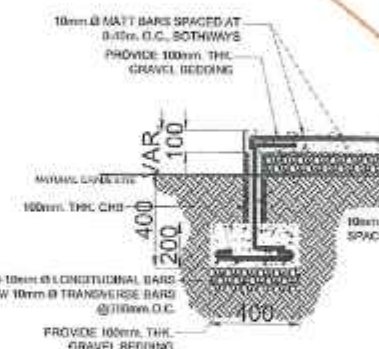

WALL FOOTING SECTION DETAIL

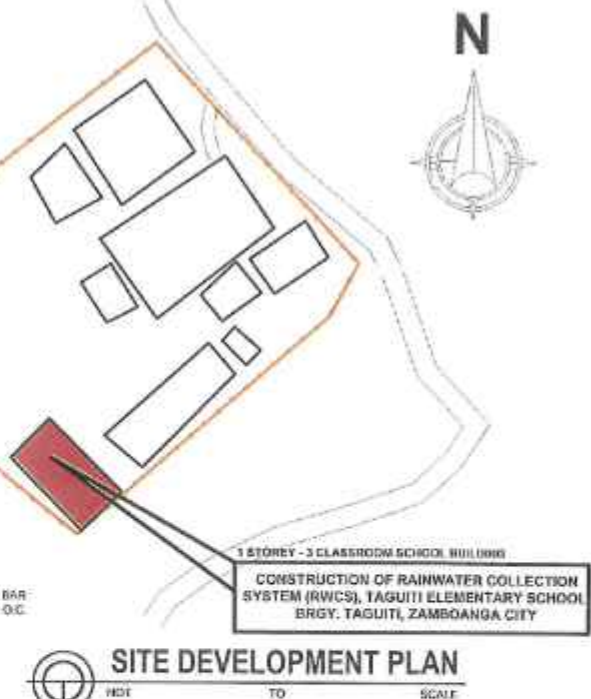

REPUBLIC OF THE PHILIPPINES DEPARTMENT OF PUBLIC WORKS AND HIGHWAYS ZAMBOANGA CITY 2ND DISTRICT ENGINEERING OFFICE DIVISORIA, ZAMBOANGA CITY	PROJECT NAME AND LOCATION: CONSTRUCTION OF RAINWATER COLLECTION SYSTEM (RWCS), TAGUITI ELEMENTARY SCHOOL, BRGY. TAGUITI, ZAMBOANGA CITY	SHEET CONTENT: RAIN WATER COLLECTION DETAIL	DESIGNED BY: CHRISTY MARIE R. VALERO ARCHITECT II PREPARED BY: MA. LAMIE V. AGBAYANI ENGINEER I - II	REVIEWED BY: PROFESSIONAL MASTER PLUMBER	SUBMITTED BY: CAROLYN M. ORBECIDO CHIEF PLANNING AND DESIGN SECTION 4/21/20	RECOMMENDED BY: ROBERTO DENDI F. STA. ELENA ASSISTANT DISTRICT ENGINEER 4/22/20	APPROVED BY: MILAR C. RIVERA DISTRICT ENGINEER 4/22/20	SET NO: 2	SHEET NO: RWC-2 02
---	---	---	--	--	---	---	--	-------------------------	---



REPUBLIC OF THE PHILIPPINES
DEPARTMENT OF PUBLIC WORKS AND HIGHWAYS
ZAMBOANGA CITY 2ND DISTRICT ENGINEERING OFFICE
DIVISORIA, ZAMBOANGA CITY

C.Y. 2025 PROJECT
CONSTRUCTION OF RAINWATER COLLECTION SYSTEM (RWCS),
TUMITUS JUNIOR HIGH SCHOOL ANNEX, BRGY. TUMITUS,
ZAMBOANGA CITY

SUBMITTED:



CAROLYN M. ORBECIDO
CHIEF, PLANNING AND DESIGN SECTION
DATE: 4/22/25

RECOMMENDED:


ROBERTO DONDI F. STA. ELENA
ASSISTANT DISTRICT ENGINEER
DATE: 4/22/25

APPROVED:



PILAR C. RIVERA
DISTRICT ENGINEER
DATE: 4/22/25

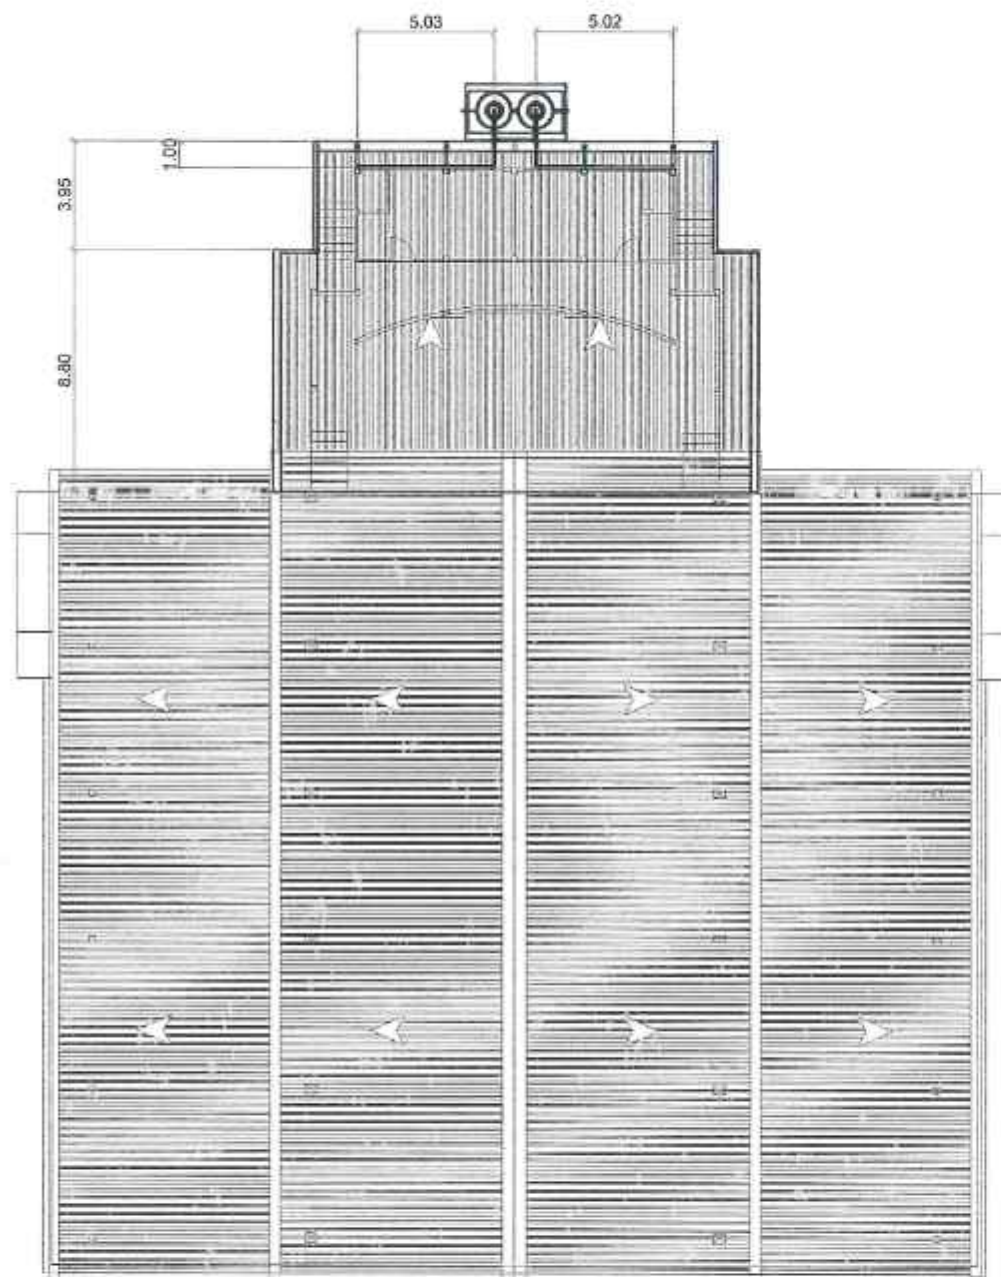

**COVERED COURT - TUMITUS
ROOF PLAN**




SCALE 1:150 M.

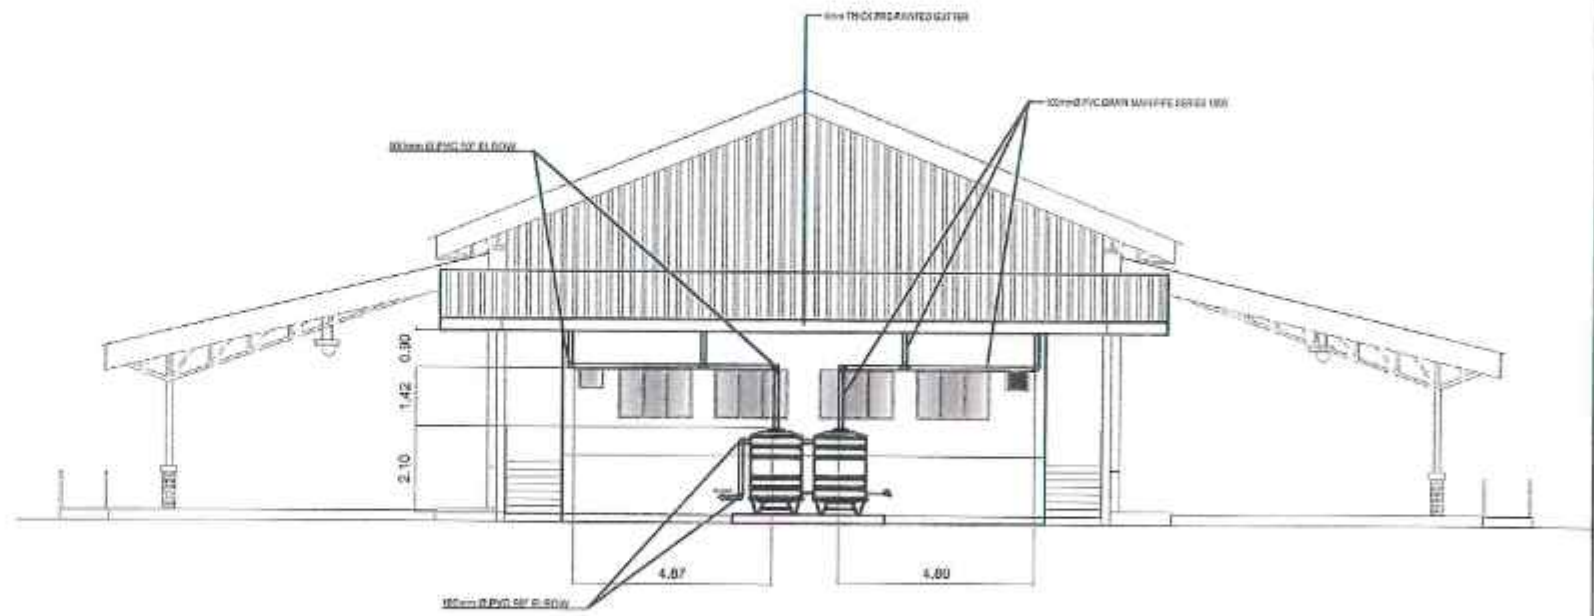

REAR ELEVATION

SCALE 1:100 M.

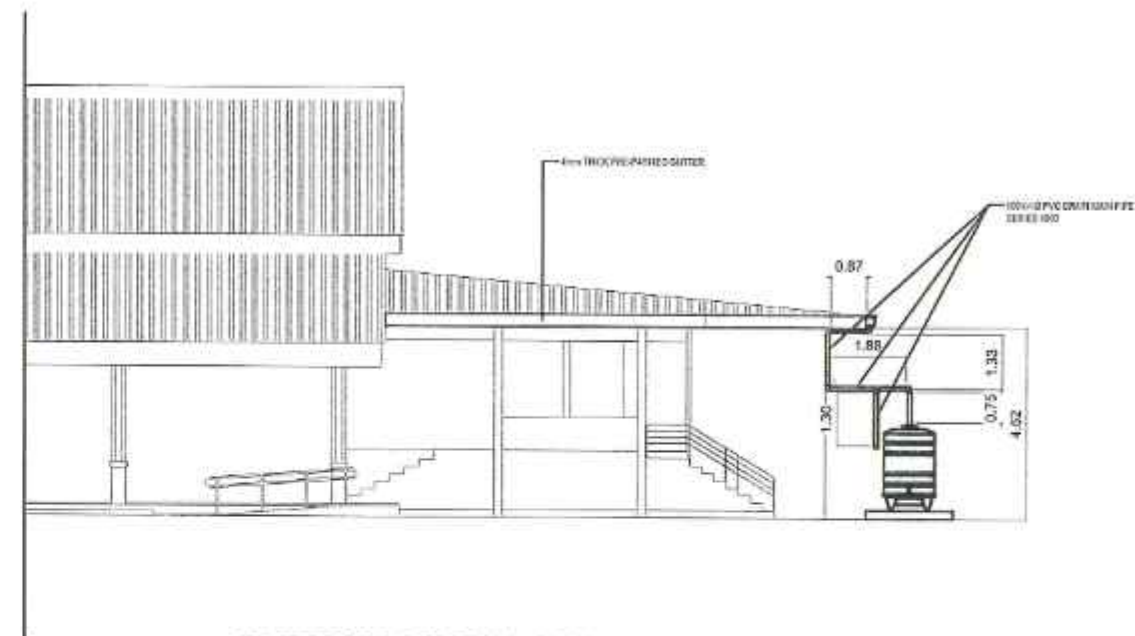

RIGHT SIDE ELEVATION

SCALE 1:100 M.



REPUBLIC OF THE PHILIPPINES
DEPARTMENT OF PUBLIC WORKS AND HIGHWAYS
ZAMBOANGA CITY 2ND DISTRICT ENGINEERING OFFICE
DIVISORIA, ZAMBOANGA CITY

PROJECT NAME AND LOCATION :
CONSTRUCTION OF RAINWATER COLLECTION
SYSTEM (RWCS), TUMITUS JUNIOR HIGH SCHOOL
ANNEX, BRGY. TUMITUS, ZAMBOANGA CITY

SHEET CONTENT :
ROOF PLAN
RIGHT SIDE ELEVATION
REAR ELEVATION

DRAFTED :
CHRISTY MARIE R. VALEROZO
ARCHITECT II
PREPARED :
MA. LANIE V. ABBAYANI
ENGINEER - II

REVIEWED BY :
PROFESSIONAL MASTER PLANNER


SUBMITTED :
CAROLYN M. ORDECIDO
CHIEF PLANNER AND CAD SECTION
4/22/25

RECOMMENDED :
ROBERTO GONDI F. STA. ELENA
ASSISTANT DISTRICT ENGINEER
4/22/25


APPROVED :
PILAR C. RIVERA
DISTRICT ENGINEER
4/22/25

SET NO:
1
2


SHEET NO:
RWC-1
02
P.1

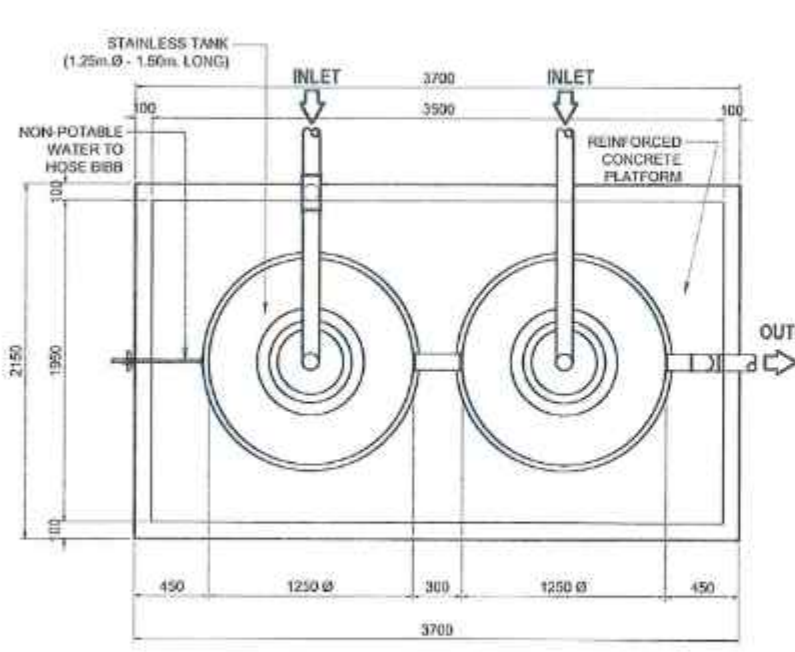


PLAN

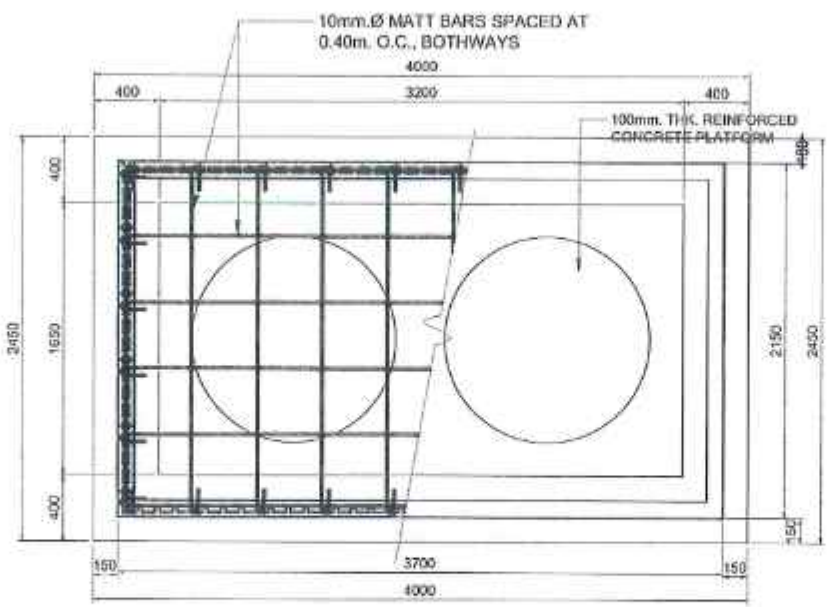


FOUNDATION PLAN

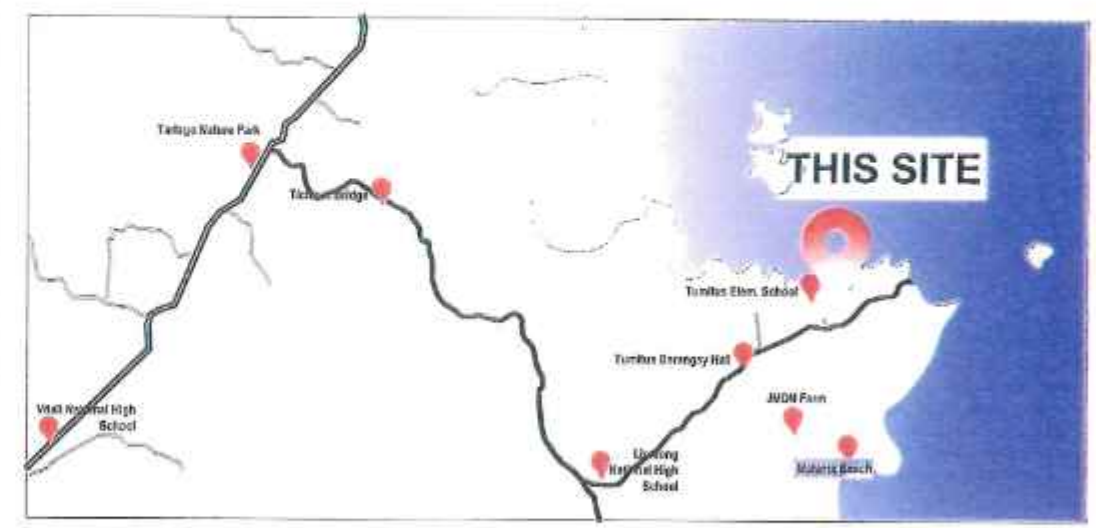


LOCATION PLAN

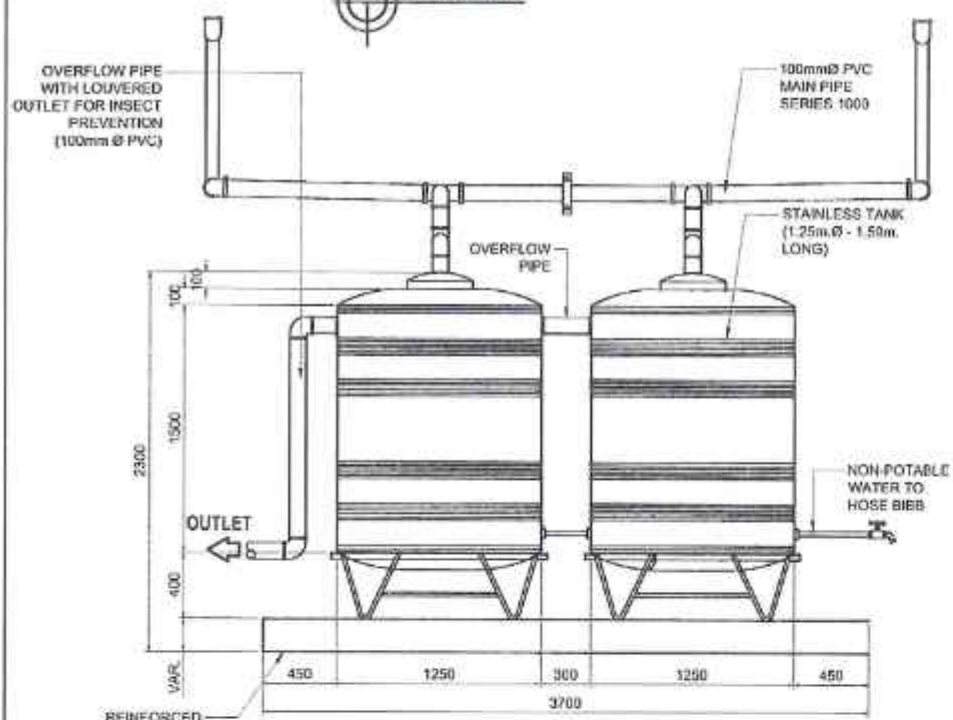


FRONT ELEVATION

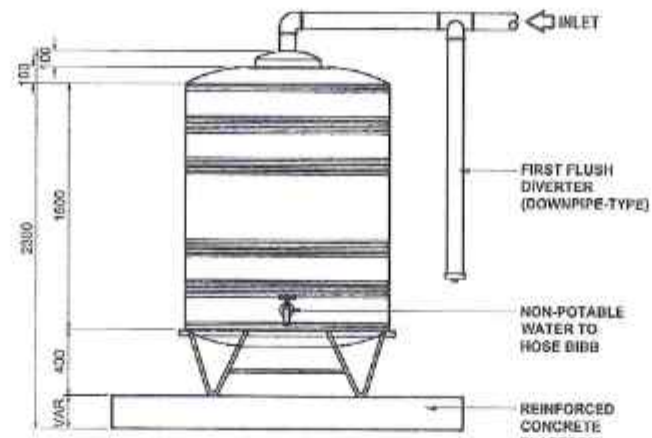


LEFT-SIDE ELEVATION

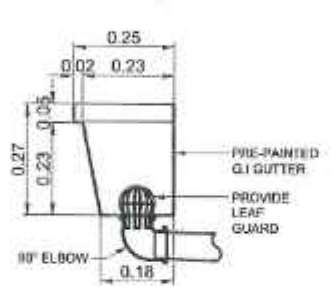

GUTTER BLOW-UP DETAIL

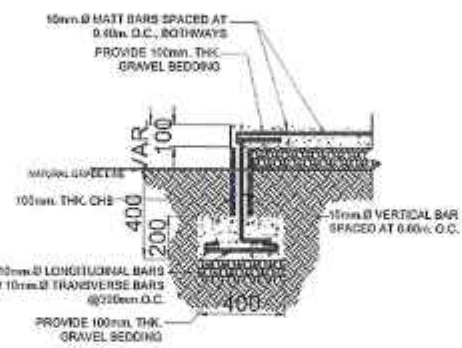

WALL FOOTING SECTION DETAIL

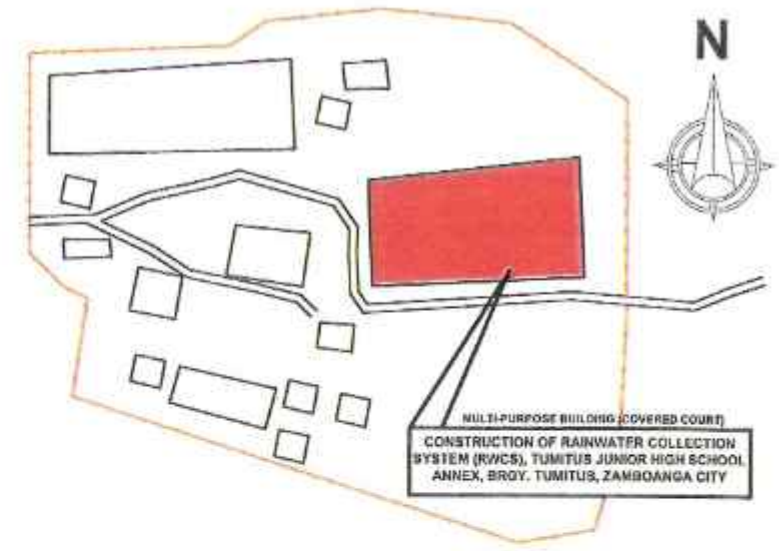

SITE DEVELOPMENT PLAN

RAIN WATER COLLECTION SYSTEM DETAIL

REPUBLIC OF THE PHILIPPINES DEPARTMENT OF PUBLIC WORKS AND HIGHWAYS ZAMBOANGA CITY 2ND DISTRICT ENGINEERING OFFICE DIVISORIA, ZAMBOANGA CITY	PROJECT NAME AND LOCATION: CONSTRUCTION OF RAINWATER COLLECTION SYSTEM (RWCS), TUMTUS JUNIOR HIGH SCHOOL ANNEX, BRGY. TUMTUS, ZAMBOANGA CITY	SHEET CONTENT: RAIN WATER COLLECTOR DETAIL	DRAFTED: CHRISTY MARIE R. VALEROZO ARCHITECT II PREPARED: MA. LANIE V. AGBAYANI ENGINEER - II	REVIEWED BY: PROFESSIONAL MASTER PLANNER	SUBMITTED: CAROLYN M. ORSECIDO CHIEF PLANNING AND DESIGN SECTION 4/21/25	RECOMMENDED: ROBERTO DOMESTICO, BSA, ELENA ASSISTANT DISTRICT ENGINEER 4/22/25	APPROVED: PIJAR C. RIVERA DISTRICT ENGINEER 4/22/25	SET NO: 2 2	SHEET NO: RWC-2 02
---	--	--	---	--	--	--	---	-------------------------------	--------------------------------------