



REPUBLIC OF THE PHILIPPINES
DEPARTMENT OF PUBLIC WORKS AND HIGHWAYS
REGIONAL OFFICE NO. V
MASBATE 2ND DISTRICT ENGINEERING OFFICE
CAPITOL ROAD, CITY OF MASBATE

C.Y. 2025 PROJECT
DETAILED ENGINEERING DESIGN PLAN FOR
REPAIR / MAINTENANCE OF DPWH BUILDING
MASBATE II DISTRICT ENGINEERING OFFICE
AES MAIN REPAIR BASE SHOP (PHASE III),
AIRPORT ROAD, MASBATE CITY
AIRPORT ROAD, MASBATE CITY

SUBMITTED:

BONIFACIO A. TABIGUE
CHIEF, MAINTENANCE SECTION

DATE:

RECOMMENDED:

MARIA ARRA PAZ G. SELLAR
OIC - ASSISTANT DISTRICT ENGINEER

DATE:

APPROVED:

DENIS C. CAGMOC
DISTRICT ENGINEER

DATE:

BILL OF QUANTITIES

ITEM NO.	DESCRIPTION	UNIT	QUANTITY	REMARKS
PART A - FACILITIES FOR THE ENGINEER				
A.1.1(6)	PROVISION OF COMBINED FIELD OFFICE, LABORATORY & LIVING QUARTERS BUILDING FOR THE ENGINEER (RENTAL BASIS)	mos.	2.00	
PART B - OTHER GENERAL REQUIREMENTS				
B.5 (1)	PROJECT BILLBOARD / SIGNBOARD	each	1.00	
B.7 (1)	OCCUPATIONAL SAFETY AND HEALTH PROGRAM	l.s.	1.00	
B.9 (1)	MOBILIZATION / DEMOBILIZATION	l.s.	1.00	
DIVISION I - GENERAL				
PART C - EARTHWORK				
B01(1)	REMOVAL OF STRUCTURES OBSTRUCTION	l.s.	1.00	
DIVISION II - BUILDINGS				
PART E - FINISHING AND OTHER CIVIL WORKS				
1001(10)	PIPES WITH FITTINGS CONNECTION	l.s.	1.00	
1011(1)a	ROLL-UP DOOR, STEEL	set.	1.00	
1013(2)a	FABRICATED METAL ROOFING ACCESSORY, GAUGE 26 (0.551mm), RIDGE/HIP ROLLS	li.m	46.36	
1013(2)c	FABRICATED METAL ROOFING ACCESSORY, GAUGE 26 (0.551mm), GUTTERS	li.m	46.36	
1014(1)b2	PRE-PAINTED METAL SHEETS ABOVE 0.427mm, RIB TYPE, LONG SPAN	li.m	754.20	
1032(1)c	PAINTING WORKS (STEEL)	sq.m	1837.26	
1047(1)	METAL STRUCTURES	kg.	152.88	
1047(8)b	STRUCTURAL STEEL, PURLINS	kg.	250.95	



Republic of the Philippines
DEPARTMENT OF PUBLIC WORKS AND HIGHWAYS
MASBATE 2ND DISTRICT ENGINEERING OFFICE
City of Masbate, Masbate, Region V

PROJECT NAME AND LOCATION:
REPAIR - MAINTENANCE OF DPWH BUILDING
MASBATE II DISTRICT ENGINEERING OFFICE
MAIN REPAIR BASE SHOP
AIRPORT ROAD, MASBATE CITY

SHEET CONTENTS:
BILL OF QUANTITIES

DRAFTED:
DATE: **JOHN PAUL M. AZARES**
PROJECT DEVELOPMENT OFFICER I
PREPARED:
DATE: **JULIUS ED A. ANCAJAS**
ENGINEER II

REVIEWED:
DATE: **RAUL B. DESUYO, JR.**
ENGINEER II

SUBMITTED:
DATE: **BONIFACIO A. TABIGUE**
CHIEF, MAINTENANCE SECTION

RECOMMENDED:
DATE: **MARIA ARRA PAZ G. SELLAR**
OIC-ASSISTANT DISTRICT ENGINEER

APPROVED:
DATE: **DENIS C. CAGOMOC**
DISTRICT ENGINEER

SET NO. **G** SHEET NO. **1**
1 4 34

NOTES

*BELOW ARE ONLY THE SCOPE OF WORK AND INCLUDED IN THE PROGRAM OF WORKS FOR EVERY PHASE.

	PHASE I	FOR SUCCEEDING FUNDING (PHASE III ONWARDS)
ARCHITECTURAL	- ROOF WORKS AT COVERED COURT AREA (METAL SHEETS, GUTTERS, FLASHING, RIDGEHIP ROLLS) - PAINTING WORKS (STEEL) FOR ANGLE BAR AND STEEL PURLINS - LIGHTING AT COVERED COURT AREA	
STRUCTURAL	- ROOF WORKS AT COVERED COURT AREA (METAL SHEETS, GUTTERS, FLASHING, RIDGEHIP ROLLS)	
ELECTRICAL	- WIRES AND WIRING AT COVERED COURT AND SLEEPING QUARTERS - LIGHTING FIXTURES AT COVERED COURT	
MECHANICAL	- 1 SET OF FIRE EXTINGUISHER - 1 UNIT OF AIR CONDITIONING AT SLEEPING QUARTER	
DATA / NETWORK		
PLUMBING	- PVC PIPE FOR DOWNSPOUT	



Republic of the Philippines
DEPARTMENT OF PUBLIC WORKS AND HIGHWAYS
MASBATE 2ND DISTRICT ENGINEERING OFFICE
City of Masbate, Masbate, Region V

PROJECT NAME AND LOCATION:
REPAIR / MAINTENANCE OF DPWH BUILDING
MASBATE 1 DISTRICT ENGINEERING OFFICE
MAIN REPAIR BASE SHOP
AIRPORT ROAD, MASBATE CITY

SHEET CONTENTS:

NOTES

DRAFTED:
DATE: **JOHN PAUL M. AZARES**
PROJECT DEVELOPMENT OFFICER I
PREPARED:
DATE: **JULIUS ED A. ANCAJAS**
ENGINEER II

 
 
REVIEWED:
DATE: **RAUL B. DESUYO, JR.**
ENGINEER II

SUBMITTED:
DATE: **BONIFACIO A. TABIGUE**
CHIEF, MAINTENANCE SECTION

RECOMMENDED:
DATE: **MARIA ARRA PAZ G. SELLAR**
OIC-ASSISTANT DISTRICT ENGINEER

APPROVED:
DATE: **DENIS C. CAGOMOC**
DISTRICT ENGINEER

SET NO.: **G**
2 4
SHEET NO.: **2**
34



 Republic of the Philippines DEPARTMENT OF PUBLIC WORKS AND HIGHWAYS MASBATE 2ND DISTRICT ENGINEERING OFFICE City of Masbate, Masbate, Region V	PROJECT NAME AND LOCATION:	SHEET CONTENTS:	DRAFTED: JOHN PAUL M. AZARES PROJECT DEVELOPMENT OFFICER I DATE: _____	REVIEWED:	SUBMITTED:	RECOMMENDED:	APPROVED:	SET NO.	SHEET NO.
	REPAIR / MAINTENANCE OF DRAIN BUILDING MASBATE 2ND DISTRICT ENGINEERING OFFICE MAIN REPAIR BASE SHOP, AIRPORT ROAD, MASBATE CITY	MATERIAL SOURCE / MAP DISPOSAL MAP	PREPARED: JULIUS ED A. ANCAJAS ENGINEER II DATE: _____	RAUL B. DESUYO, JR. ENGINEER II DATE: _____	BONIFACIO A. TABIGUE CHIEF, MAINTENANCE SECTION DATE: _____	MARIA ARRA PAZ G. SELLAR DIST. ASSISTANT DISTRICT ENGINEER DATE: _____	DENIS C. CAGOMOC DISTRICT ENGINEER DATE: _____	G 3 4	3 34

TABLE OF CONTENTS

DESCRIPTION	SET NO.	SHEET NO.
COVER PAGE		
GENERAL		
BILL OF QUANTITIES	G - 1	1
NOTES	G - 2	2
MATERIAL SOURCE MAP DISPOSAL MAP	G - 3	3
TABLE OF CONTENTS	G - 4	4
ARCHITECTURAL		
LOCATION MAP SITE DEVELOPMENT PLAN TECHNICAL DESCRIPTION PERSPECTIVE	A - 1	5
GROUND FLOOR PLAN	A - 2	6
SECOND FLOOR PLAN	A - 3	7
ROOF PLAN	A - 4	8
FRONT ELEVATION RIGHT ELEVATION	A - 5	9
REAR ELEVATION LEFT ELEVATION	A - 6	10
CROSS SECTION THRU "X" LONGITUDINAL SECTION THRU "Y"	A - 7	11
SCHEDULE OF DOORS AND WINDOWS	A - 8	12
GROUND FLOOR REFLECTED CEILING PLAN	A - 9	13
SECOND FLOOR REFLECTED CEILING PLAN	A - 10	14
CEILING ISOMETRIC DETAIL CEILING SECTION DETAIL CEILING SPOT DETAIL	A - 11	15

DESCRIPTION	SET NO.	SHEET NO.
COLLEGE SIZE BASKETBALL COURT BLOW UP PLAN	A - 12	16
BASKETBALL COURT SECTION DETAIL THRU "A" BASKETBALL COURT FRONT ELEVATION BASKETBALL COURT SIDE ELEVATION BASKETBALL RING BACK BOARD SPOT DETAIL	A - 13	17
ELECTRICAL		
LOCATION MAP SITE DEVELOPMENT PLAN TECHNICAL DESCRIPTION GENERAL NOTES LEGENDS AND SYMBOLS	E - 1	18
RISER DIAGRAM	E - 2	19
SCHEDULE OF LOADS	E - 3	20
GROUND FLOOR LIGHTING LAYOUT	E - 4	21
SECOND FLOOR LIGHTING LAYOUT	E - 5 ²³	22
SECOND FLOOR POWER LAYOUT	E - 6	
MECHANICAL		
GENERAL NOTES LOCATION MAP SITE DEVELOPMENT PLAN LEGENDS AND SYMBOLS PIPE SLEEVE DETAIL TWO-WAY BRACE PIPE HANGER DETAIL ACU ELECTRICAL INSTALLATION DETAIL	M - 1	24

DESCRIPTION	SET NO.	SHEET NO.
GROUND FLOOR AIR CONDITIONING LAYOUT	M - 2	25
ELECTRONICS		
LOCATION MAP SITE DEVELOPMENT PLAN TECHNICAL DESCRIPTION GENERAL NOTES LEGENDS AND SYMBOLS CONDUIT FILL CHART	ECE - 1	26
SMOKE DETECTOR CEILING MOUNTING DETAIL HEAT DETECTOR CEILING MOUNTING DETAIL FIRE DETECTION AND ALARM SYSTEM CEILING MOUNTING DETAIL FIRE DETECTION AND ALARM SYSTEM MOUNTING HEIGHT DETAIL	ECE - 2	27
GROUND FLOOR FIRE ALARM SYSTEM LAYOUT	ECE - 3	28
PLUMBING		
LOCATION MAP SITE DEVELOPMENT PLAN TECHNICAL DESCRIPTION GENERAL NOTES LEGENDS AND SYMBOLS	P - 1	29
MISCELLANEOUS PLUMBING DRAWINGS	P - 2	30
SECOND FLOOR PLUMBING LAYOUT	P - 3	31
PLUMBING ISOMETRIC LAYOUT	P - 4 ³³	32
SECOND FLOOR SANITARY LAYOUT	P - 5	
SANITARY ISOMETRIC LAYOUT	P - 6	34



Republic of the Philippines
DEPARTMENT OF PUBLIC WORKS AND HIGHWAYS
MASBATE 2ND DISTRICT ENGINEERING OFFICE
City of Masbate, Masbate, Region V

PROJECT NAME AND LOCATION
REPAIR / MAINTENANCE OF BRAN BUILDING
MASBATE 1 DISTRICT ENGINEERING OFFICE
MAIN REPAIR BASE SHOP,
AIRPORT ROAD, MASBATE CITY

SHEET CONTENTS
TABLE OF CONTENTS

DRAFTED:
JOHN PAUL M. AZARES
PROJECT DEVELOPMENT OFFICER I
DATE:
PREPARED:
JULIUS ED A. ANCAJAS
ENGINEER I
DATE:

REVIEWED:
RAUL B. DESUYO, JR.
ENGINEER II
DATE:

SUBMITTED:
BONIFACIO A. TABIGUE
CHIEF, MAINTENANCE SECTION
DATE:


RECOMMENDED:
MARIA ARRA PAZ G. SELLAR
DIC-ASSISTANT DISTRICT ENGINEER
DATE:

APPROVED:
DENIS C. CAGOMOC
DISTRICT ENGINEER
DATE:

SET NO.	SHEET NO.
G 4	4 34



LOCATION MAP
NOT TO SCALE

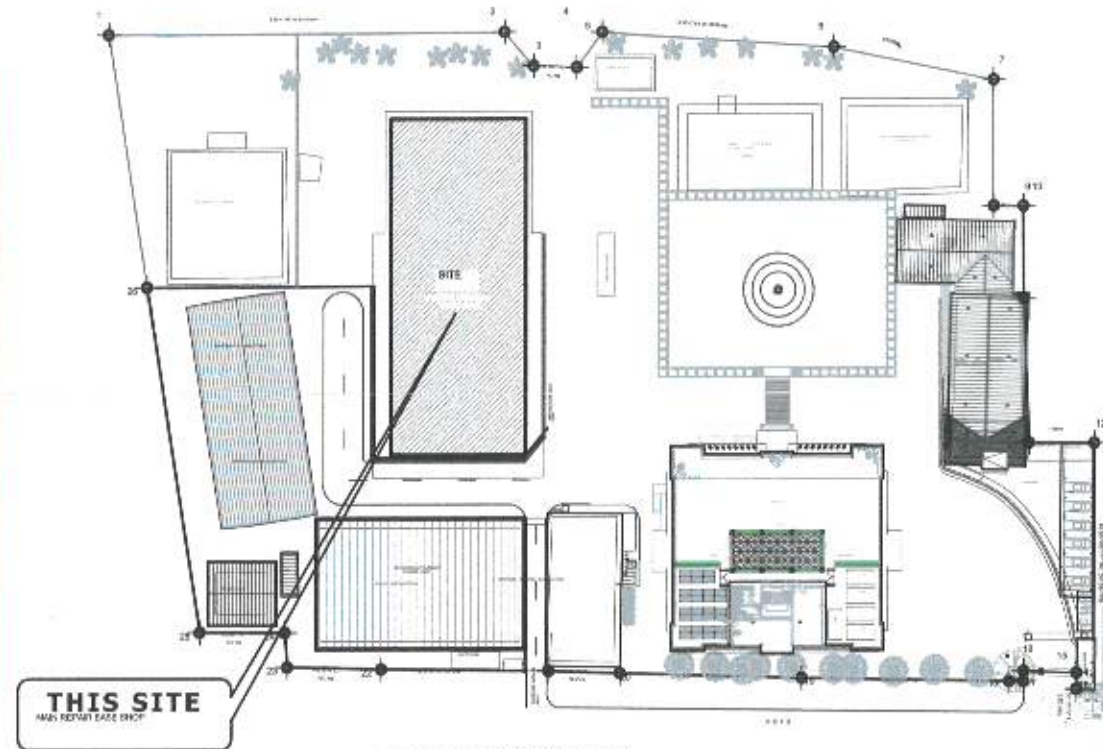

SITE DEVELOPMENT PLAN
NOT TO SCALE

TECHNICAL DESCRIPTION:

NO.	AZIMUTH	DISTANCE
1-2	315° 00' 00"	10.00
2-3	315° 00' 00"	10.00
3-4	315° 00' 00"	10.00
4-5	315° 00' 00"	10.00
5-6	315° 00' 00"	10.00
6-7	315° 00' 00"	10.00
7-8	315° 00' 00"	10.00
8-9	315° 00' 00"	10.00
9-10	315° 00' 00"	10.00
10-11	315° 00' 00"	10.00
11-12	315° 00' 00"	10.00
12-13	315° 00' 00"	10.00
13-14	315° 00' 00"	10.00
14-15	315° 00' 00"	10.00
15-16	315° 00' 00"	10.00
16-17	315° 00' 00"	10.00
17-18	315° 00' 00"	10.00
18-19	315° 00' 00"	10.00
19-20	315° 00' 00"	10.00
20-21	315° 00' 00"	10.00
21-22	315° 00' 00"	10.00
22-23	315° 00' 00"	10.00
23-24	315° 00' 00"	10.00
24-25	315° 00' 00"	10.00
25-26	315° 00' 00"	10.00
26-27	315° 00' 00"	10.00
27-28	315° 00' 00"	10.00
28-29	315° 00' 00"	10.00
29-30	315° 00' 00"	10.00
30-31	315° 00' 00"	10.00
31-32	315° 00' 00"	10.00



PERSPECTIVE
NOT TO SCALE



Republic of the Philippines
DEPARTMENT OF PUBLIC WORKS AND HIGHWAYS
MASBATE 2ND DISTRICT ENGINEERING OFFICE
City of Masbate, Masbate, Region V

PROJECT NAME AND LOCATION:
REPAIR / MAINTENANCE OF DWH BUILDING
MASBATE II DISTRICT ENGINEERING OFFICE
MAIN REPAIR BASE SHOP,
AIRPORT ROAD, MASBATE CITY

SHEET CONTENTS:
LOCATION MAP
SITE DEVELOPMENT PLAN
TECHNICAL DESCRIPTION
PERSPECTIVE

DRAFTED:
JOHN PAUL M. AZARES
PROJECT DEVELOPMENT OFFICER I
DATE: _____
PREPARED:
JULIUS ED A. ANCAJAS
ENGINEER I
DATE: _____

REVIEWED:
RAUL B. DESUYO, JR.
ENGINEER II
DATE: _____

SUBMITTED:
BONIFACIO A. TABIGUE
CHIEF, MAINTENANCE SECTION
DATE: _____

RECOMMENDED:
MARIA ARRA PAZ G. SELLAR
CIC-ASSISTANT DISTRICT ENGINEER
DATE: _____

APPROVED:
DENIS C. CAGOMOC
DISTRICT ENGINEER
DATE: _____

SET NO.

A

1 13


SHEET NO.

5

34

NOTE :

ALL ARCHITECTURAL, STRUCTURAL, ELECTRICAL, AND PLUMBING WORKS OF WAREHOUSE AREA ARE NOT INCLUDED IN THE PROGRAM OF WORKS.

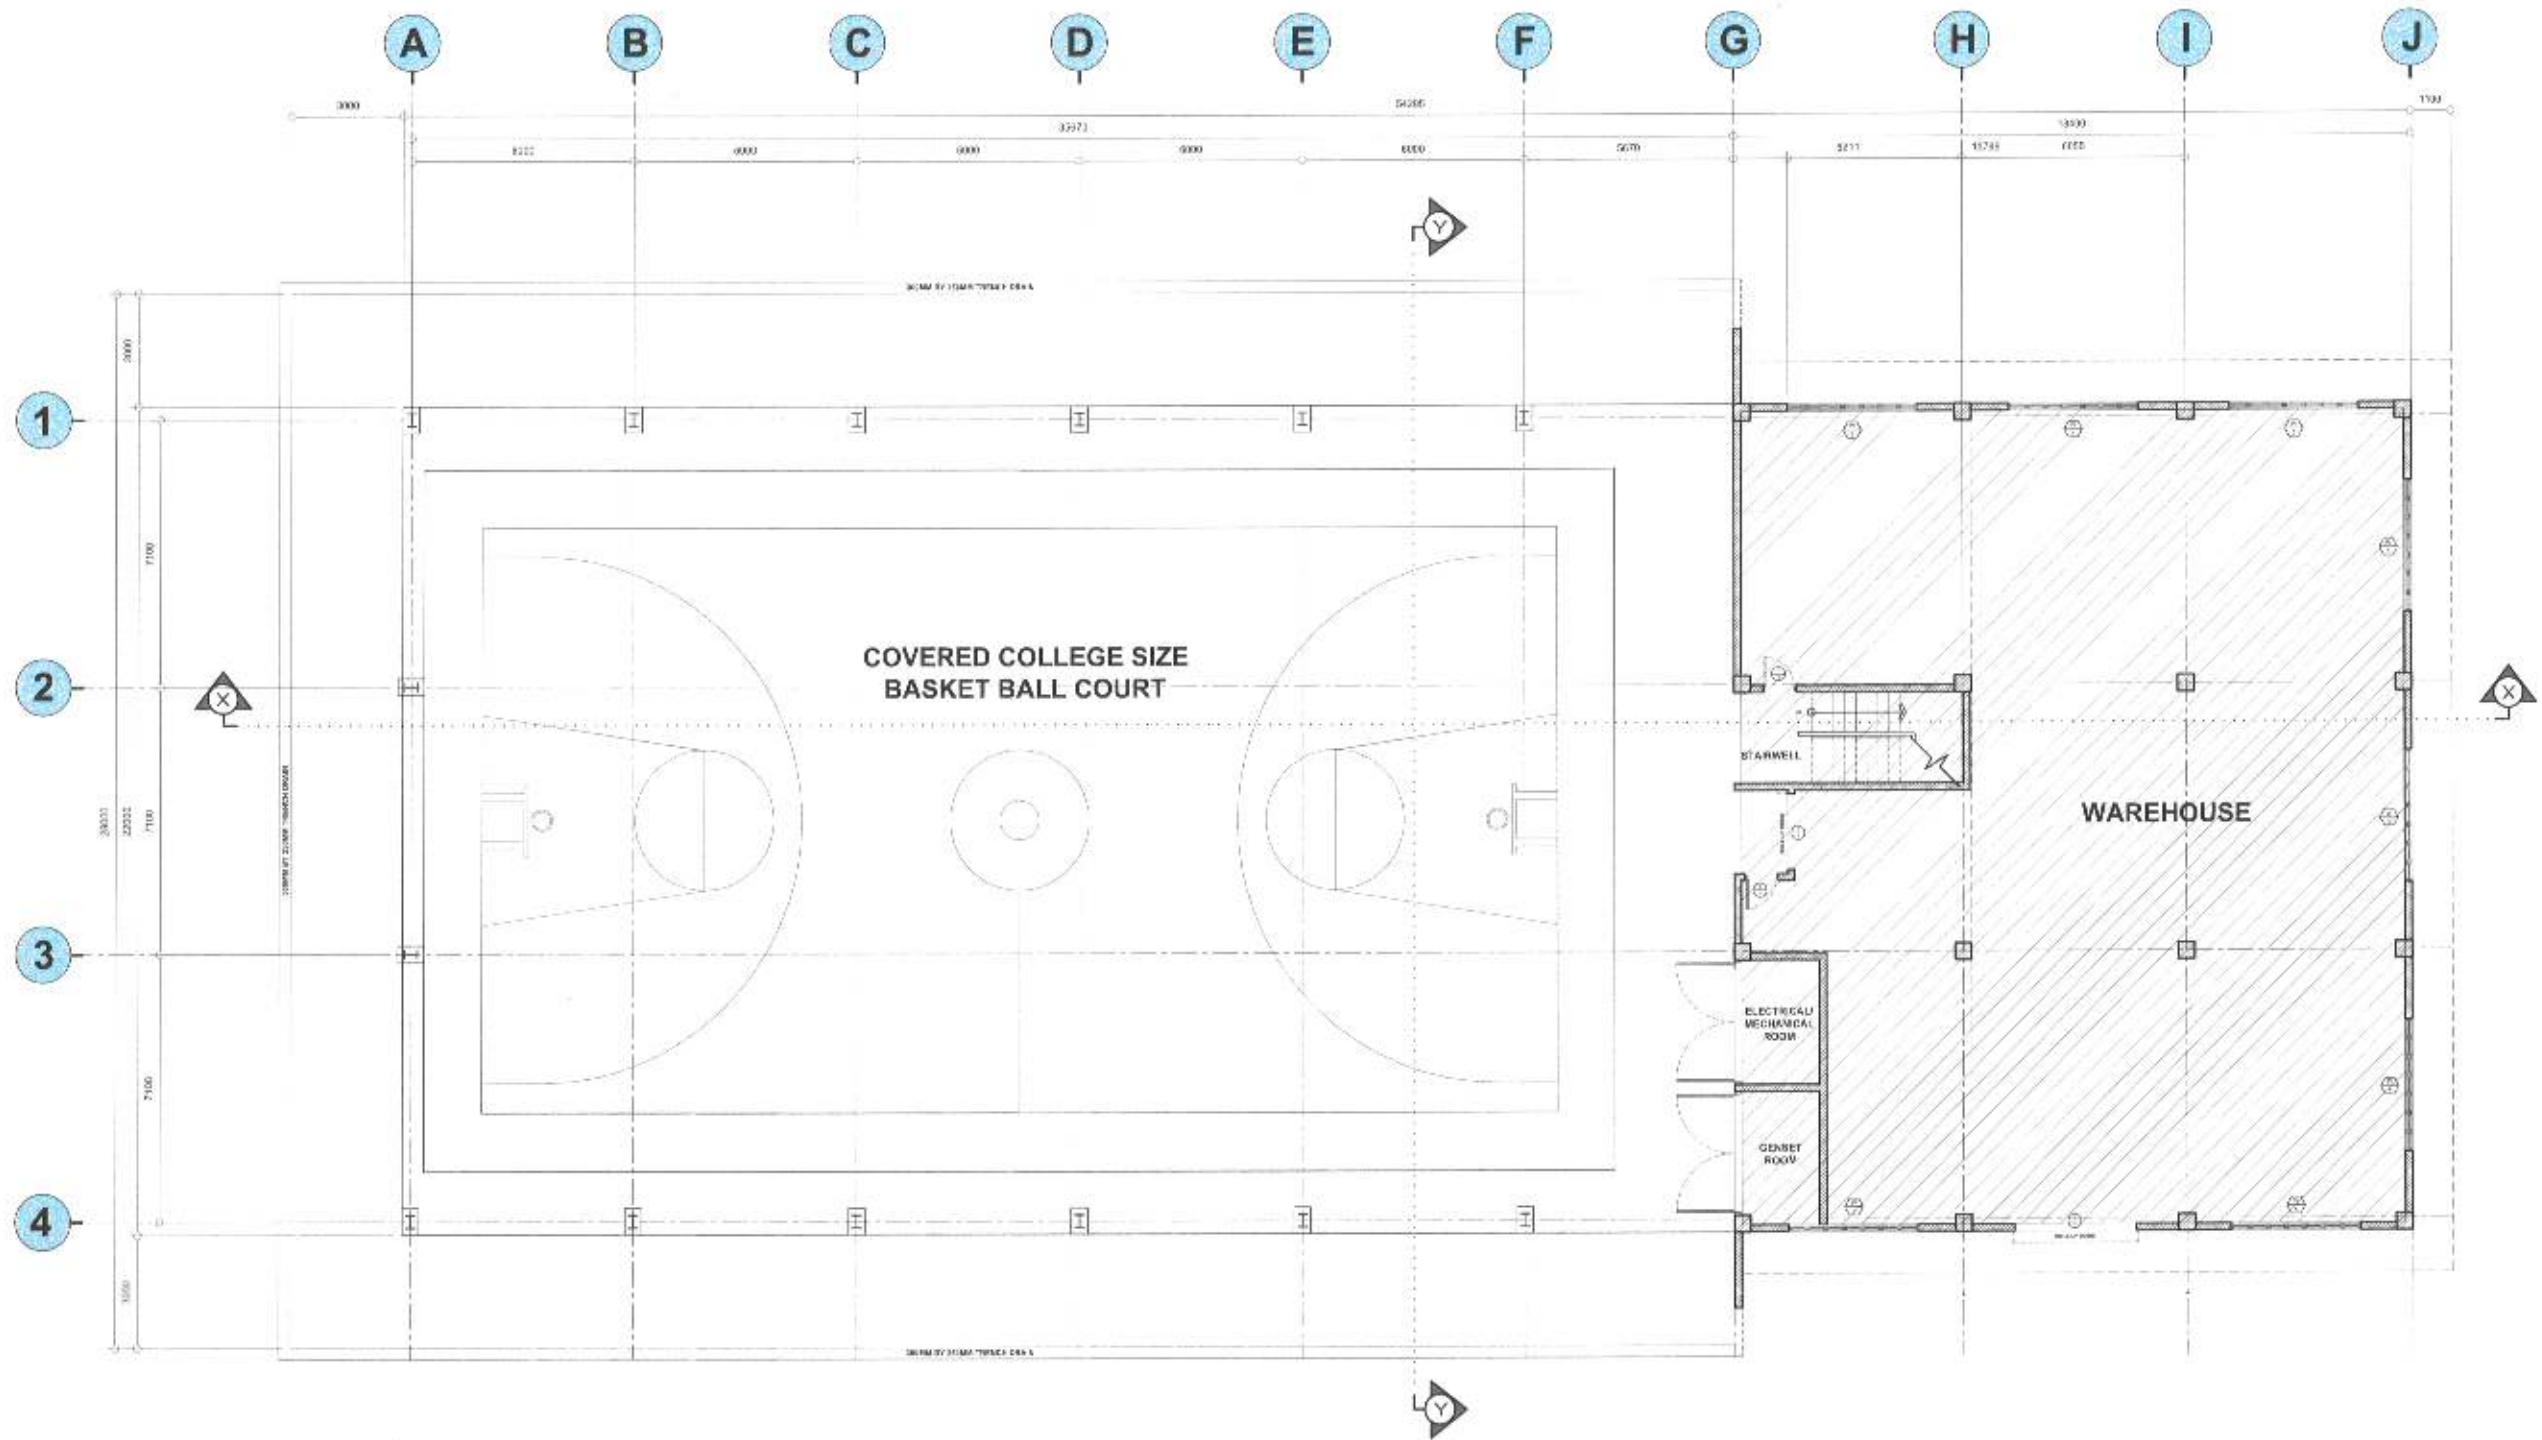


1
A 2 **GROUND FLOOR PLAN**
SCALE 1:110 MTS.

 Republic of the Philippines DEPARTMENT OF PUBLIC WORKS AND HIGHWAYS MASBATE 2ND DISTRICT ENGINEERING OFFICE City of Masbate, Masbate, Region V	PROJECT NAME AND LOCATION: REPAIR/MAINTENANCE OF DPMH BUILDING MASBATE 108TH DISTRICT ENGINEERING OFFICE MAIN REPAIR BASE SHOP AIRPORT ROAD, MASBATE CITY	SHEET CONTENTS: GROUND FLOOR PLAN	DRAFTED: DATE: JOHN PAUL M. AZARES PROJECT DEVELOPMENT OFFICER I PREPARED: DATE: JULIUS ED A. ANCAJAS ENGINEER II	REVIEWED: DATE: RAUL B. DESUYO, JR. ENGINEER II	SUBMITTED: DATE: BONIFACIO A. TABIGUE CHIEF, MAINTENANCE SECTION	RECOMMENDED: DATE: MARIA ARRA PAZ G. SELLAR AID-ASSISTANT DISTRICT ENGINEER	APPROVED: DATE: DENIS C. CAGOMOC DISTRICT ENGINEER	SET NO. A 2 13	SHEET NO. 6 34
---	---	--	--	--	---	--	---	-----------------------------	-----------------------------

NOTE :

ALL ARCHITECTURAL, STRUCTURAL, ELECTRICAL, AND PLUMBING WORKS OF WAREHOUSE AREA ARE NOT INCLUDED IN THE PROGRAM OF WORKS.

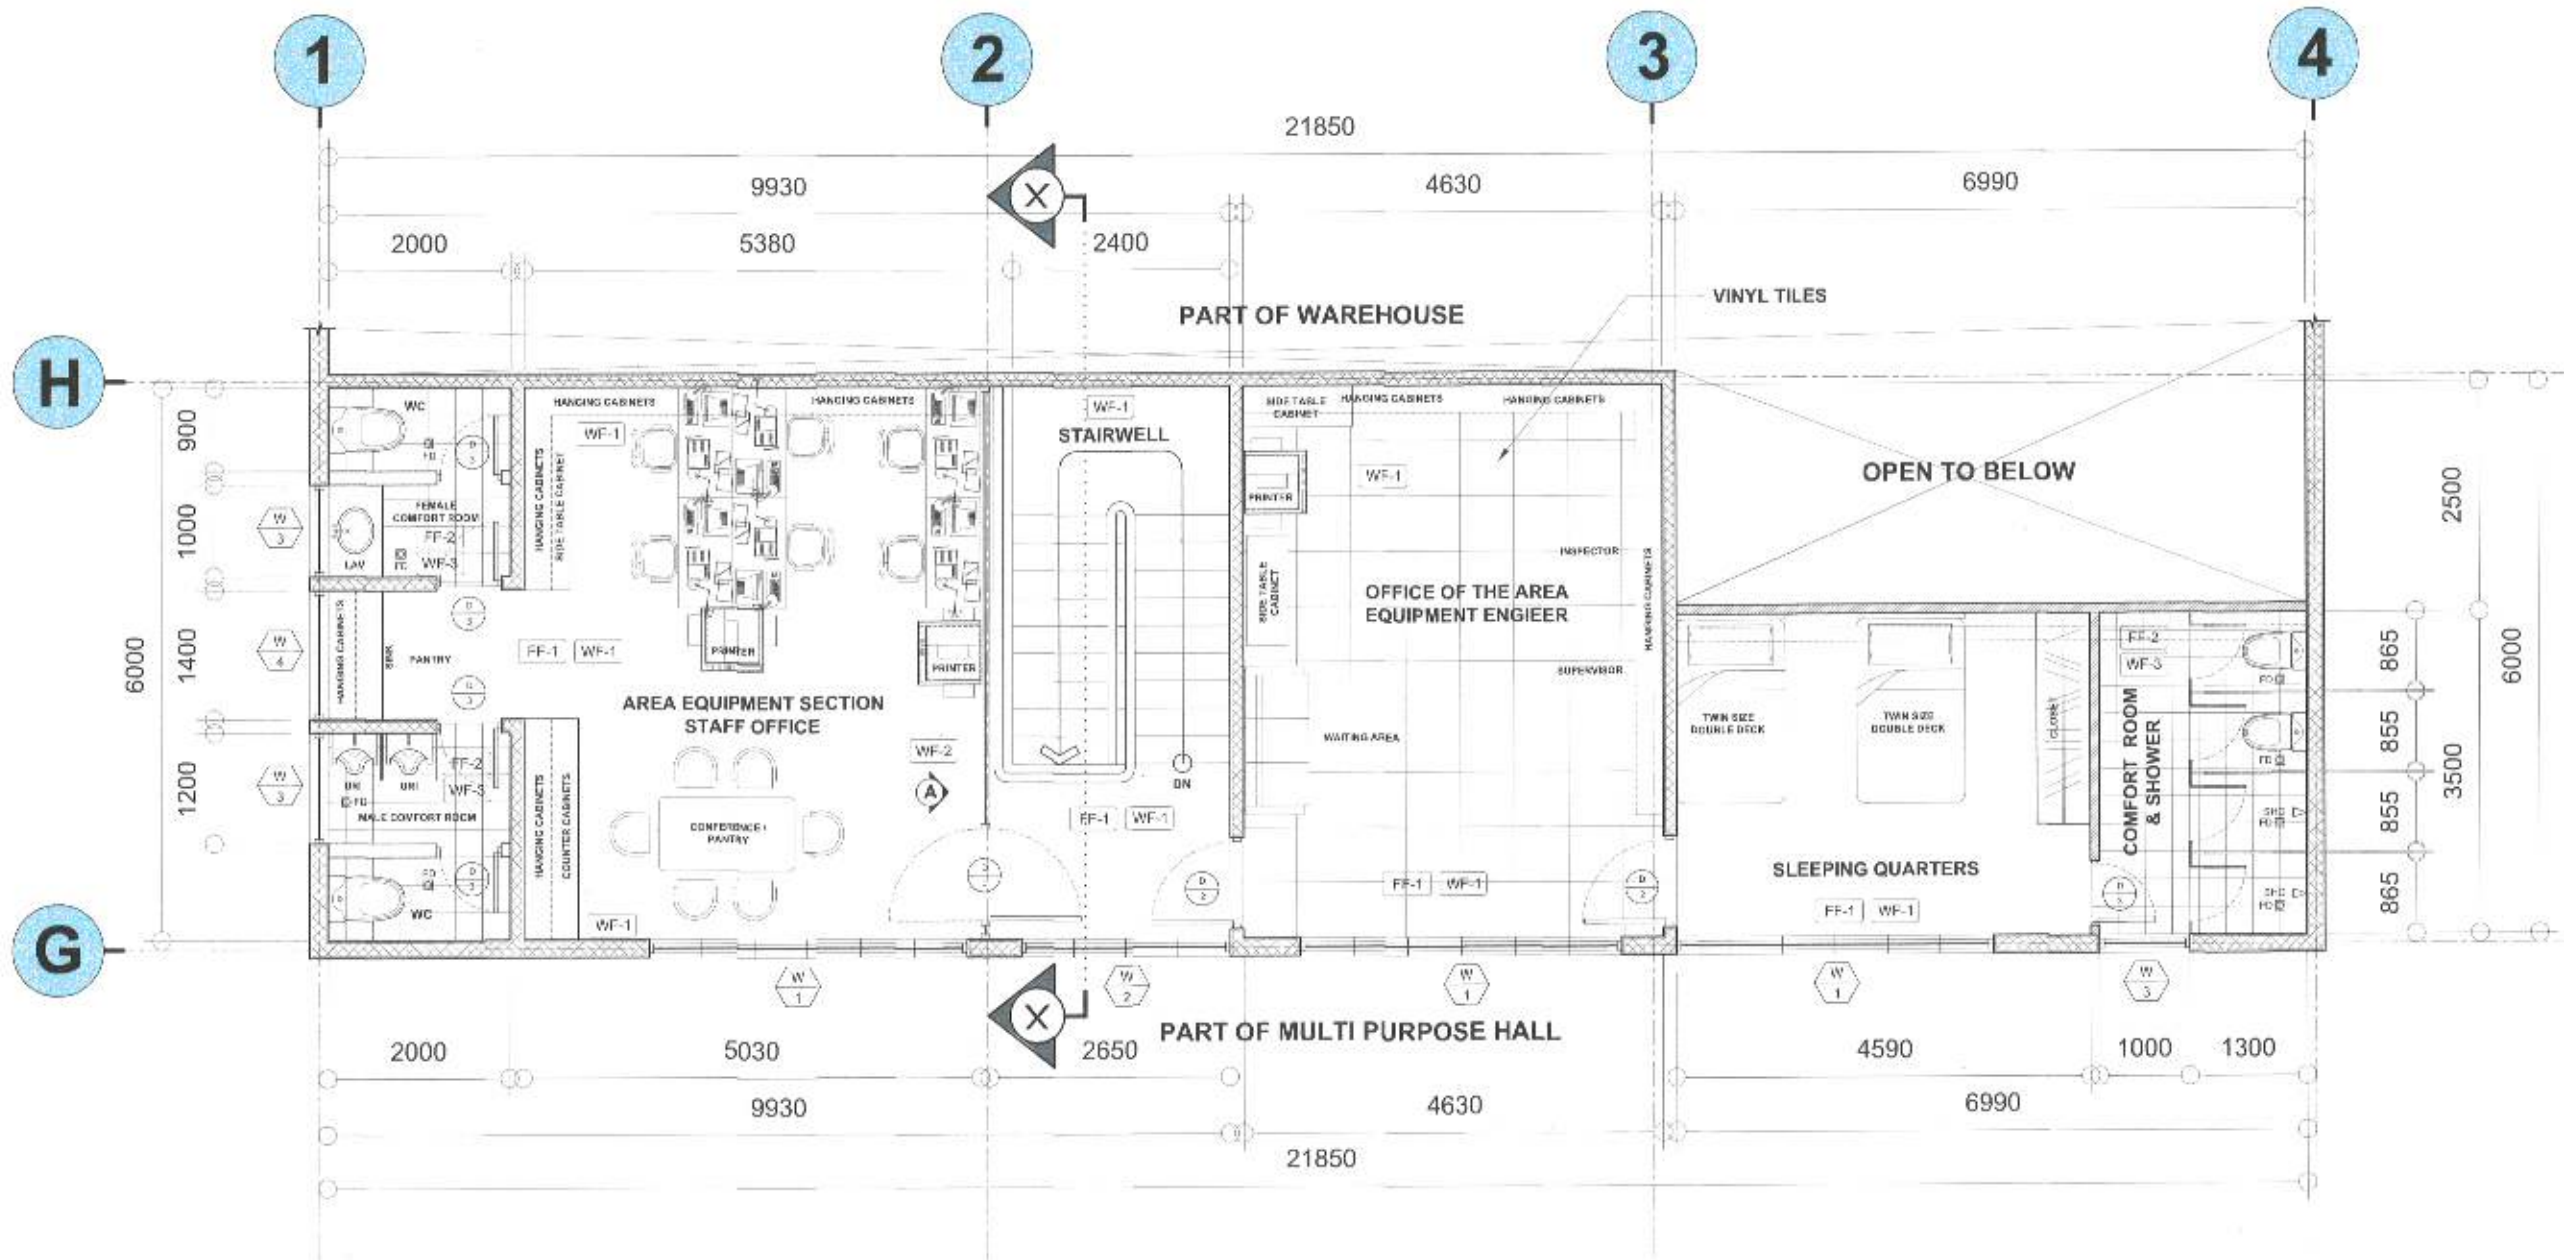


1 SECOND FLOOR PLAN (WAREHOUSE AREA)
SCALE 1:45 MTS.

 Republic of the Philippines DEPARTMENT OF PUBLIC WORKS AND HIGHWAYS MASBATE 2ND DISTRICT ENGINEERING OFFICE City of Masbate, Masbate, Region V	PROJECT NAME AND LOCATION:	SHEET CONTENTS	DRAFTED: DATE: JOHN PAUL M. AZARES PROJECT DEVELOPMENT OFFICER I	REVIEWED: DATE: RAUL B. DESUYO, JR. ENGINEER I	SUBMITTED: DATE: BONIFACIO A. TABIGUE CHIEF, MAINTENANCE SECTION	RECOMMENDED: DATE: MARIA ARRA PAZ G. SELLAR CIC-ASSISTANT DISTRICT ENGINEER	APPROVED: DATE: DENIS C. CAGOMOC DISTRICT ENGINEER	SFT NO. A 3 / 13	SHEET NO. 7 34
	REPAIR & MAINTENANCE OF DWH BUILDING MASBATE II DISTRICT ENGINEERING OFFICE MAIN REPAIR BASE SHOP, AIRPORT ROAD, MASBATE CITY	SECOND FLOOR PLAN		PREPARED: DATE: JULIUS ED A. ANCAJAS ENGINEER I					


NOTE :

ONLY THE RIGHT SIDE OF THE ROOFING ARE INCLUDED IN THE PROGRAM

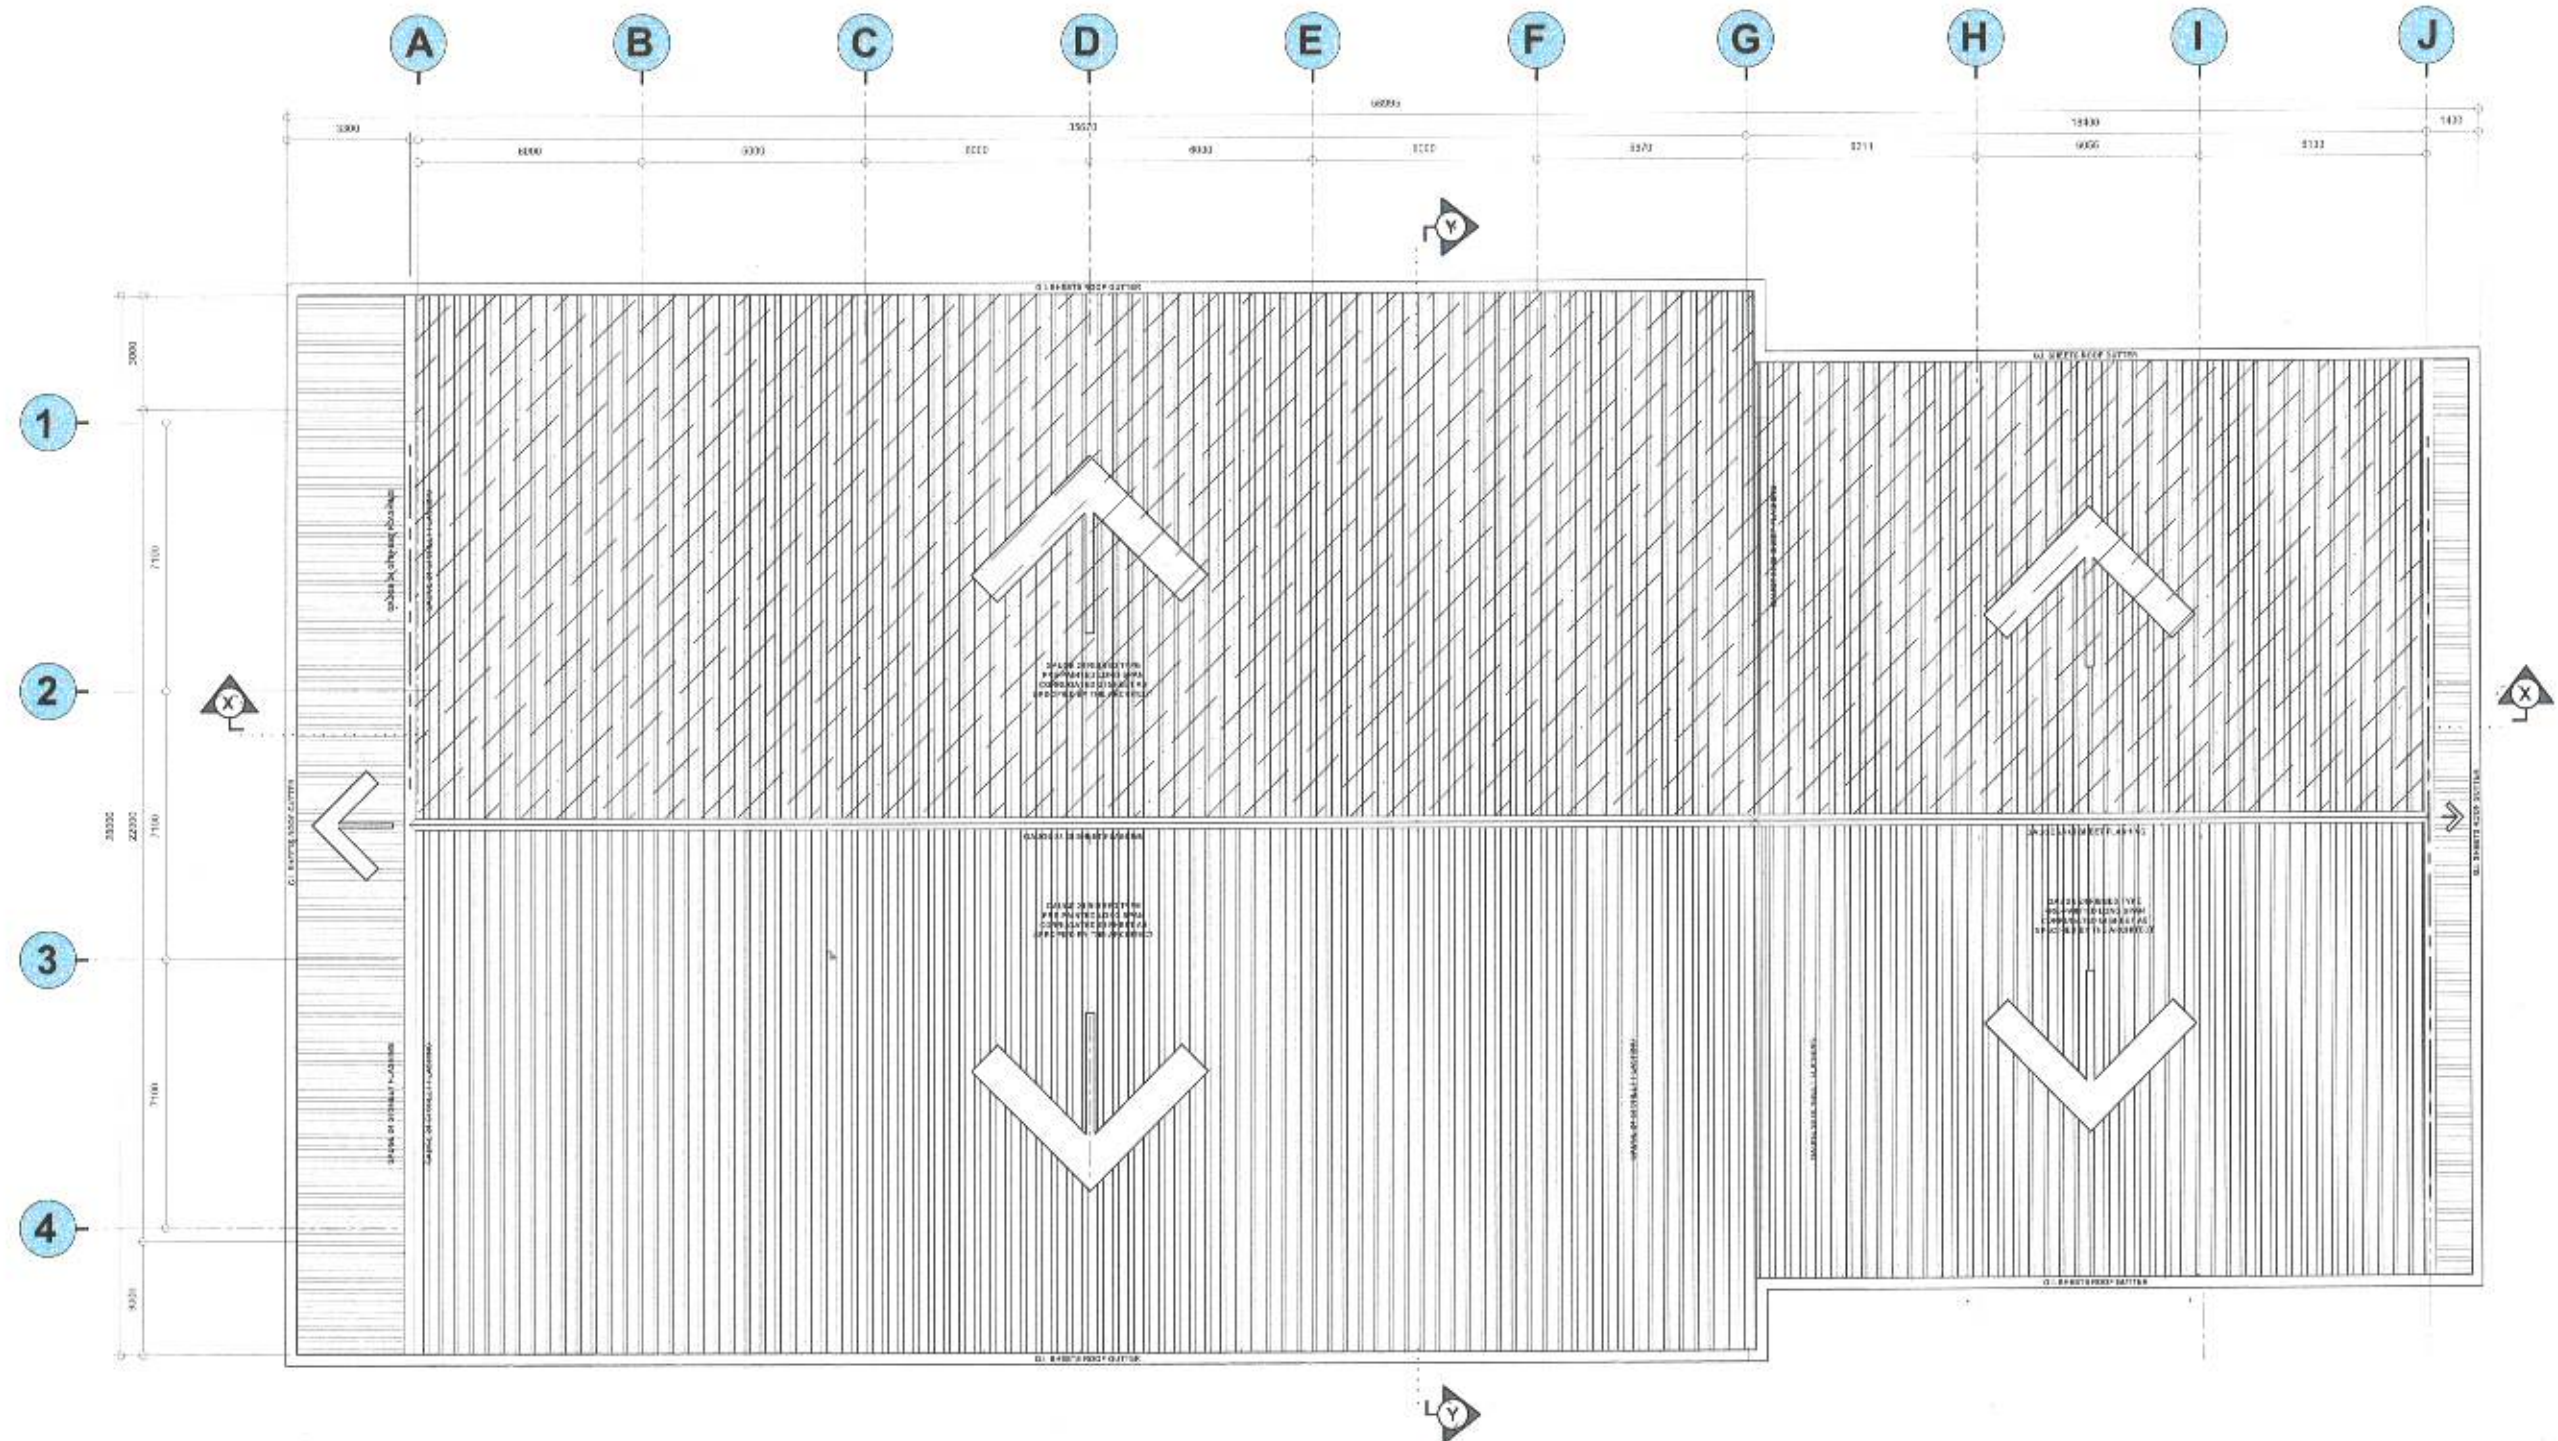


1 ROOF PLAN
 SCALE 1:110 MTS.
 RAUL B. DESUYO, JR.

 Republic of the Philippines DEPARTMENT OF PUBLIC WORKS AND HIGHWAYS MASBATE 2ND DISTRICT ENGINEERING OFFICE City of Masbate, Masbate, Region V	PROJECT NAME AND LOCATION: REPAIR / WAREHOUSE OF DPWH BUILDING MASBATE 2 DISTRICT ENGINEERING OFFICE MAIN REPAIR BASE SHOP AIRPORT ROAD, MASBATE CITY	SHEET CONTENTS: ROOF PLAN	DRAFTED: JOHN PAUL M. AZARES PROJECT DEVELOPMENT OFFICER I DATE: PREPARED: JULIUS ED A. ANCAJAS ENGINEER I DATE:	REVIEWED: RAUL B. DESUYO, JR. ENGINEER II DATE:	SUBMITTED: BONIFACIO A. TABIGUE CHIEF, MAINTENANCE SECTION DATE:	RECOMMENDED: MARIA ARRA PAZ G. SELLAR CIC-ASSISTANT DISTRICT ENGINEER DATE:	APPROVED: DENIS C. CAGOMOC DISTRICT ENGINEER DATE:	SET NO. A 4 13	SHEET NO. B 34
---	---	----------------------------------	---	--	---	--	---	--------------------------	--------------------------


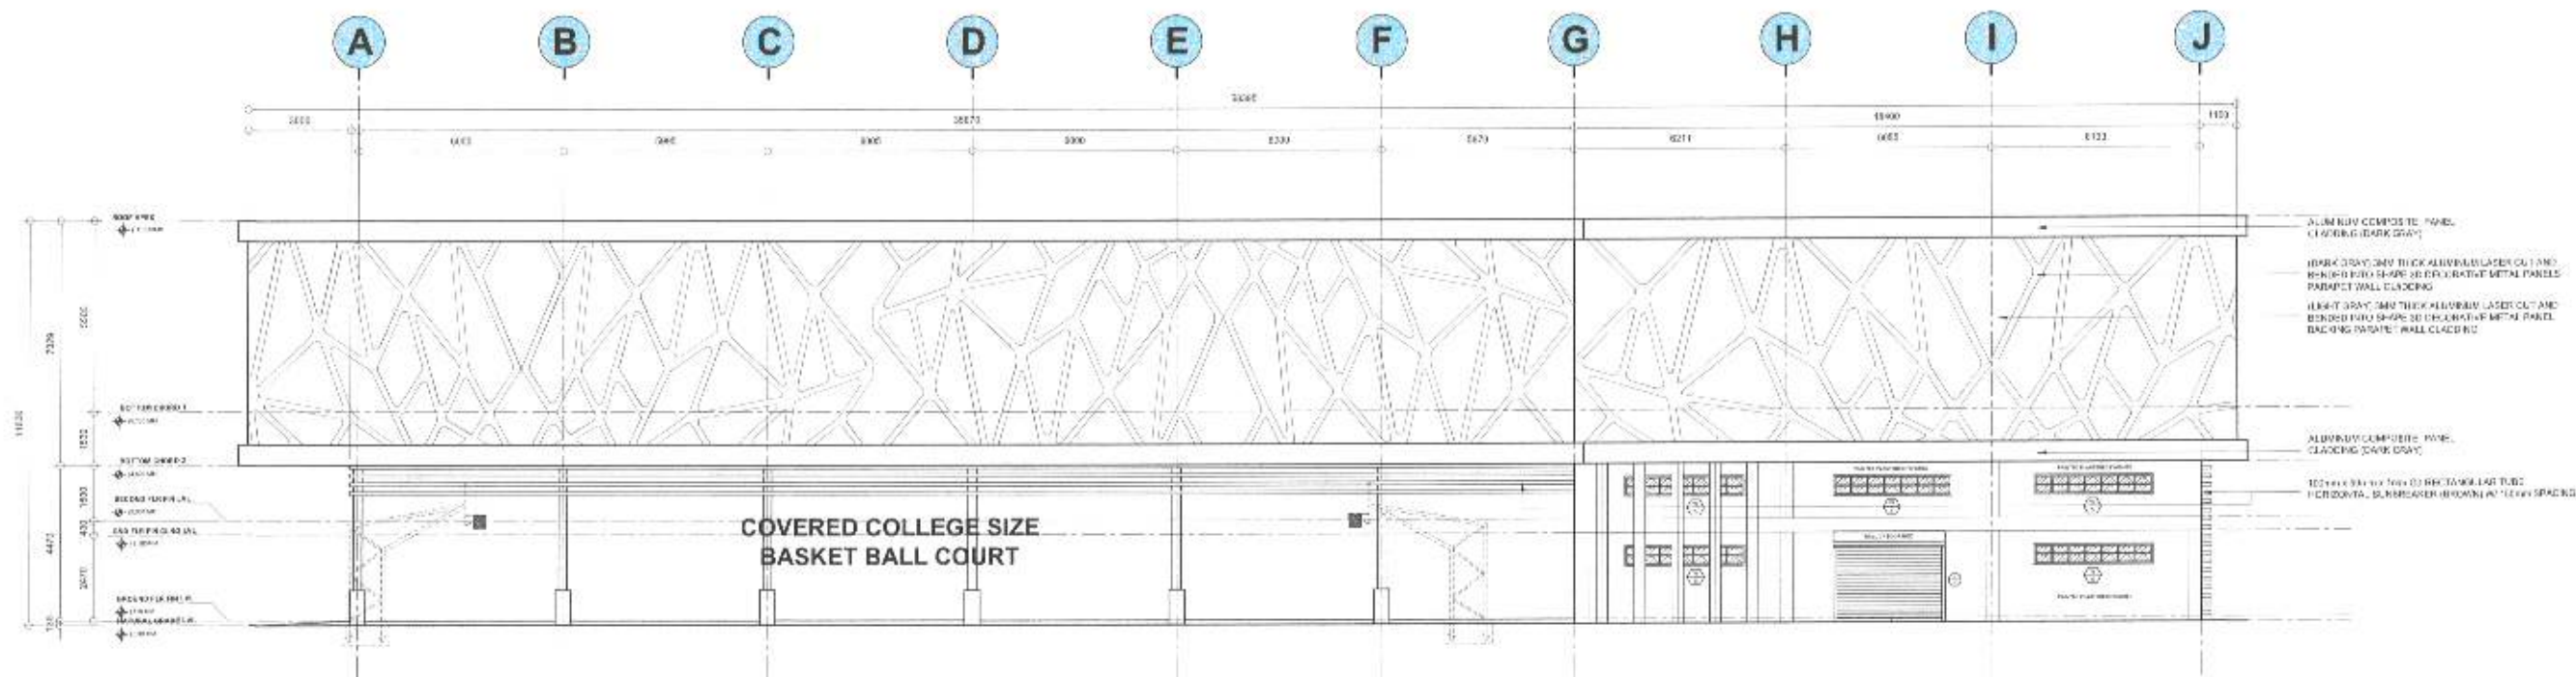


NOTE :


- ONLY THE ROOFING SHEETS, GUTTERS, FLASHING, RIDGE/HIP ROLLS AND PAINTING WORKS (STEEL) AT COVERED COURT AREA AND ROOL-UP DOOR ARE INCLUDED IN THE PROGRAM OF WORKS. THE REST ARE NOT INCLUDED.

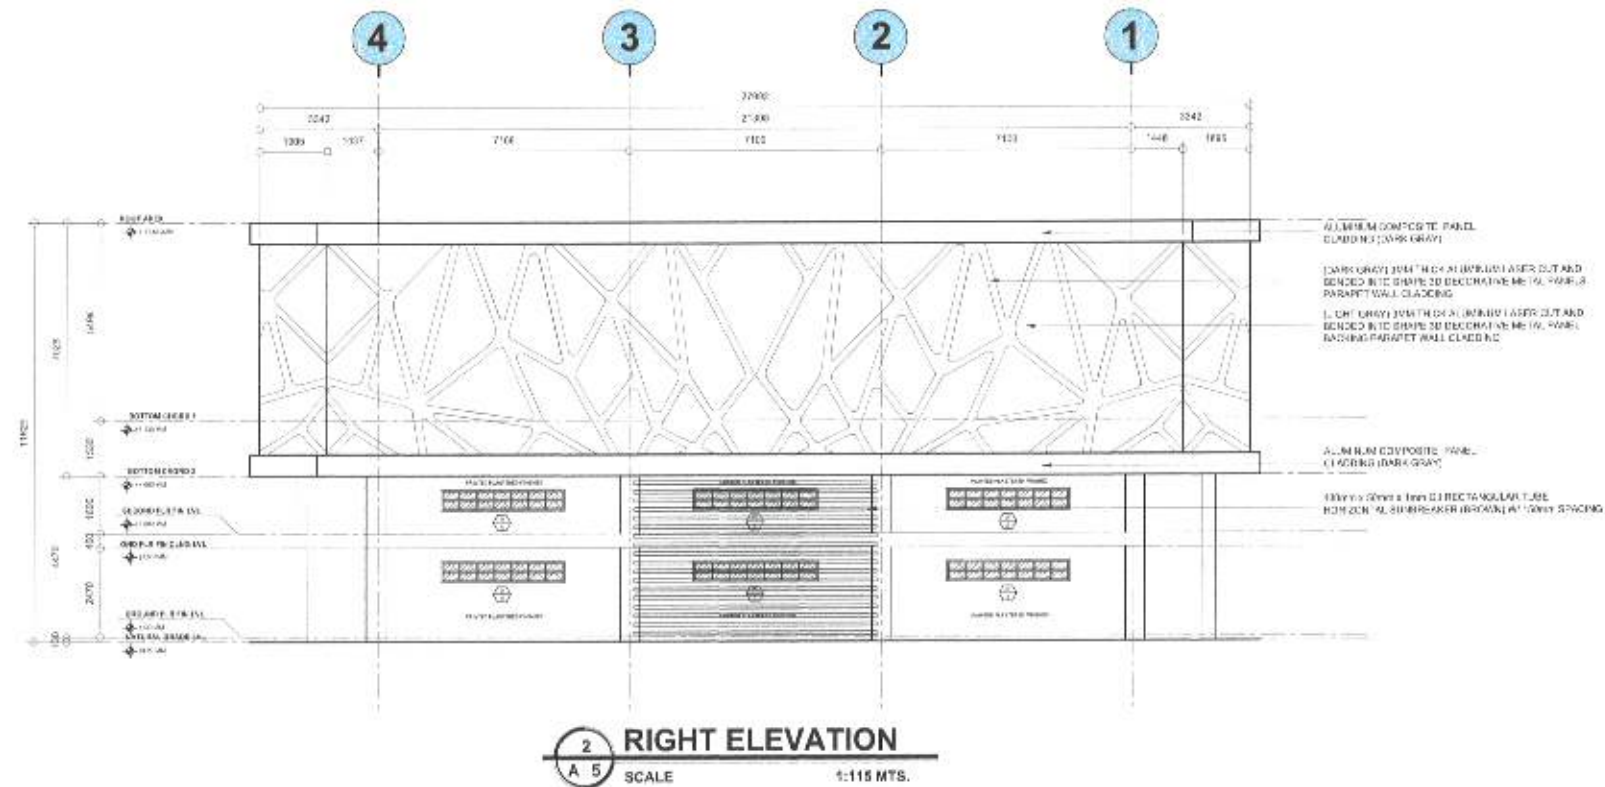

PROJECT NAME AND LOCATION:	SHEET CONTENTS:	DRAFTED:	REVIEWED:	SUBMITTED:	RECOMMENDED:	APPROVED:	SET NO.	SHEET NO.
 Republic of the Philippines DEPARTMENT OF PUBLIC WORKS AND HIGHWAYS MASBATE 2ND DISTRICT ENGINEERING OFFICE City of Masbate, Masbate, Region V	REPAIR / MAINTENANCE OF 30'x40' BUILDING MASBATE 1 DISTRICT ENGINEERING OFFICE MAIN REPAIR BASE SHOP AIRPORT ROAD, MASBATE CITY FRONT ELEVATION RIGHT ELEVATION	DRAFTED: JOHN PAUL M. AZARES PROJECT DEVELOPMENT OFFICER I DATE: _____ PREPARED: JULIUS ED A. ANCAJAS ENGINEER II DATE: _____	REVIEWED: RAUL B. DESUYO, JR. ENGINEER II DATE: _____	SUBMITTED: BONIFACIO A. TABIGUE CHIEF, MAINTENANCE SECTION DATE: _____	RECOMMENDED: MARIA ARRA PAZ G. SELLAR O/C-ASSISTANT DISTRICT ENGINEER DATE: _____	APPROVED: DENIS C. CAGOMOC DISTRICT ENGINEER DATE: _____	5 13	9 34

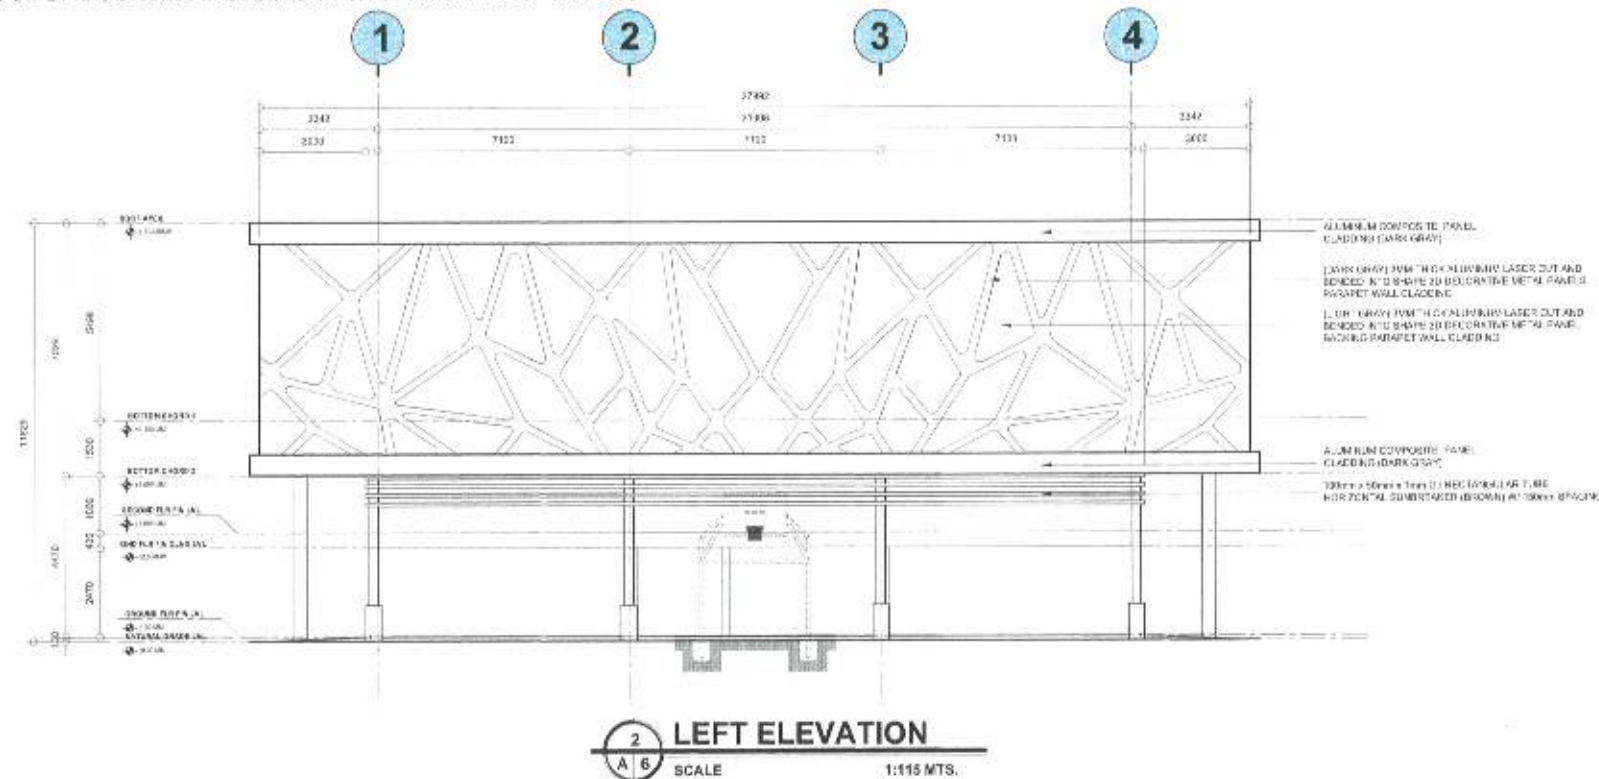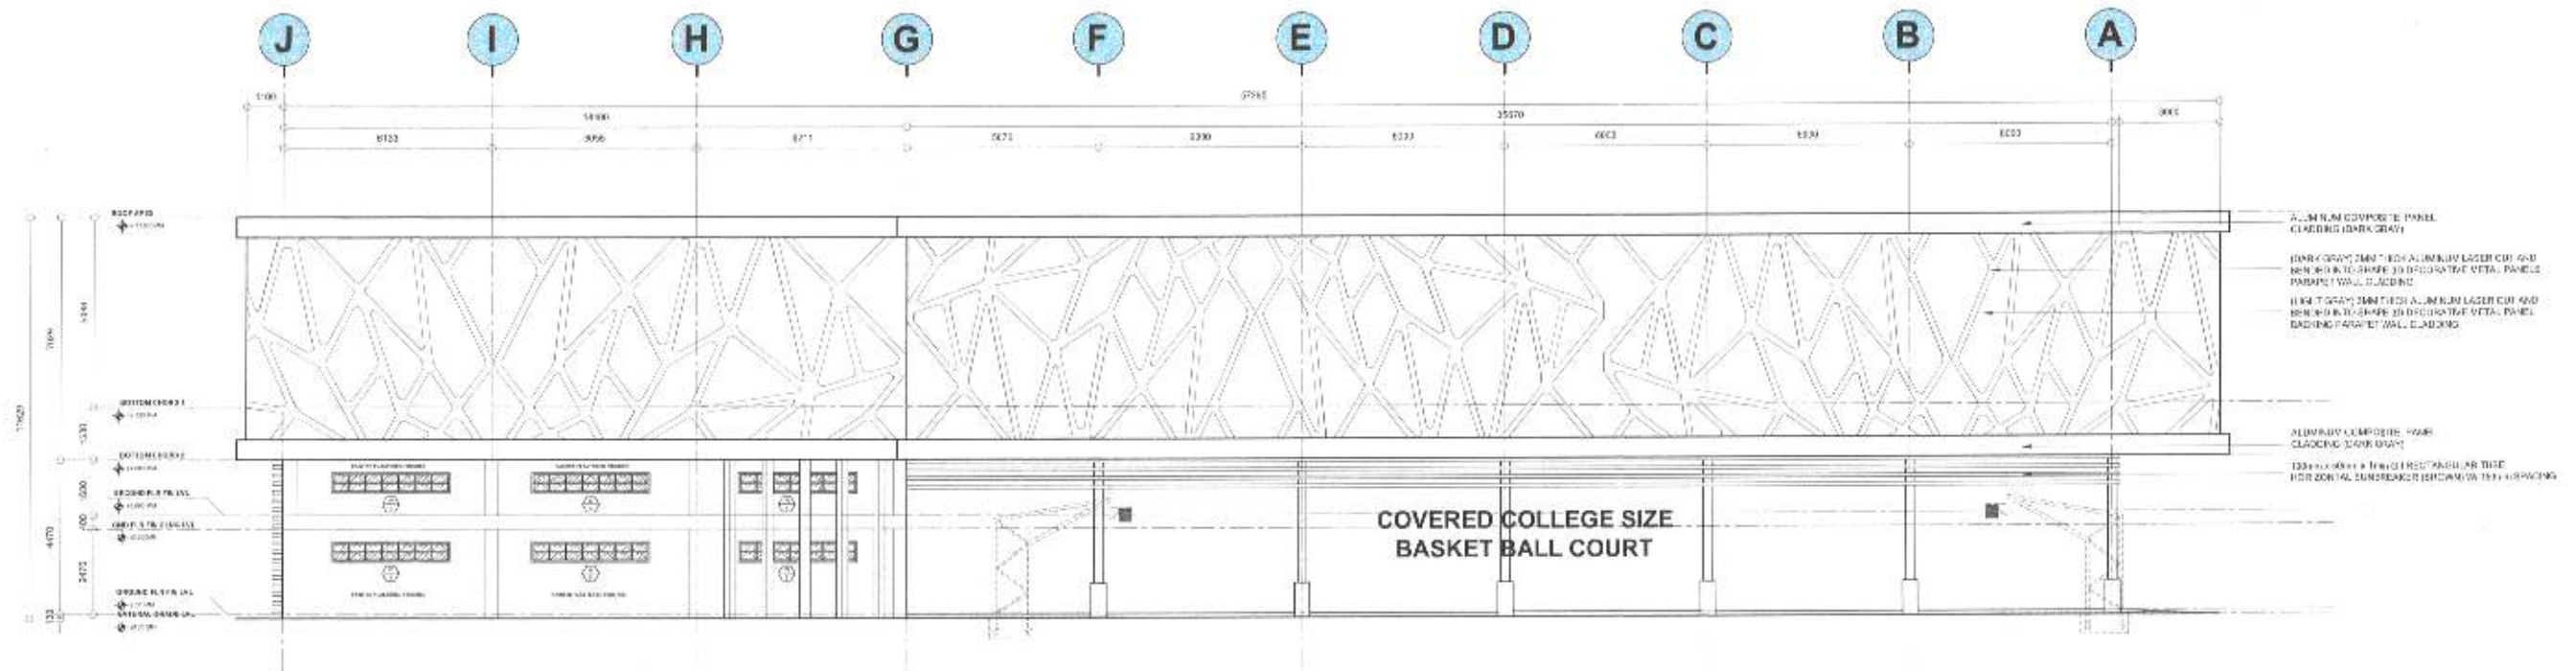

PROJECT NAME AND LOCATION	SHEET CONTENTS	DRAFTED:	REVIEWED:	SUBMITTED:	RECOMMENDED:	APPROVED:	SET NO.	SHEET NO.
 Republic of the Philippines DEPARTMENT OF PUBLIC WORKS AND HIGHWAYS MASBATE 2ND DISTRICT ENGINEERING OFFICE City of Masbate, Masbate, Region V	REPAIR - MAINTENANCE OF DPM BUILDING MASBATE 1 DISTRICT ENGINEERING OFFICE MAIN REPAIR BASE SHOP, AIRPORT ROAD, MASBATE CITY REAR ELEVATION LEFT ELEVATION	DRAFTED: JOHN PAUL M. AZARES PROJECT DEVELOPMENT OFFICER DATE: PREPARED: JULIUS ED A. ANCAJAS ENGINEER I DATE:	REVIEWED: RAUL B. DESUYO, JR. ENGINEER II DATE:	SUBMITTED: BONIFACIO A. TABIGUE CHIEF, MAINTENANCE SECTION DATE:	RECOMMENDED: MARIA ARRA PAZ G. SELLAR DID-ASSISTANT DISTRICT ENGINEER DATE:	APPROVED: DENIS C. CAGOMOC DISTRICT ENGINEER DATE:	6 13	10 34

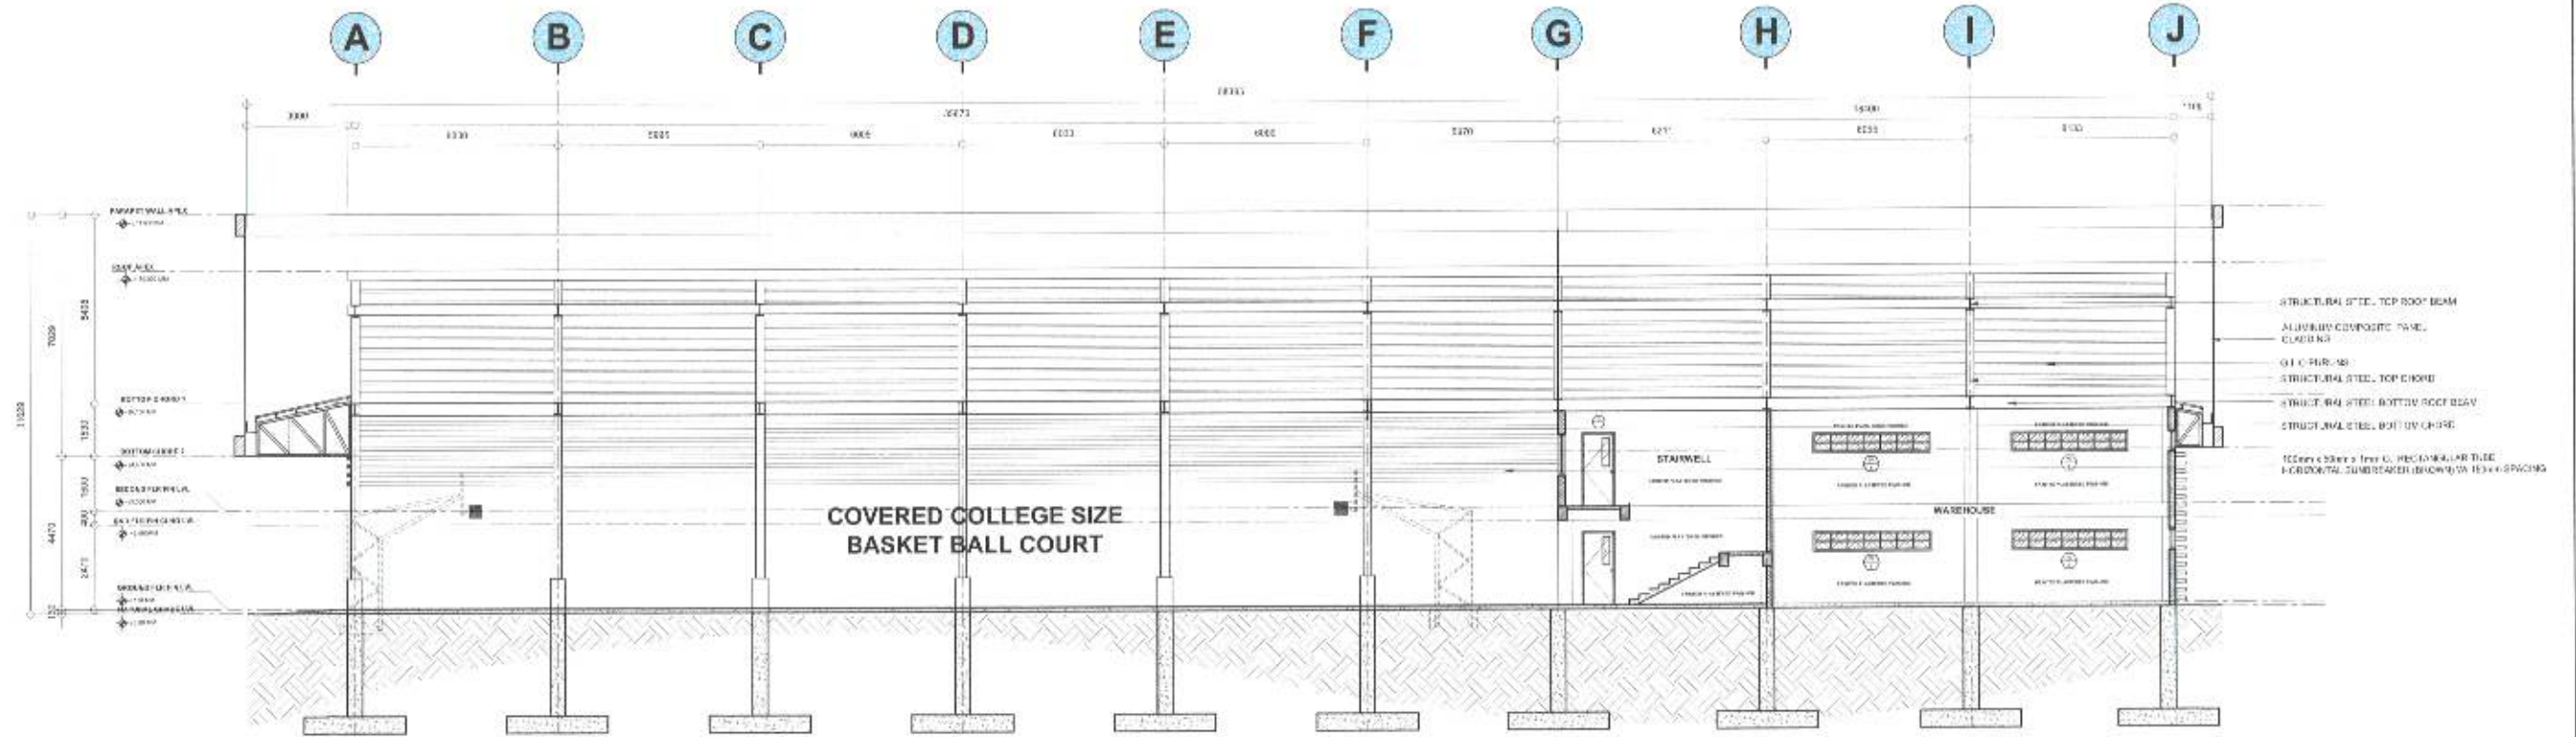

1 CROSS SECTION THRU "X"
SCALE 1:115 MTS.



2 LONGITUDINAL SECTION THRU "Y"
SCALE 1:115 MTS.

NOTE :

- ONLY THE ROOFING SHEETS, GUTTERS, FLASHING, WORKS (STEEL) AT COVERED COURT AREA AND ROOF-UP DOOR ARE INCLUDED IN THE PROGRAM OF WORK THE REST ARE NOT INCLUDED.



Republic of the Philippines
DEPARTMENT OF PUBLIC WORKS AND HIGHWAYS
MASBATE 2ND DISTRICT ENGINEERING OFFICE
City of Masbate, Masbate, Region V

PROJECT NAME AND LOCATION:
REPAIR / MAINTENANCE OF DOWN BUILDING
MASBATE 2ND DISTRICT ENGINEERING OFFICE
MAIN REPAIR BASE SHOP
AIRPORT ROAD, MASBATE CITY

SHEET CONTENTS:
CROSS SECTION THRU "X"
LONGITUDINAL SECTION THRU "Y"

DRAFTED:
JOHN PAUL M. AZARES
PROJECT DEVELOPMENT OFFICER I
DATE
PREPARED:
JULIUS ED A. ANCAJAS
ENGINEER I
DATE

REVIEWED:
RAUL B. DESUYO, JR.
ENGINEER II
DATE

SUBMITTED:
BONIFACIO A. TABIGUE
CHIEF, MAINTENANCE SECTION
DATE

RECOMMENDED:
MARIA ARRA PAZ G. SELLAR
OIC-ASSISTANT DISTRICT ENGINEER
DATE

APPROVED:
DENIS C. CAGOMOC
DISTRICT ENGINEER
DATE

SHEET NO.


A
7 13

SHEET NO.

11
34

NOTE :

ALL DOORS AND WINDOWS ARE NOT INCLUDED IN THE PROGRAM OF WORKS.

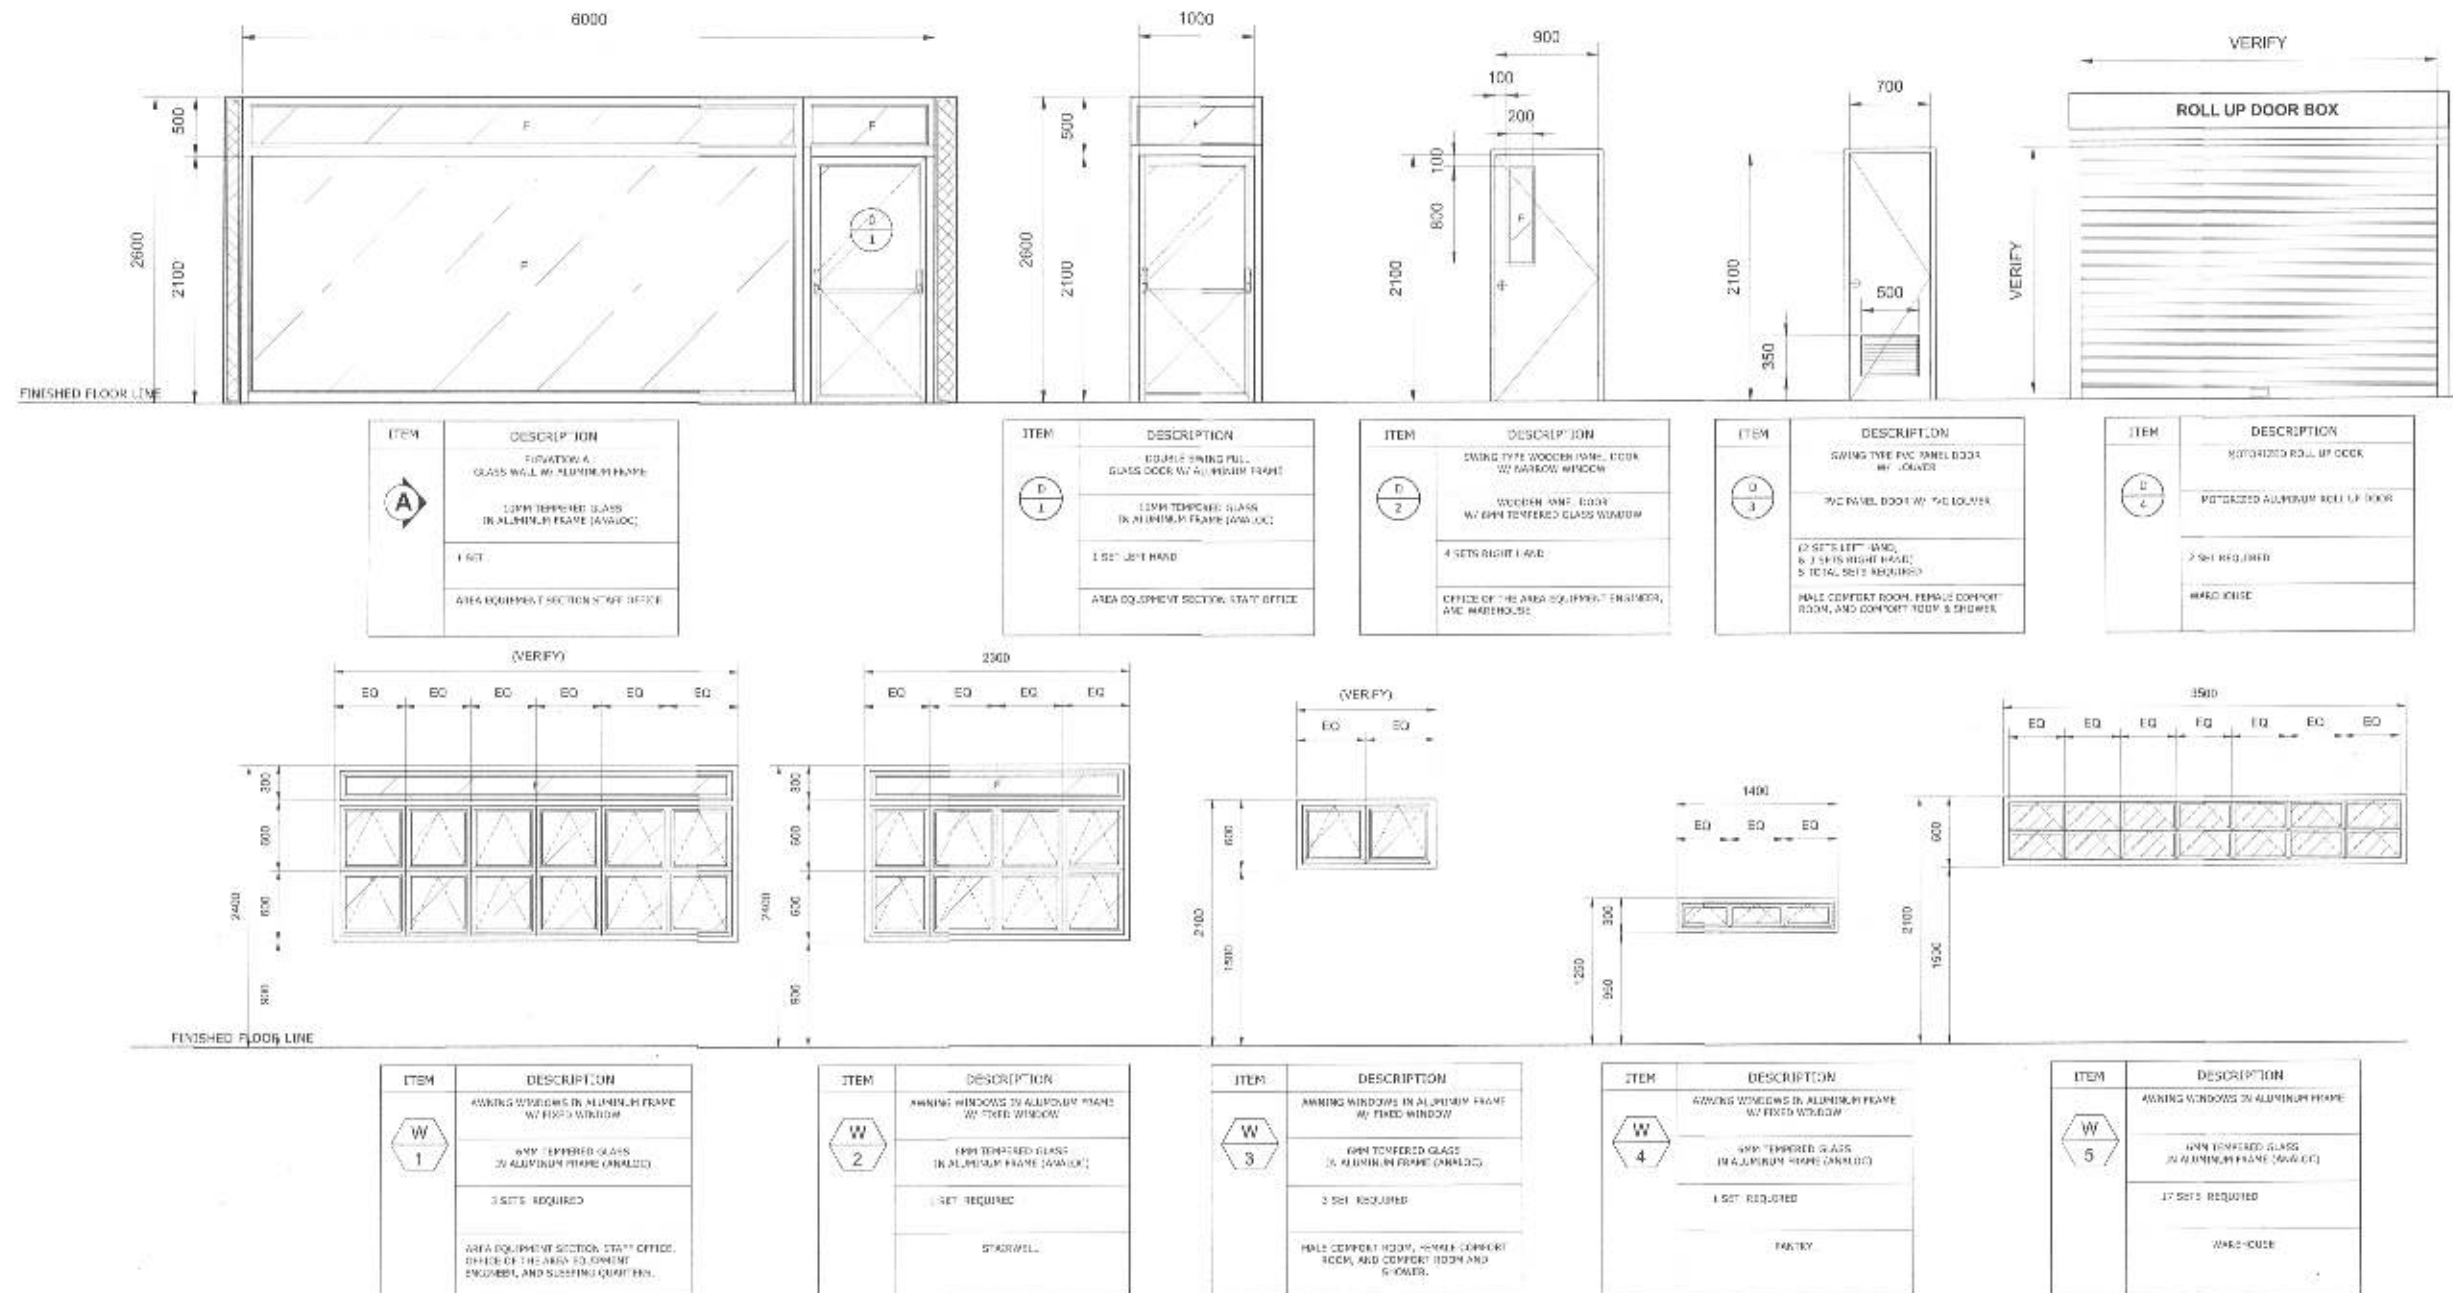

SCHEDULE OF DOORS AND WINDOWS SCALE 1:35 MTS.


Republic of the Philippines DEPARTMENT OF PUBLIC WORKS AND HIGHWAYS MASBATE 2ND DISTRICT ENGINEERING OFFICE City of Masbate, Masbate, Region V	PROJECT NAME AND LOCATION: REPAIR / MAINTENANCE OF BPNH BUILDING MASBATE 1 DISTRICT ENGINEERING OFFICE MAIN REPAIR BASE SHOP, AIRPORT ROAD, MASBATE CITY	SHEET CONTENTS: SCHEDULE OF DOORS AND WINDOWS	DRAFTED: JOHN PAUL M. AZARES PROJECT DEVELOPMENT OFFICER DATE: PREPARED: JULIUS ED A. ANCAJAS ENGINEER I DATE:	REVIEWED: RAUL B. DESUYO, JR. ENGINEER I DATE:	SUBMITTED: BONIFACIO A. TABIGUE CHIEF, MAINTENANCE SECTION DATE:	RECOMMENDED: MARIA ARRA PAZ G. SELLAR CIC ASSISTANT DISTRICT ENGINEER DATE:	APPROVED: DENIS C. CAGOMOC DISTRICT ENGINEER DATE:	SET NO. 8 13 SHEET NO. 12 34
---	---	--	---	---	---	--	---	---

LEGENDS:

- 2 X LED TUBE IN GRILL TYPE ENCLOSURE
- EMERGENCY LIGHT
- PIN LIGHT
- HIGH BAY LIGHT
- FLOOD LIGHT
- WALL MOUNTED LIGHT
- WALL MOUNTED FAN
- LINEAR LED LIGHT

NOTE :

- ONLY THE ROOFING SHEETS, GUTTERS, FLASHING, RIDGE/HIP ROLLS, AT COVERED COURT AREA ARE INCLUDED IN THE PROGRAM OF WORKS. THE REST ARE NOT INCLUDED (WAREHOUSE AREA).

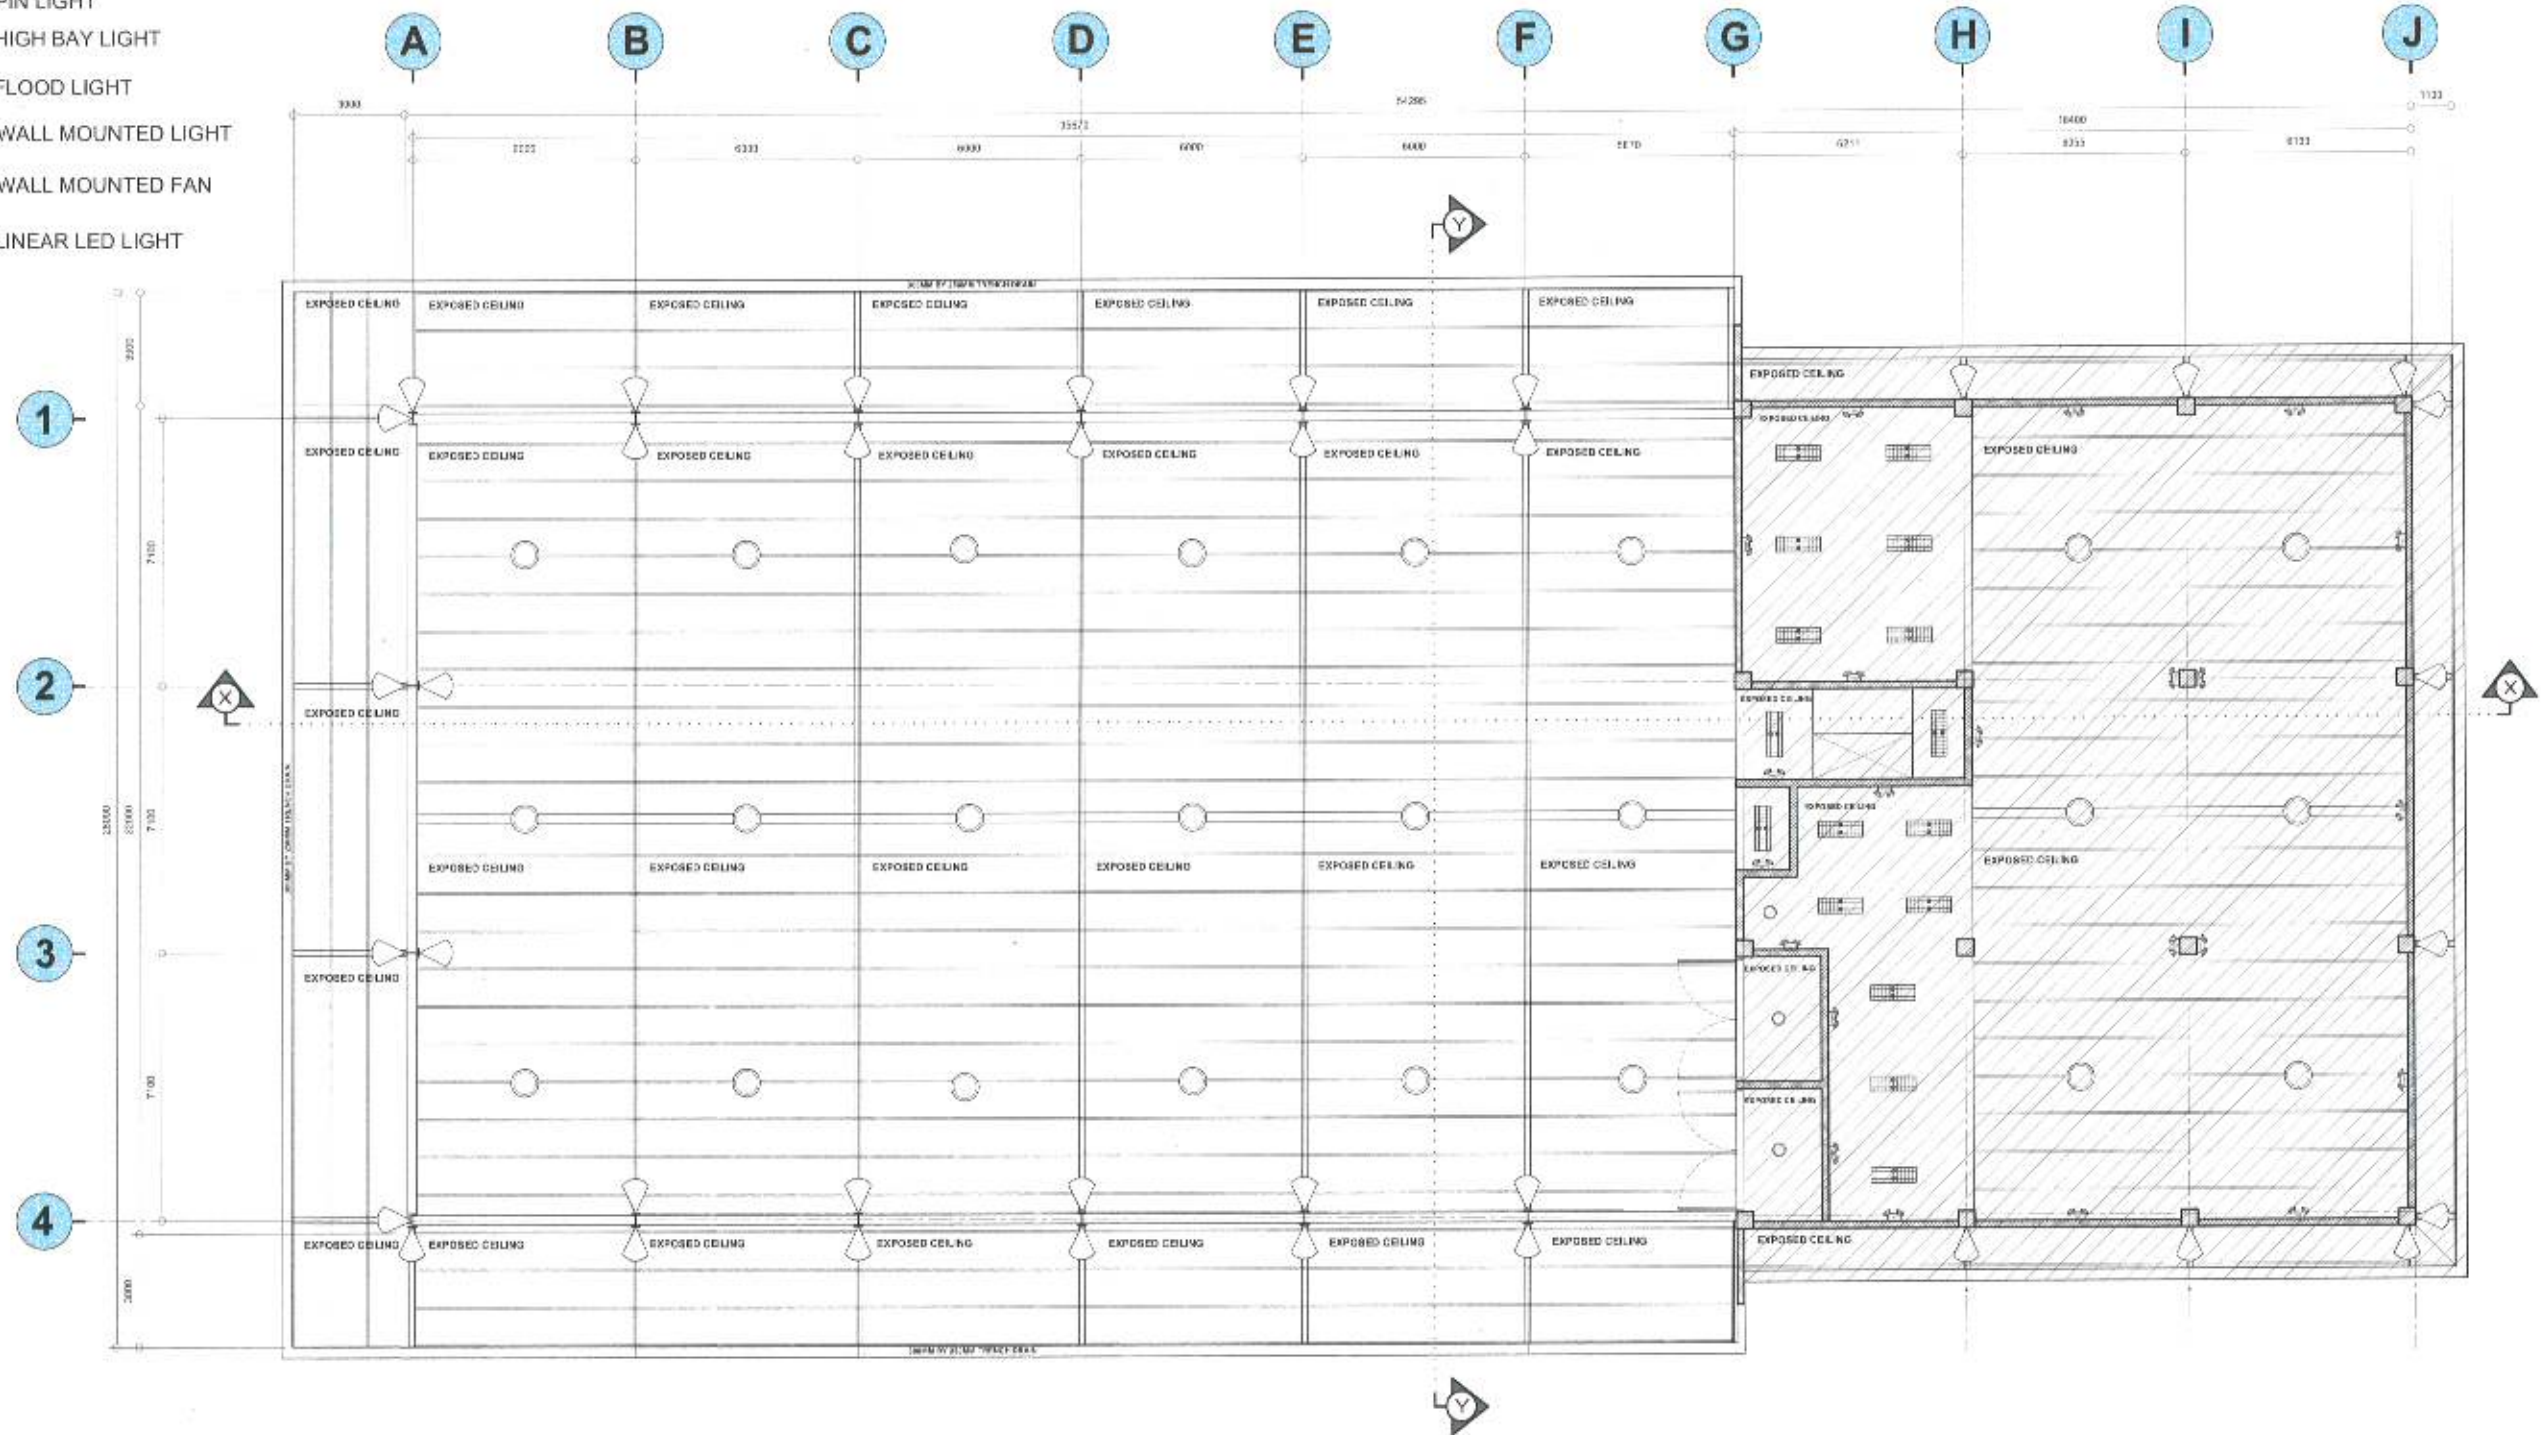

1
A 8 **GROUND FLOOR REFLECTED CEILING PLAN**
SCALE 1:110 MTS.


 Republic of the Philippines DEPARTMENT OF PUBLIC WORKS AND HIGHWAYS MASBATE 2ND DISTRICT ENGINEERING OFFICE City of Masbate, Masbate, Region V	PROJECT NAME AND LOCATION: REPAIR / IMPROVEMENT OF DPWH BUILDING MASBATE 1 DISTRICT ENGINEERING OFFICE MAIN REPAIR BASE SHOP AIRPORT ROAD, MASBATE CITY	SHEET CONTENTS: GROUND FLOOR REFLECTED CEILING PLAN	DRAFTED: JOHN PAUL M. AZARES PROJECT DEVELOPMENT OFFICER I DATE: _____ PREPARED: JULIUS ED A. ANCAJAS ENGINEER II DATE: _____	REVIEWED: RAUL B. DESUYO, JR. ENGINEER II DATE: _____	SUBMITTED: BONIFACIO A. TABIGUE CHIEF, MAINTENANCE SECTION DATE: _____	RECOMMENDED: MARIA ARRA PAZ G. SELLAR DIC-ASSISTANT DISTRICT ENGINEER DATE: _____	APPROVED: DENIS C. CAGOMOC DISTRICT ENGINEER DATE: _____	SET NO. SHEET NO. A 13 9 34
---	--	---	--	--	---	--	---	---

LEGENDS:

- 2 X LED TUBE IN GRILL TYPE ENCLOSURE
- EMERGENCY LIGHT
- PIN LIGHT
- HIGH BAY LIGHT
- FLOOD LIGHT
- WALL MOUNTED LIGHT
- WALL MOUNTED FAN
- LINEAR LED LIGHT

NOTE:

- ALL CEILING WORKS ARE NOT INCLUDED IN THE PROGRAM OF WORKS

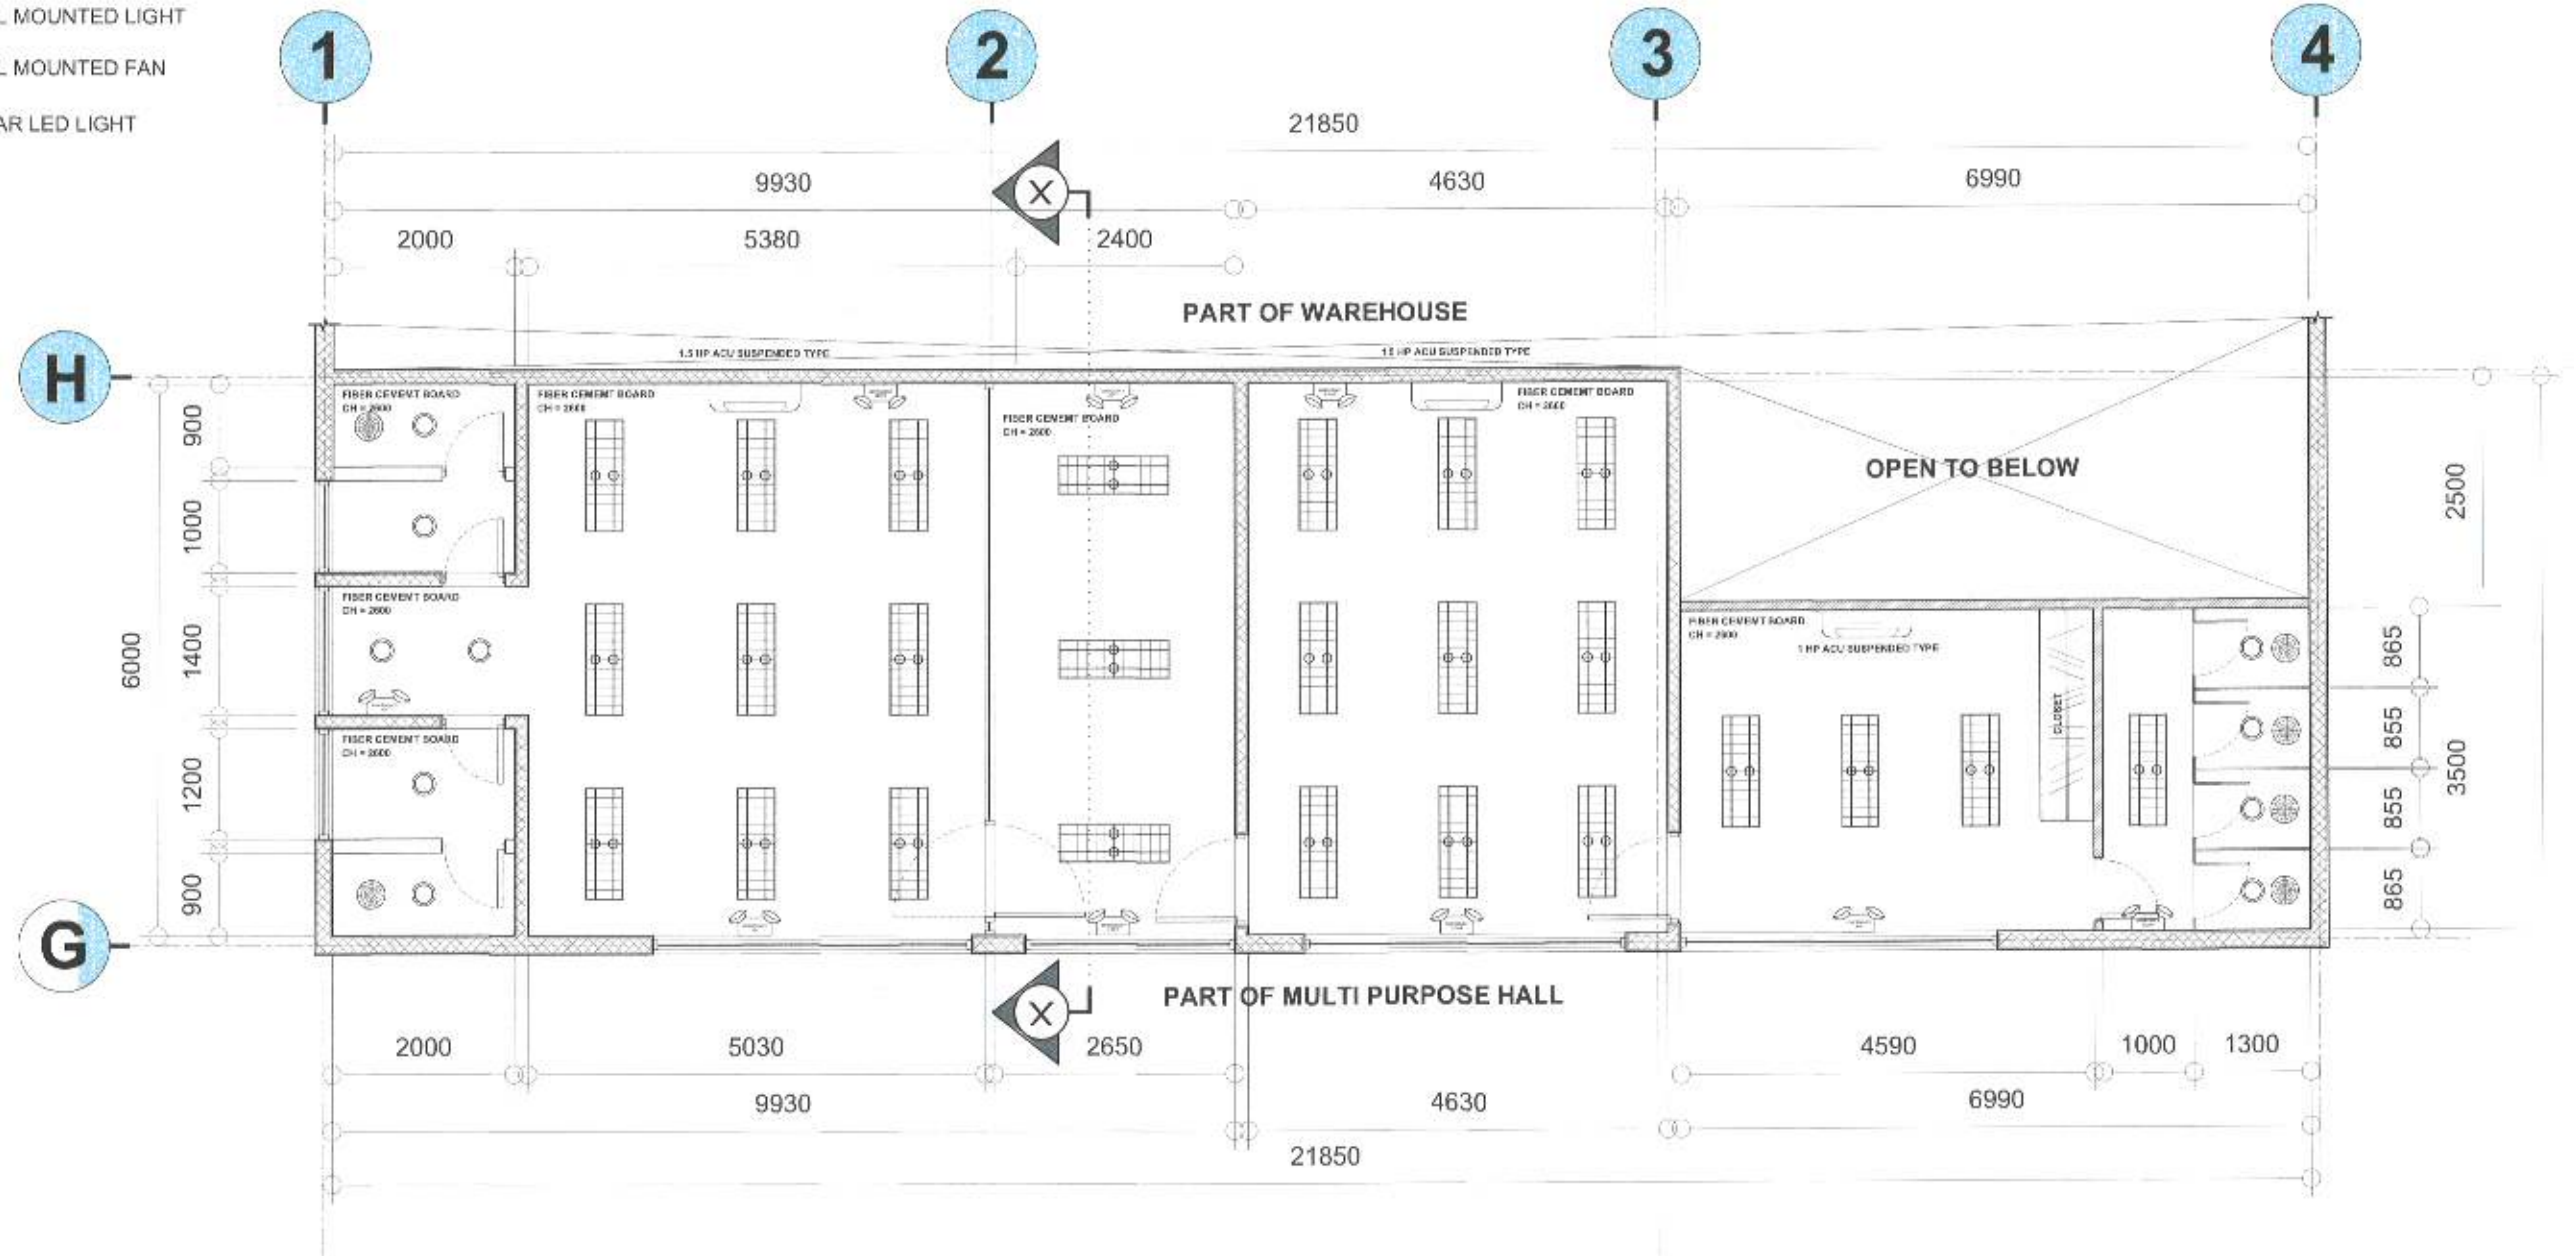

**SECOND FLOOR REFLECTED CEILING PLAN
(WAREHOUSE AREA)**

1
A 10

SCALE

1:45 MTS.



Republic of the Philippines
DEPARTMENT OF PUBLIC WORKS AND HIGHWAYS
MASBATE 2ND DISTRICT ENGINEERING OFFICE
City of Masbate, Masbate, Region V

PROJECT NAME AND LOCATION:
REPAIR / MAINTENANCE OF DPWH BUILDING
MASBATE 1 DISTRICT ENGINEERING OFFICE
MAIN REPAIR BASE SHOP
AIRPORT ROAD, MASBATE CITY

SHEET CONTENTS:
SECOND FLOOR
REFLECTED CEILING PLAN

DRAFTED:
JOHN PAUL M. AZARES
PROJECT DEVELOPMENT OFFICER I
DATE:
PREPARED:
JULIUS ED A. ANCAJAS
ENGINEER II
DATE:

REVIEWED:
RAUL B. DESUYO, JR.
ENGINEER II
DATE:

SUBMITTED:
BONIFACIO A. TABIGUE
CHIEF MAINTENANCE SECTION
DATE:

RECOMMENDED:
MARIA ARRA PAZ G. SELLAR
DIC-ASSISTANT DISTRICT ENGINEER
DATE:

APPROVED:
DENIS C. CAGOMOC
DISTRICT ENGINEER
DATE:

SET NO.
A
10 13

SHEET NO.
14
34

